



NSW GOVERNMENT
Planning

Issued under the Environmental Planning and Assessment Act 1979


Approved Section 75W Modification Application

No. MP09-0195 MOD 3 granted on the 01/11/2012


in respect to MP09-0195

Signed [Signature]

Sheet No. 2 of 3

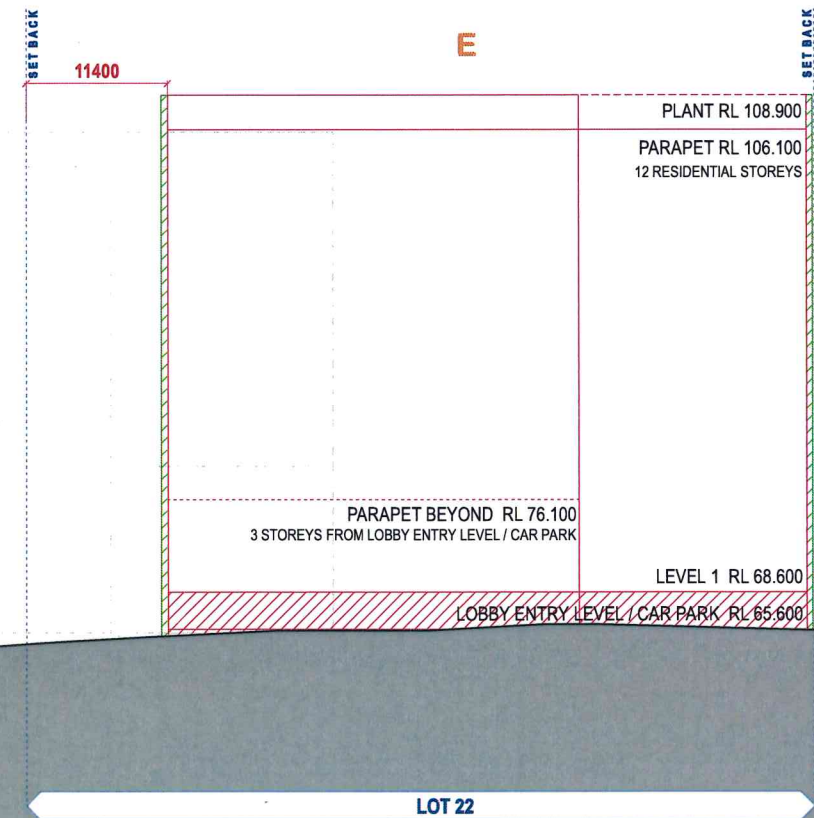

URBAN FORM CONTROL DIAGRAM _ SOUTH ELEVATION

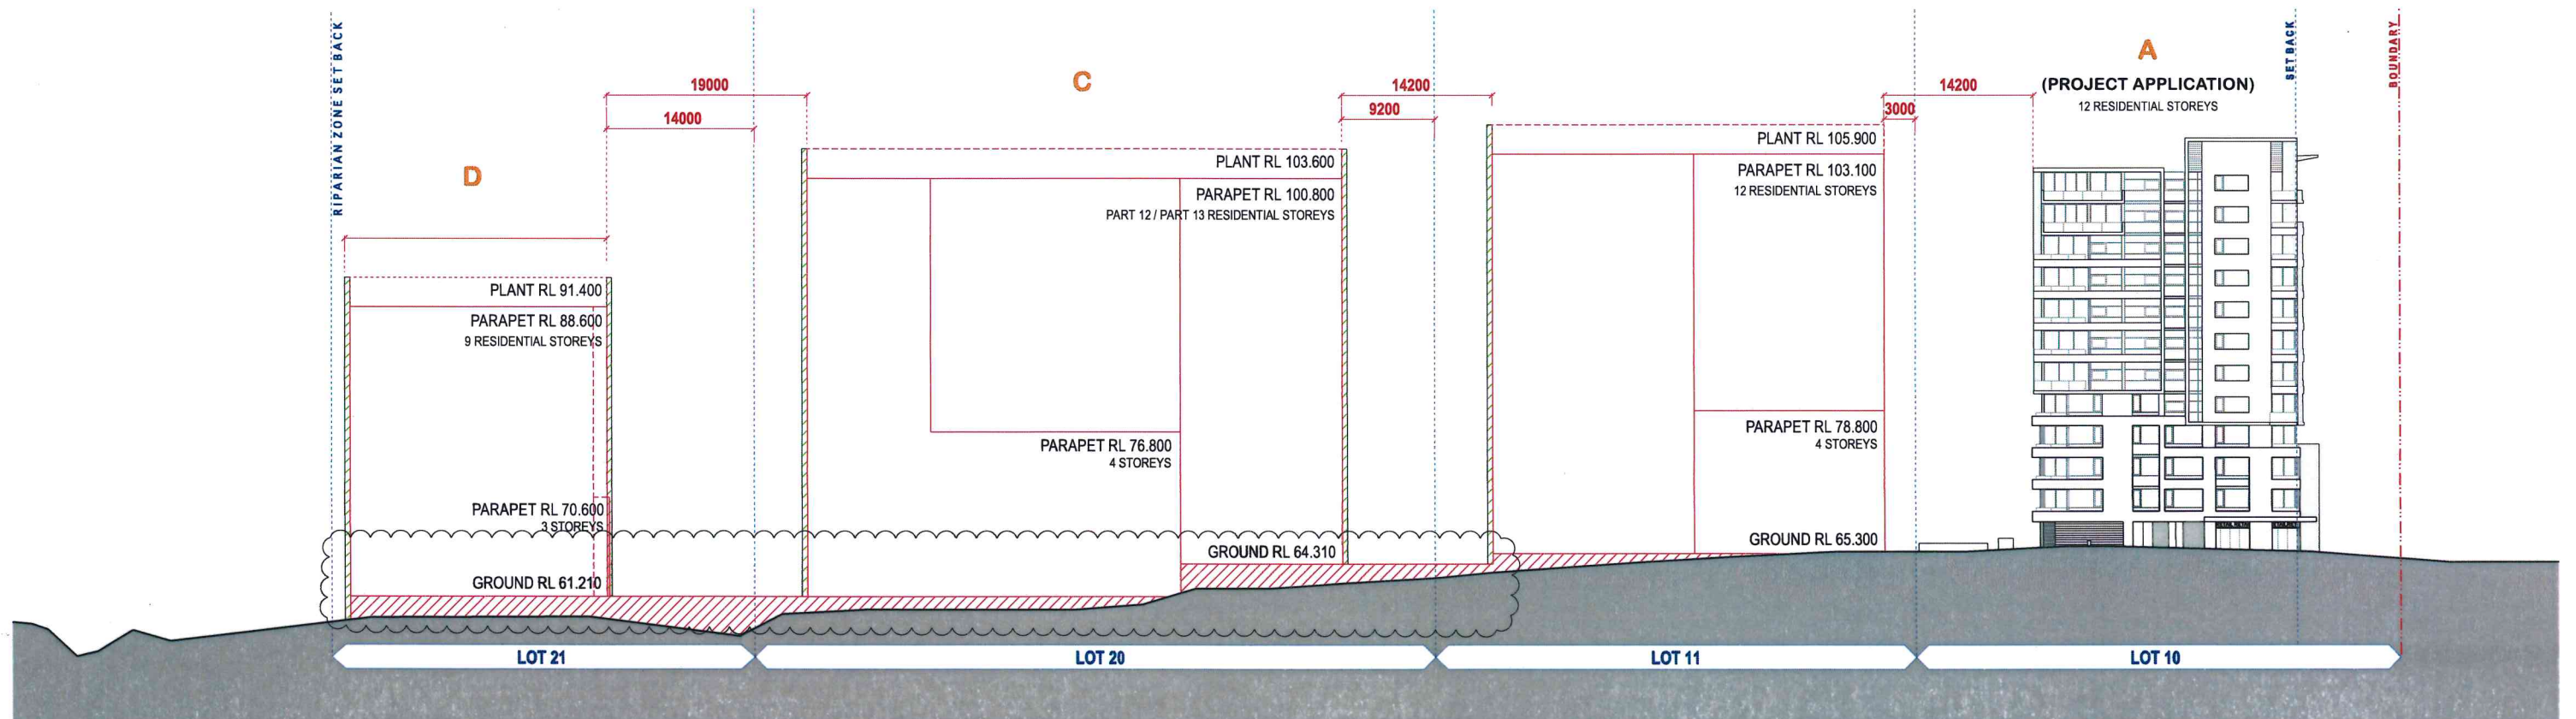

URBAN FORM CONTROL DIAGRAM _ ELEVATION ALONG HERRING ROAD

--- SITE BOUNDARY
--- STAGE BOUNDARY
--- GROUND LINE PODIUM PROFILE
--- PREDOMINANT FACADE LINE
--- ZONE FOR RE ENTRANT BALCONIES, 2.5 m DEEP - UNLESS OTHERWISE NOTED
--- ZONE FOR SAILIENT BALCONIES, 0.5 m DEEP - UNLESS OTHERWISE NOTED

TOGA GROUP
L5, 45 JONES STREET, ULTIMO NSW 2007
T 02 9356 1056 F 02 9356 1073

NOTES:
THIS DRAWING IS A PRELIMINARY DESIGN AND IS NOT TO BE USED FOR CONSTRUCTION. IT IS THE RESPONSIBILITY OF THE CLIENT TO OBTAIN ALL NECESSARY APPROVALS AND TO ENSURE THAT THE DESIGN IS IN ACCORDANCE WITH ALL APPLICABLE REGULATIONS AND STANDARDS.

PROJECT TITLE
RESIDENTIAL DEVELOPMENT
128 HERRING ROAD, MACQUARIE PARK
Urban Form Control Diagram, Elevations
CONCEPT PLAN

Rev: 01/11/12
Scale: 1:250
Drawing No: 09047
Sheet No: A 162
Turner + Associates
L1 410 Crown Street Sydney NSW 2010 Australia
T +61 2 8668 0000 F +61 2 8668 0088