


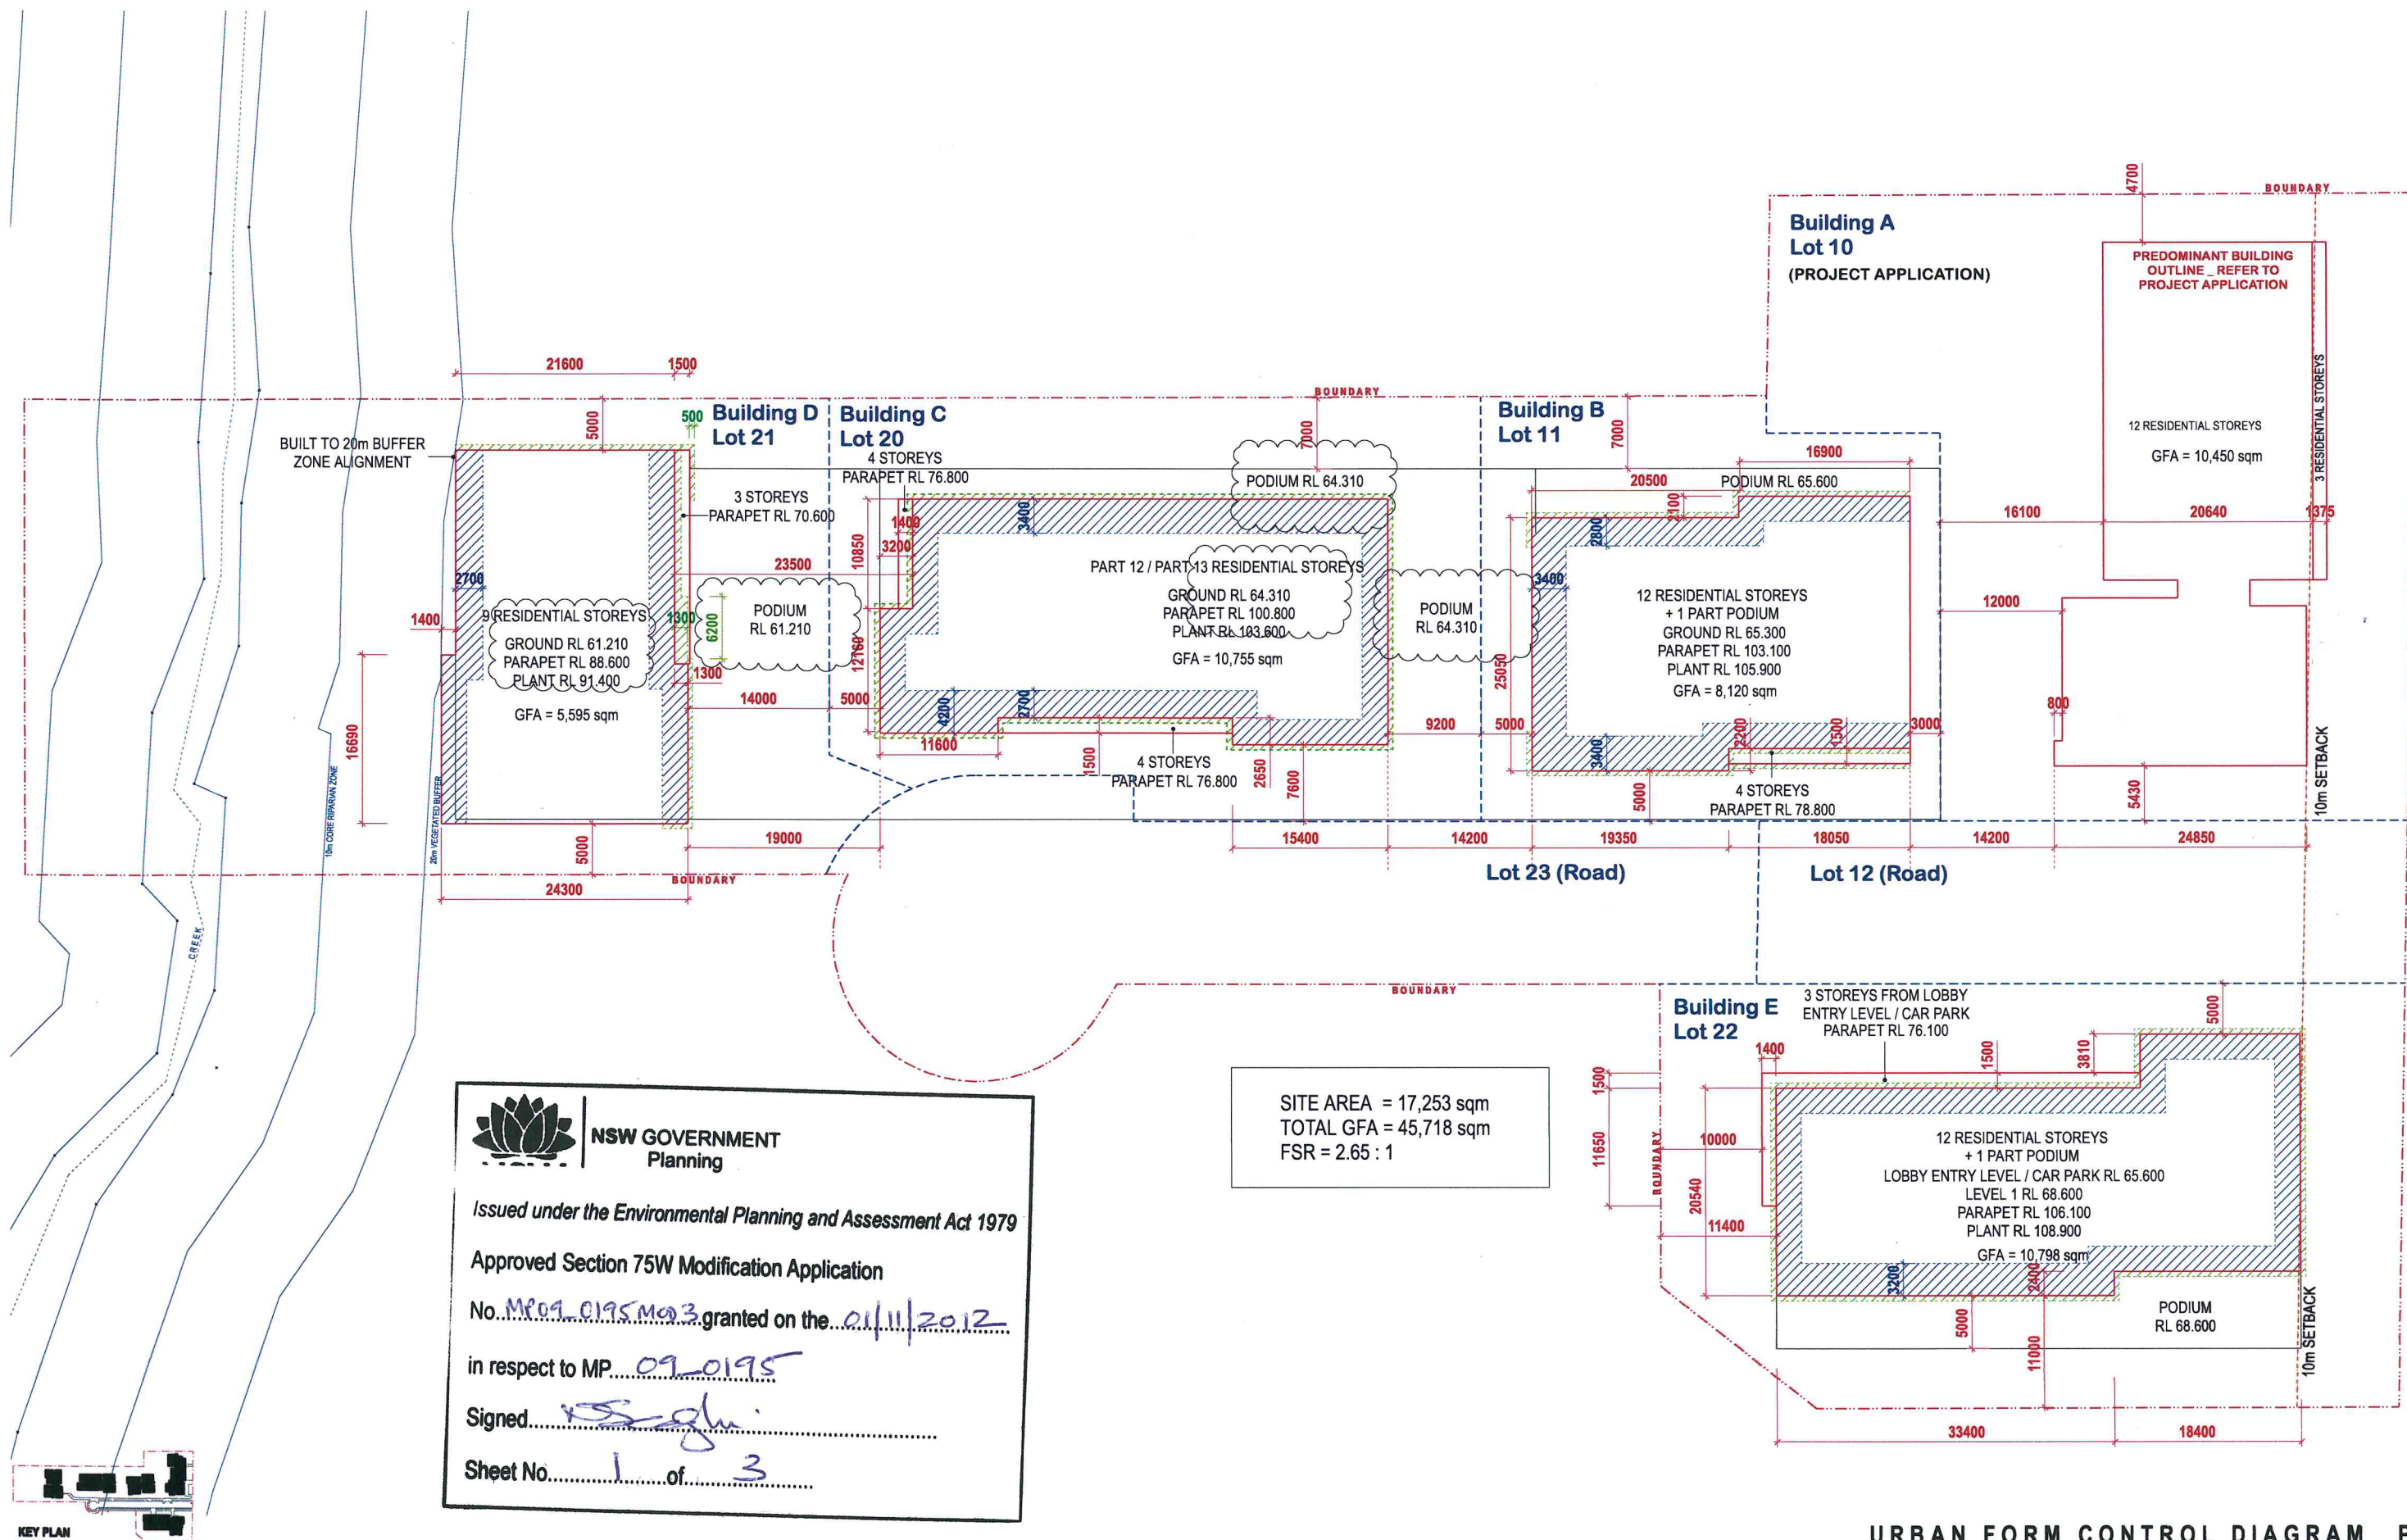

URBAN FORM CONTROL DIAGRAM _ PLAN

--- SITE BOUNDARY
 --- STAGE BOUNDARY
 --- GROUND LINE PODIUM PROFILE
 --- PREDOMINANT FACADE LINE
 --- ZONE FOR RE-ENTRANT BALCONIES, 2.5 m DEEP - UNLESS OTHERWISE NOTED
 --- ZONE FOR SAILIENT BALCONIES, 0.5 m DEEP - UNLESS OTHERWISE NOTED

TOGA GROUP
 L5, 45 JONES STREET, ULTIMO NSW 2007
 T 02 9356 1056 F 02 9356 1073

NOTES:
 THE DRAWING IS A PRELIMINARY DESIGN AND SHALL REMAIN THE PROPERTY OF TURNER + ASSOCIATES AND SHALL NOT BE REPRODUCED,
 COPIED OR OTHERWISE USED FOR ANY OTHER PURPOSE WITHOUT THE WRITTEN PERMISSION OF TURNER + ASSOCIATES.
 THE DRAWING IS NOT FOR CONSTRUCTION. IT IS FOR INFORMATION ONLY.

PROJECT TITLE:
 RESIDENTIAL DEVELOPMENT
 128 HERRING ROAD, MACQUARIE PARK
 Urban Form Control Diagram, Plan
 CONCEPT PLAN

L 21/10/12
 K 16/12/12
 R 20/11/12
 Date: 20/11/12
 Scale: 1:250 @ 1:40% @ A3
 Project No: 09047
 Drawing No: A 161
 Rev: L
 NORTH
 TURNER + ASSOCIATES
 L1 410 Crown Street Sydney Hills NSW 2010 Australia
 T +61 2 8666 0000 F +61 2 8666 0088