



A.




Key Plan A
FIGURE 18 REV 12 1 : 2500

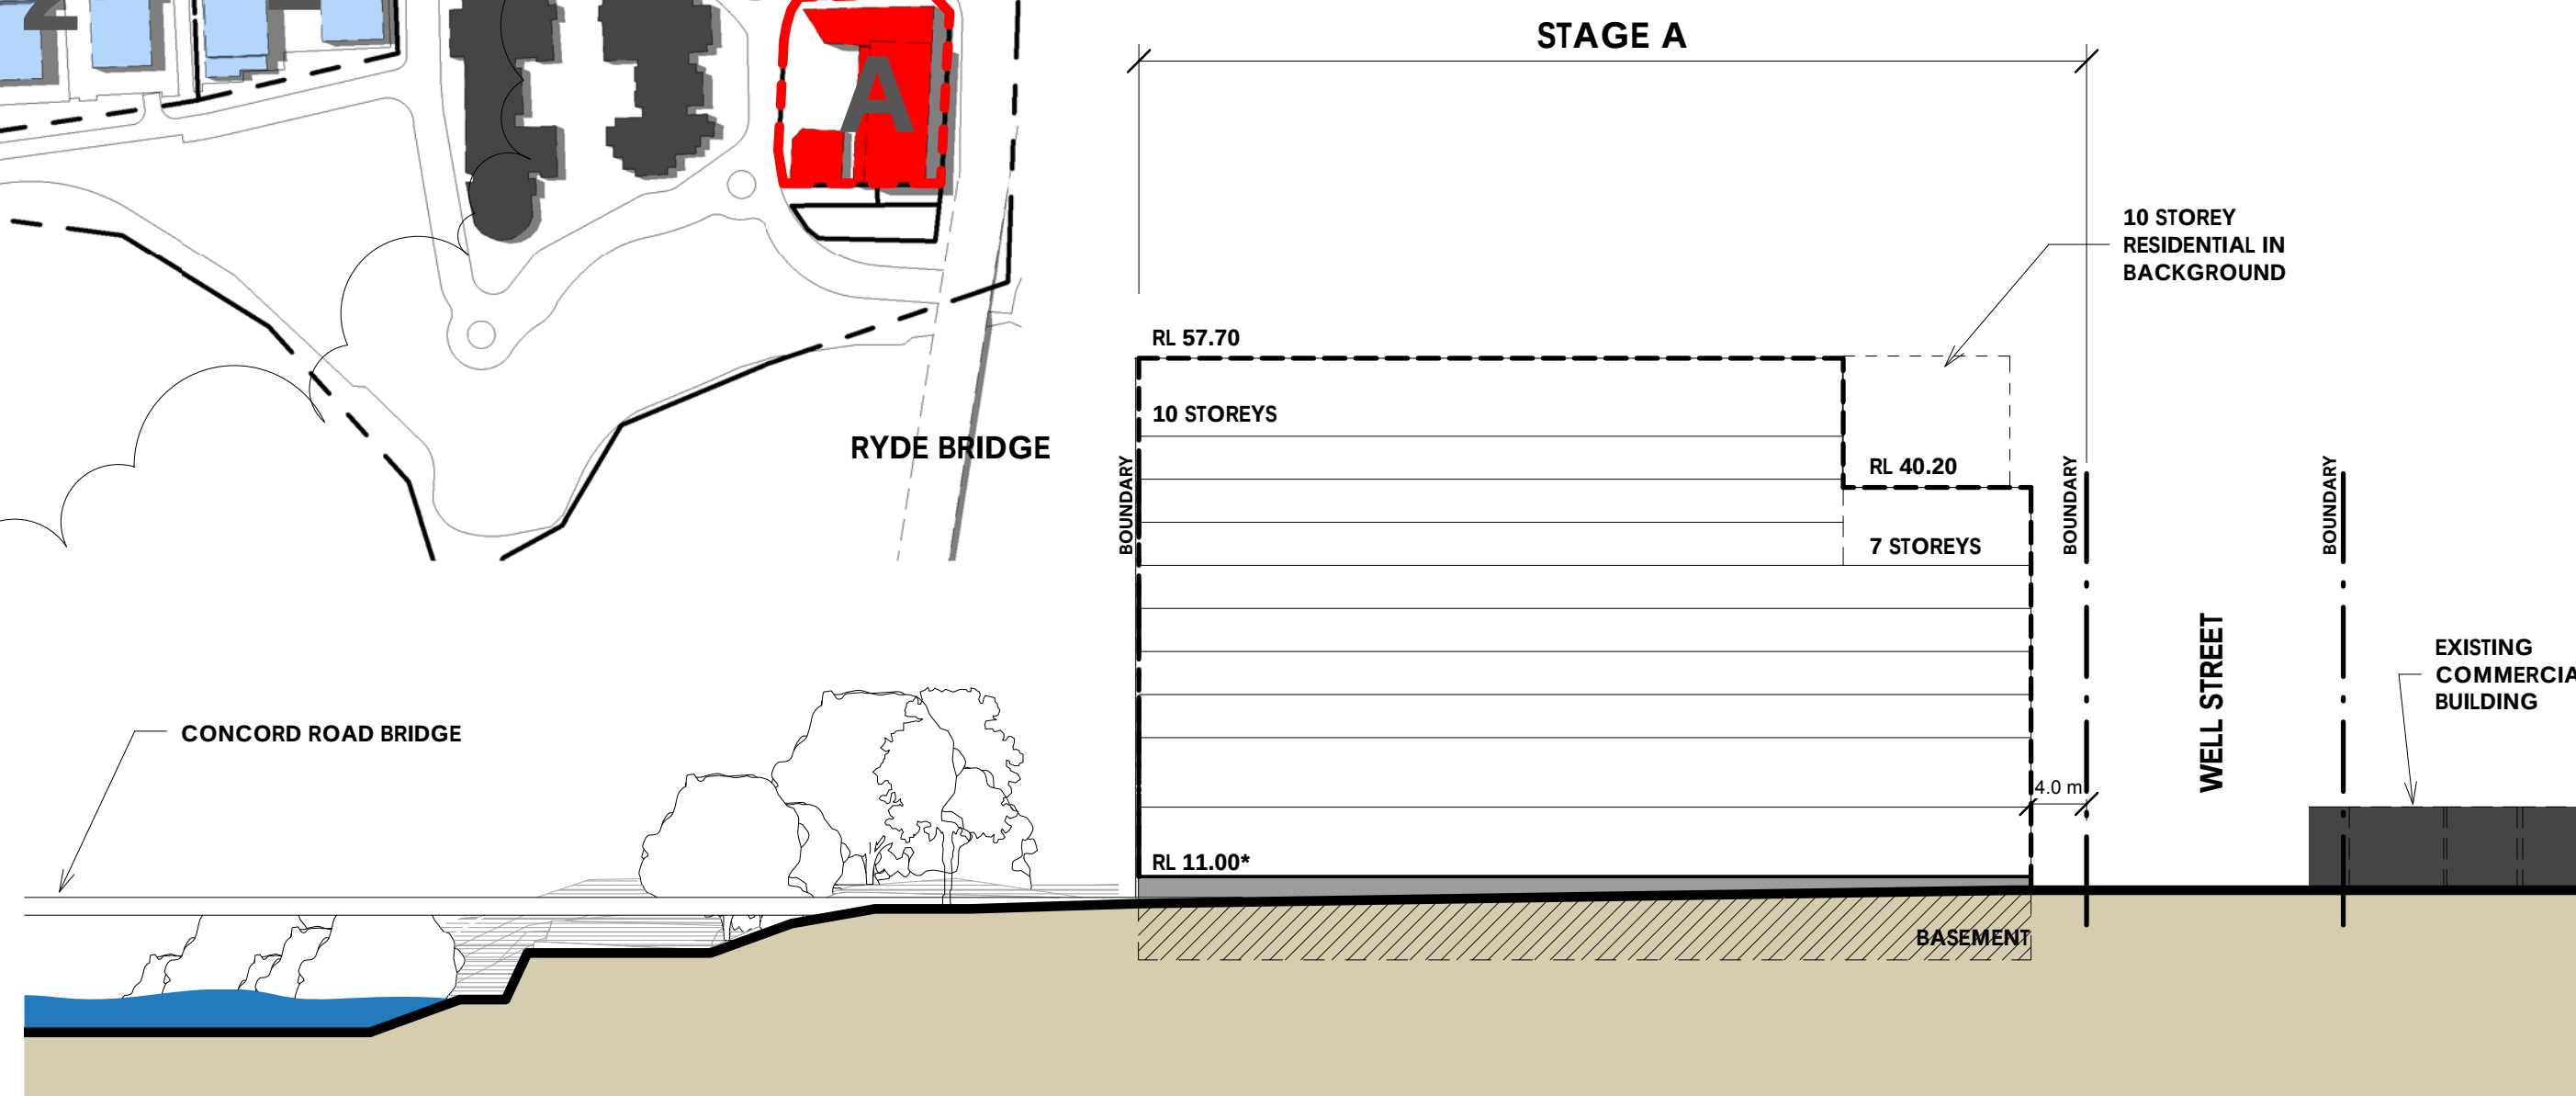


A. Church Street
FIGURE 18 REV 12 1 : 500

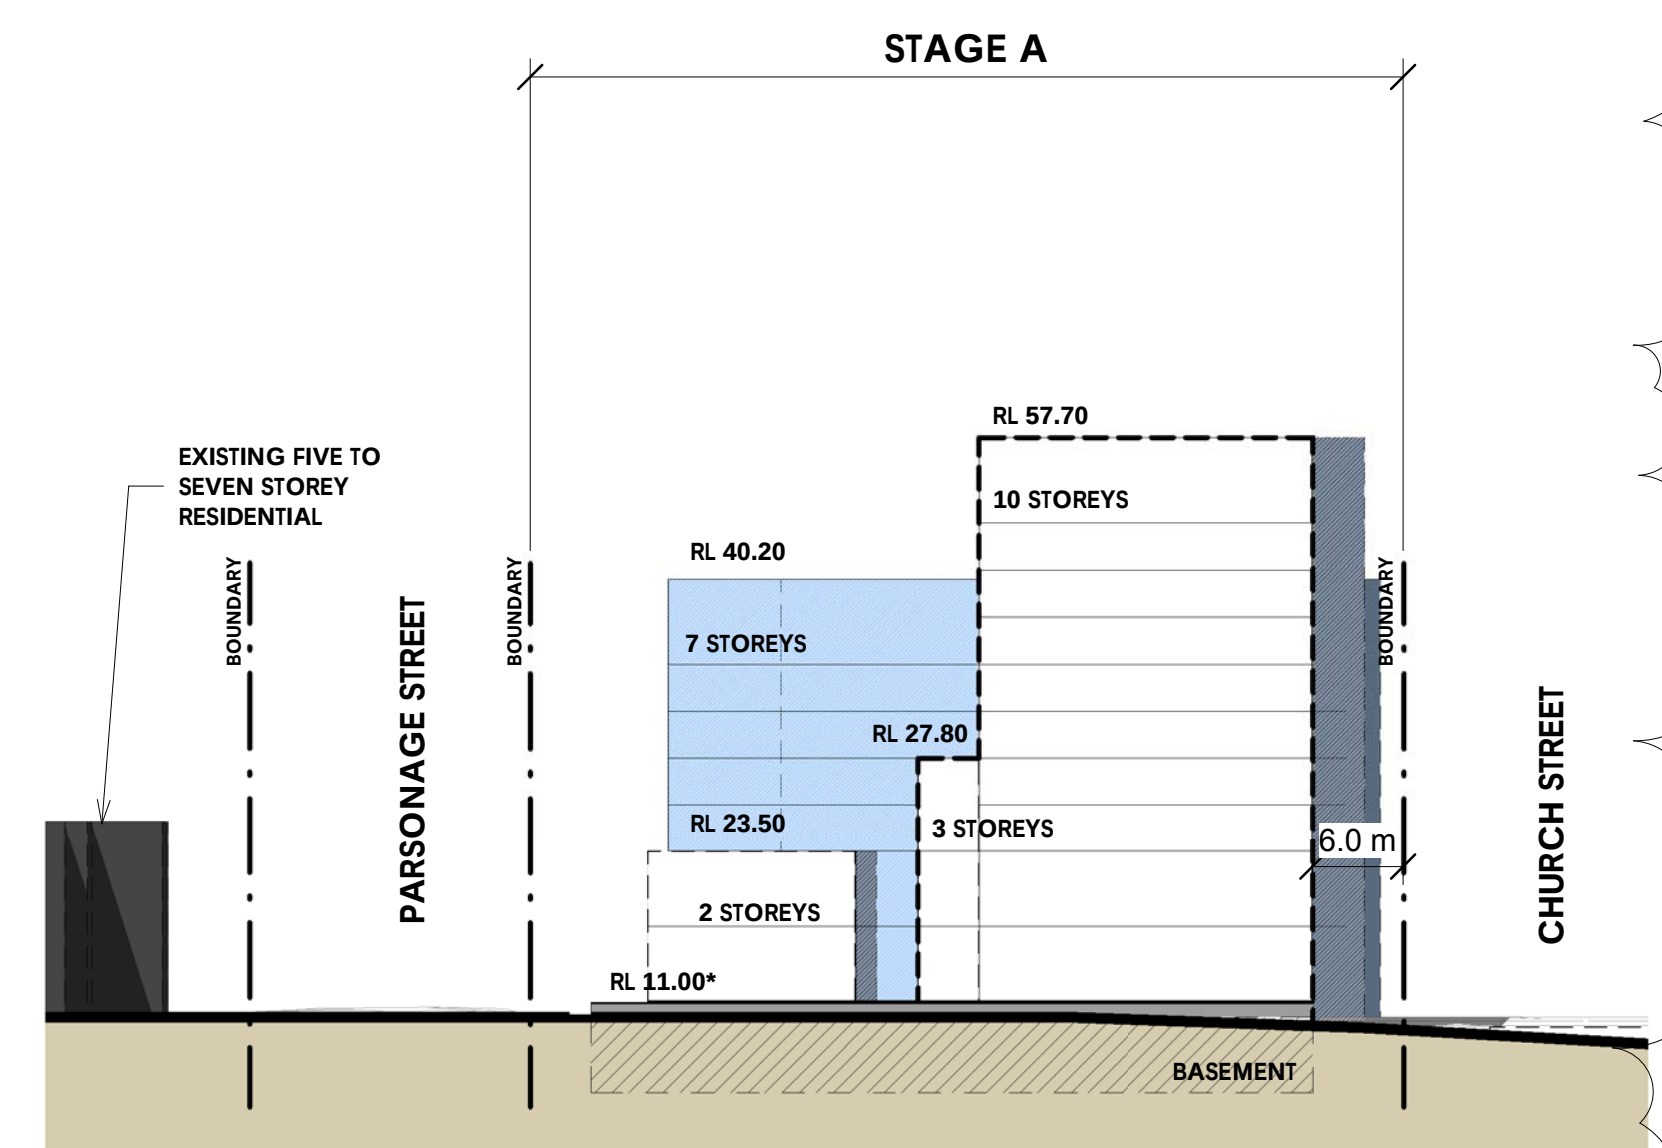


A. Elevation 3
FIGURE 18 REV 12 1 : 500

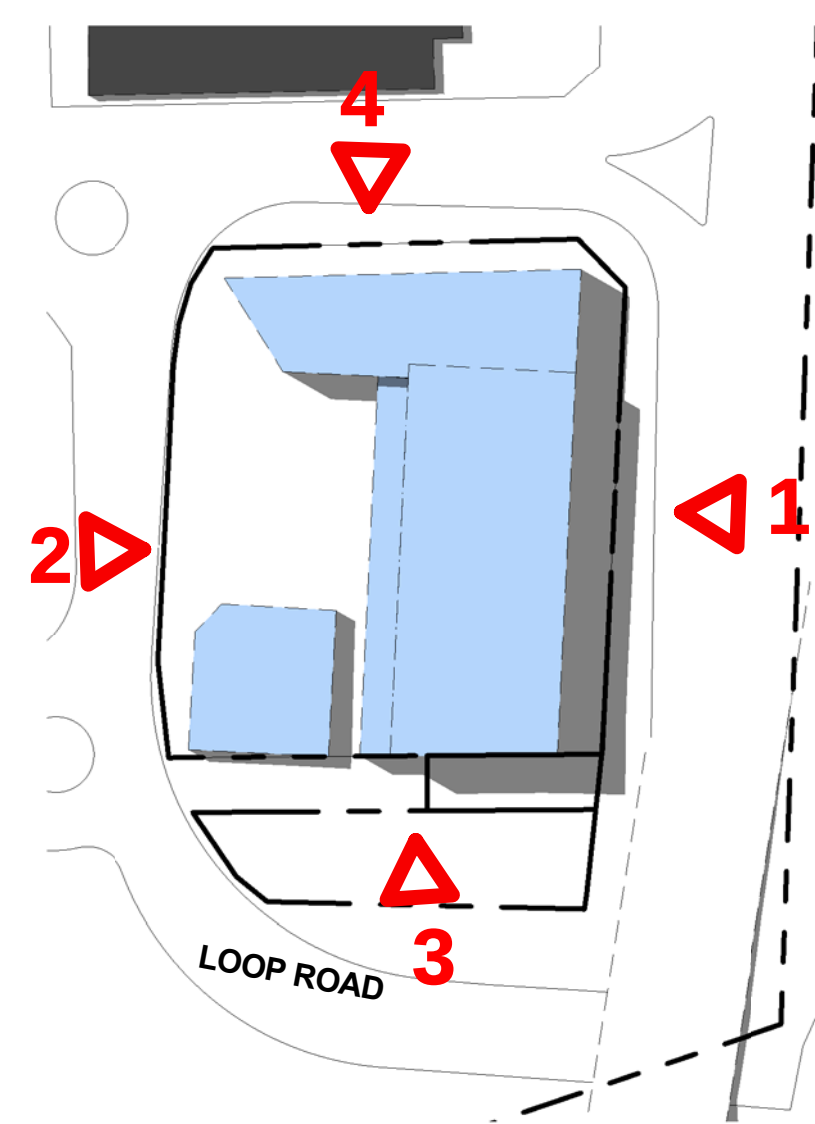

A. Building Envelope Plan
FIGURE 18 REV 12 1 : 1000

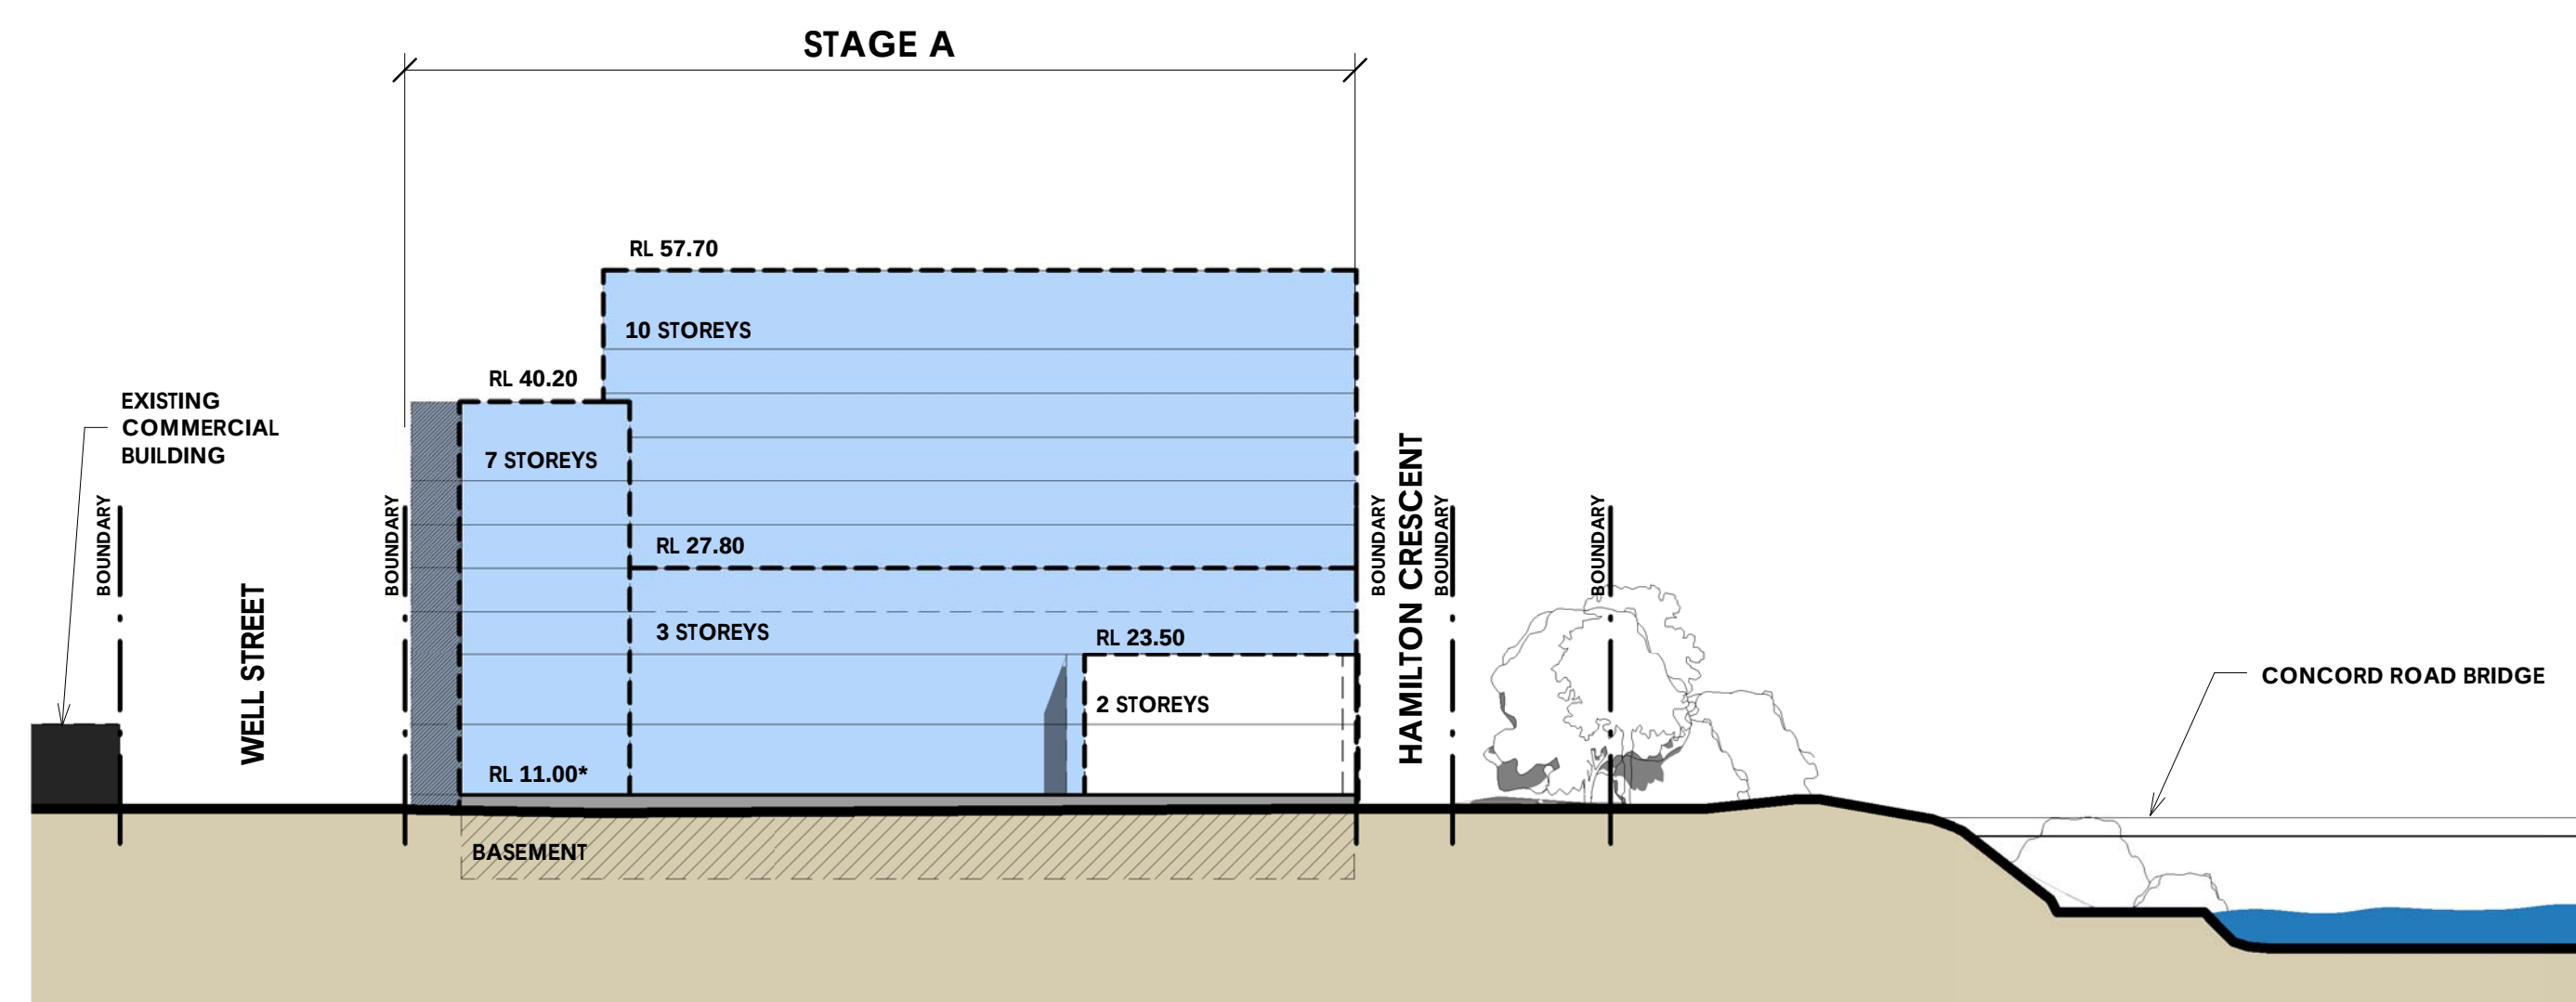

A. Parsonage Street
FIGURE 18 REV 12 1 : 500

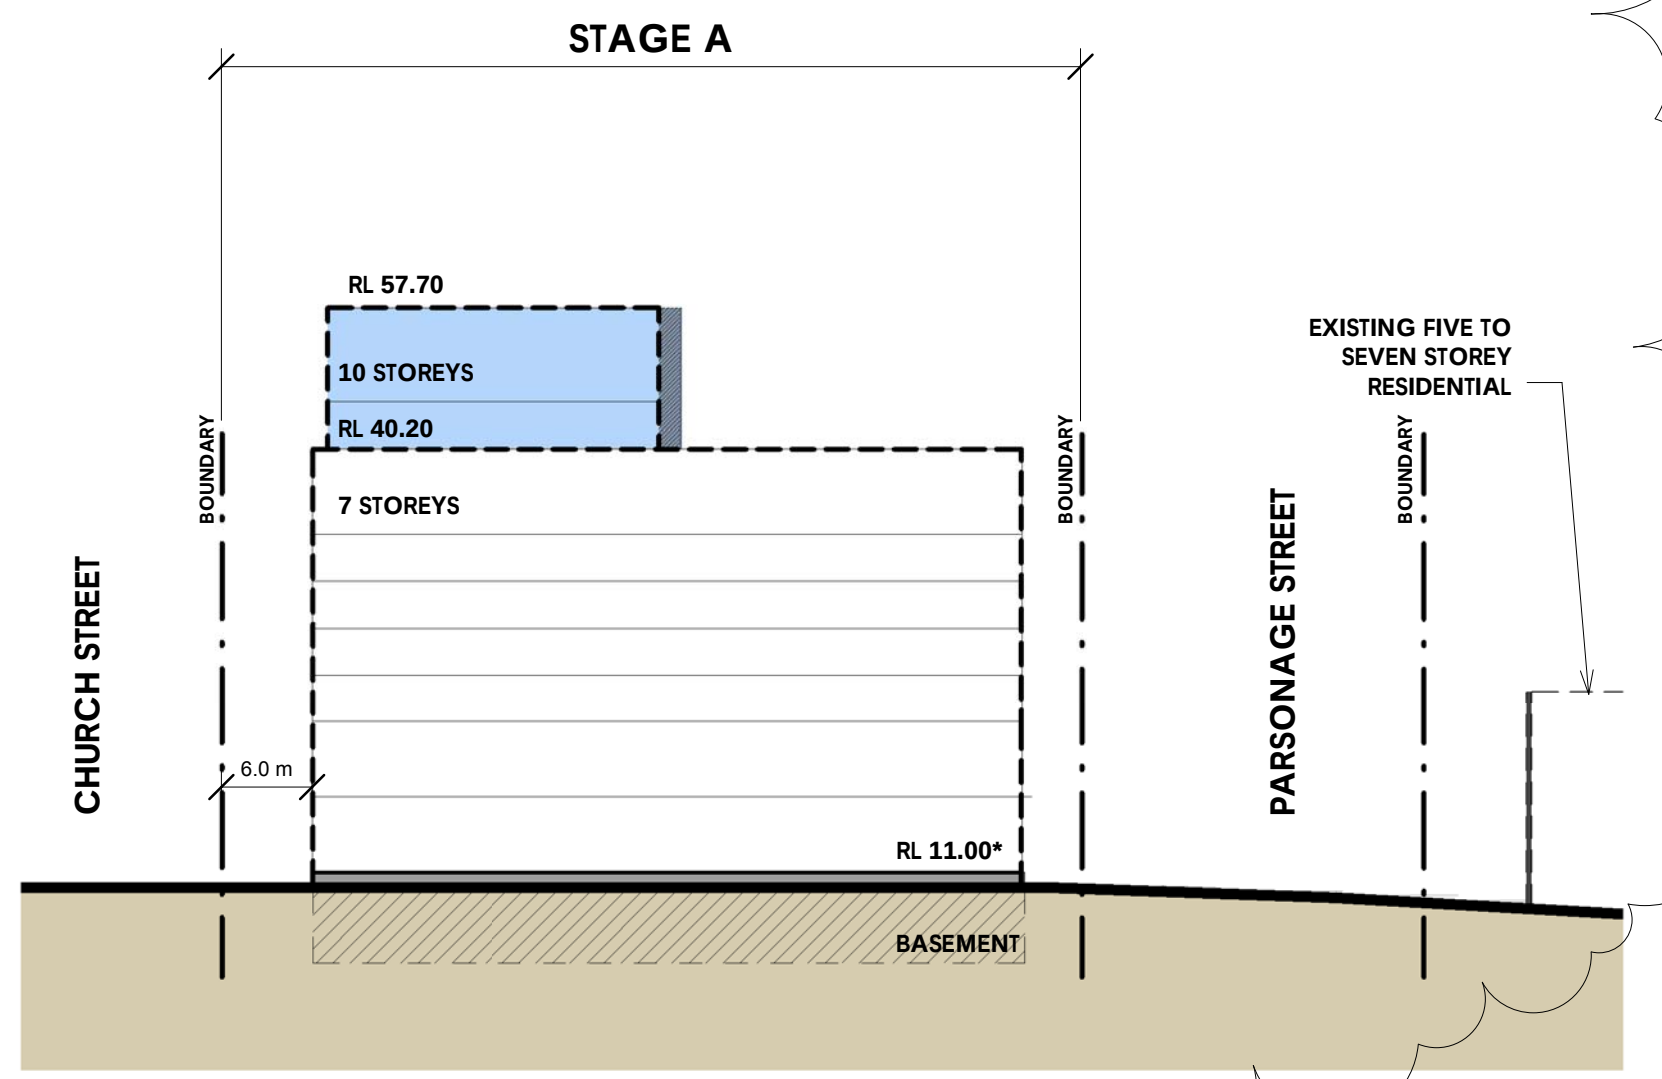

A. Well Street
FIGURE 18 REV 12 1 : 500

NOTE: SCALED TO A1 SIZE SHEET. * ASSUMED GROUND RL AS PER METHOD OF DEFINING HEIGHT (PG 33, Fig 12)

SHEPHERDS BAY URBAN RENEWAL

PROJECT MASTER PLAN STAGE A. BUILDING ENVELOPE CONTROL DIAGRAMS

FIGURE 18 REV 12

Job no: 10068.2 Date: 23/02/17 , Scale: As indicated

ROBERTSON + MARKS

10 10 20 30 40 50 100 200 500m