




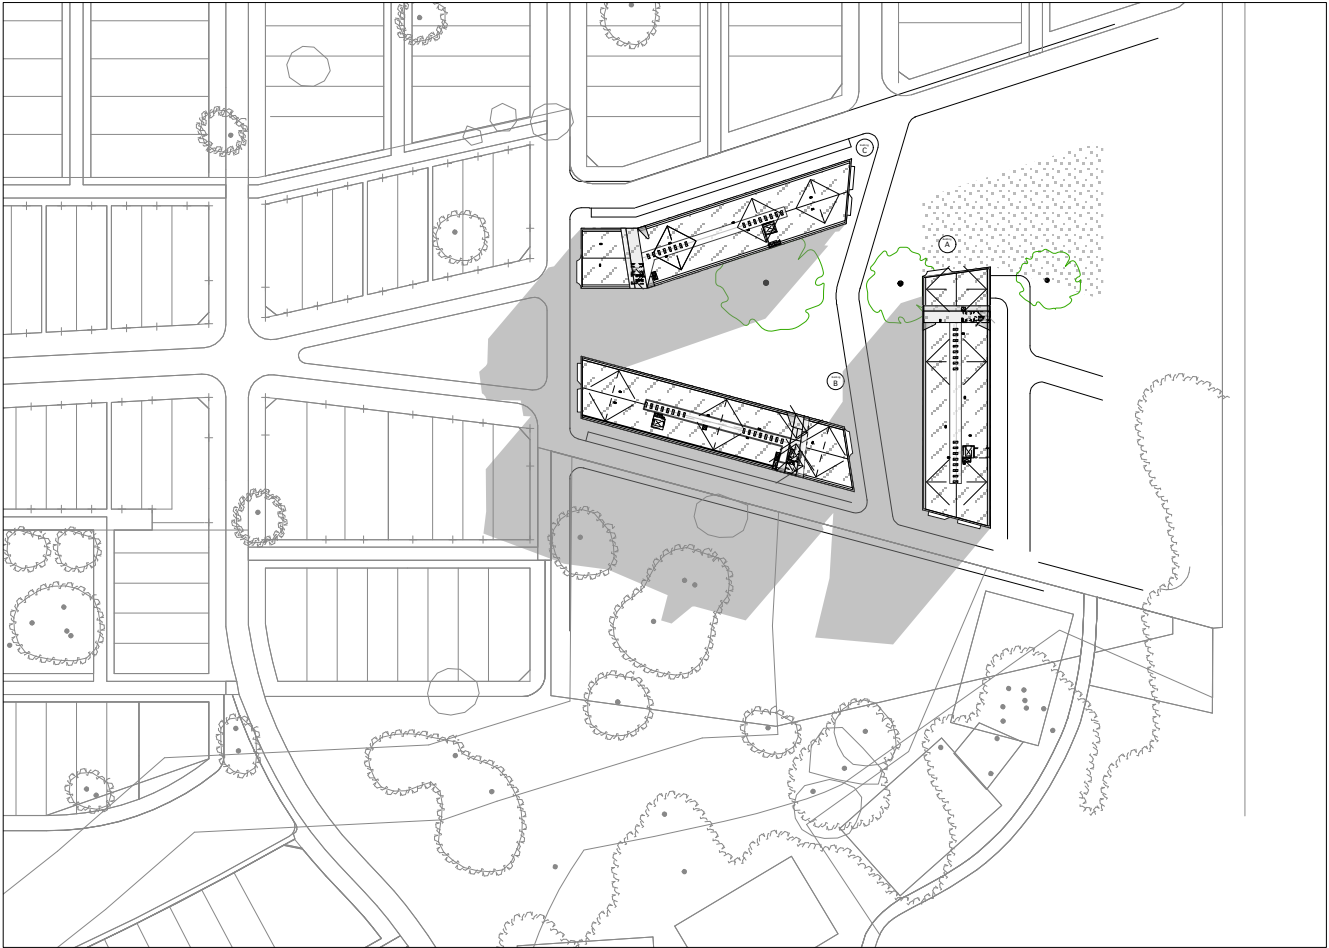


June 22, 9am

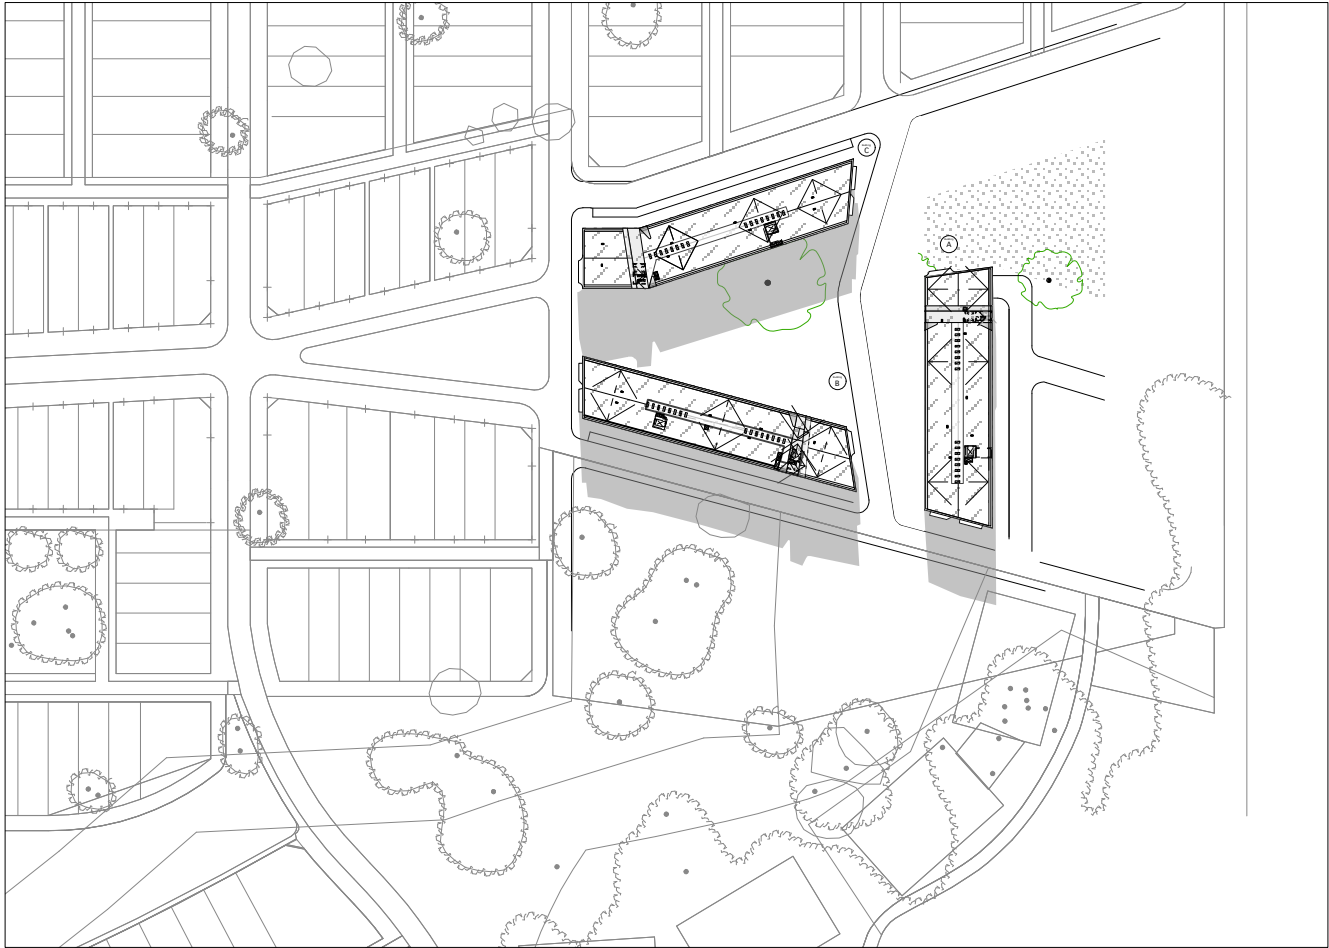


June 22, Noon

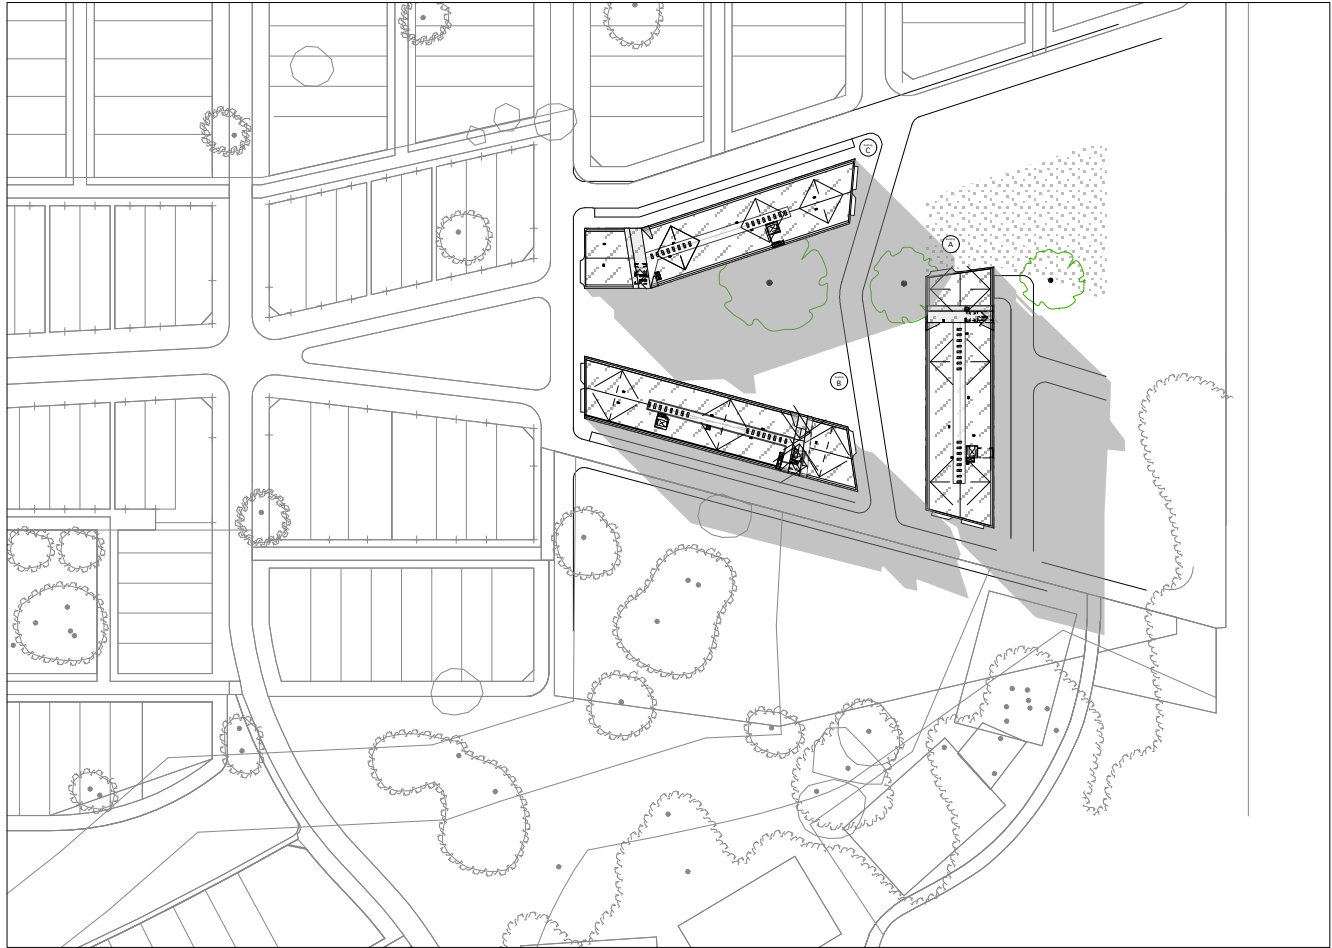


June 22, 3pm

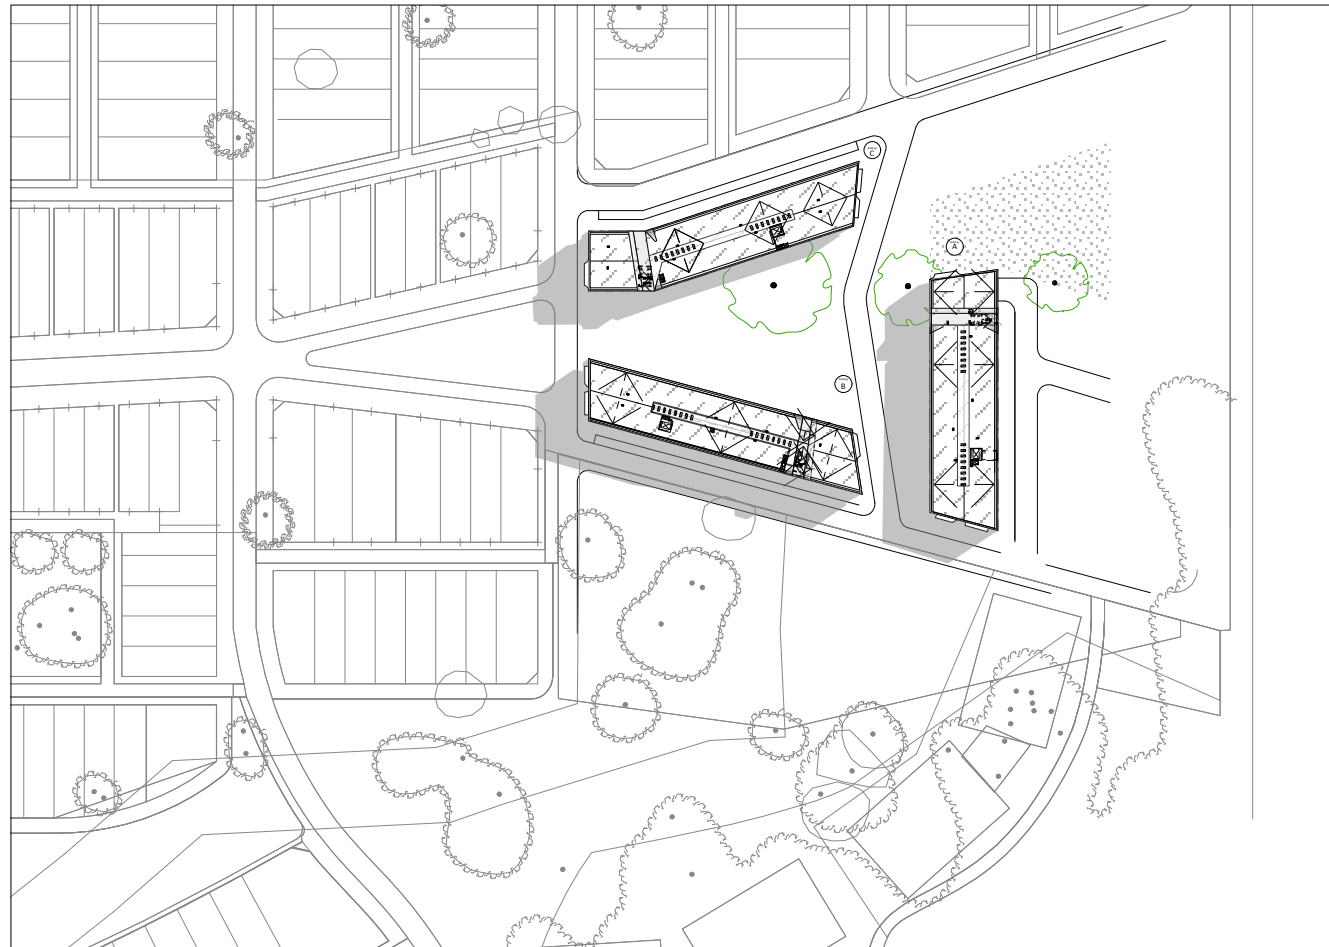


September 23rd, 9am

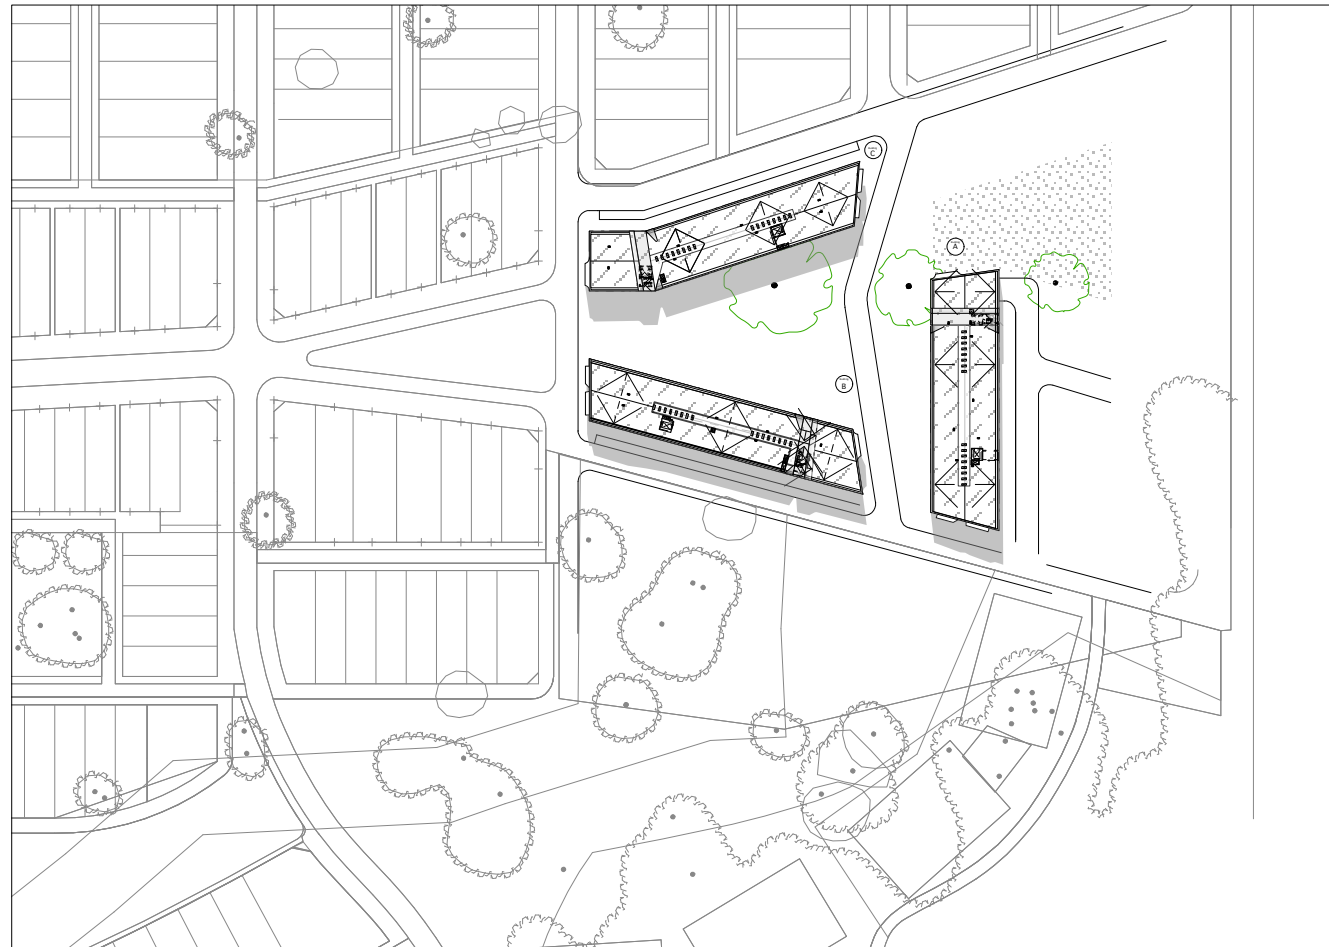


September 23rd, Noon

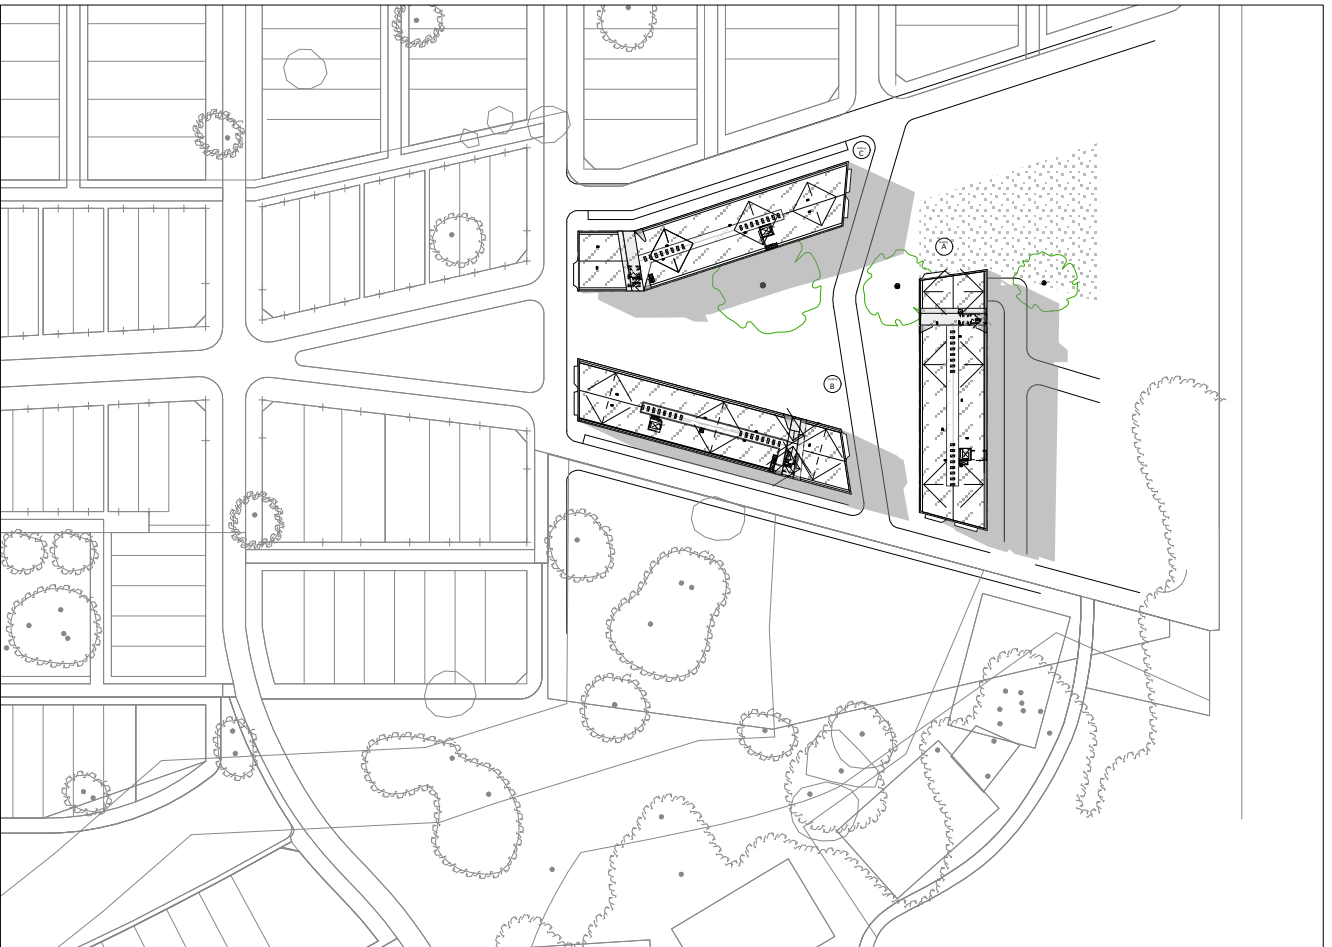


September 23rd, 3pm

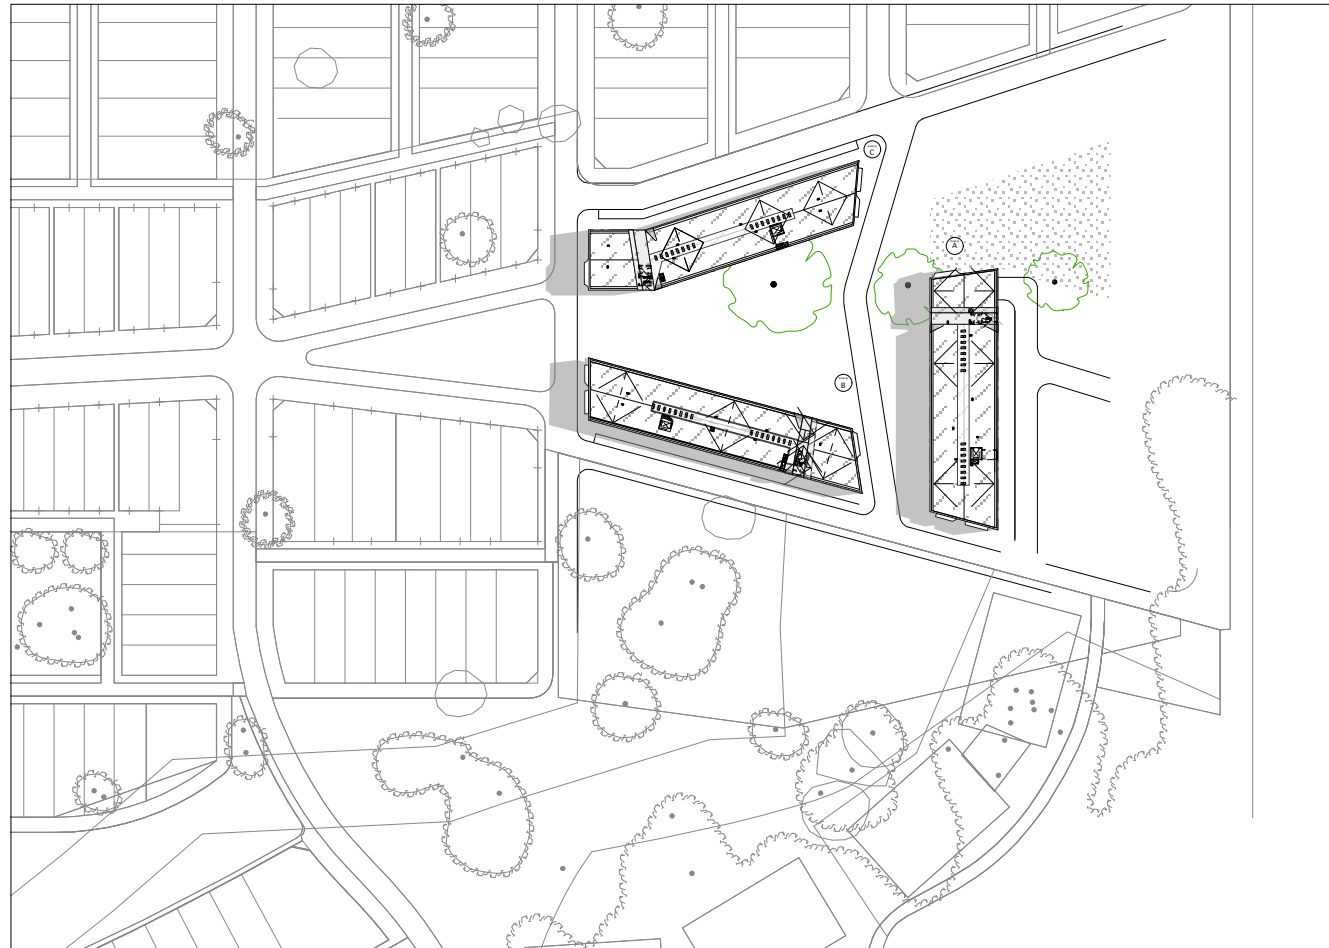

December 23rd, 9am

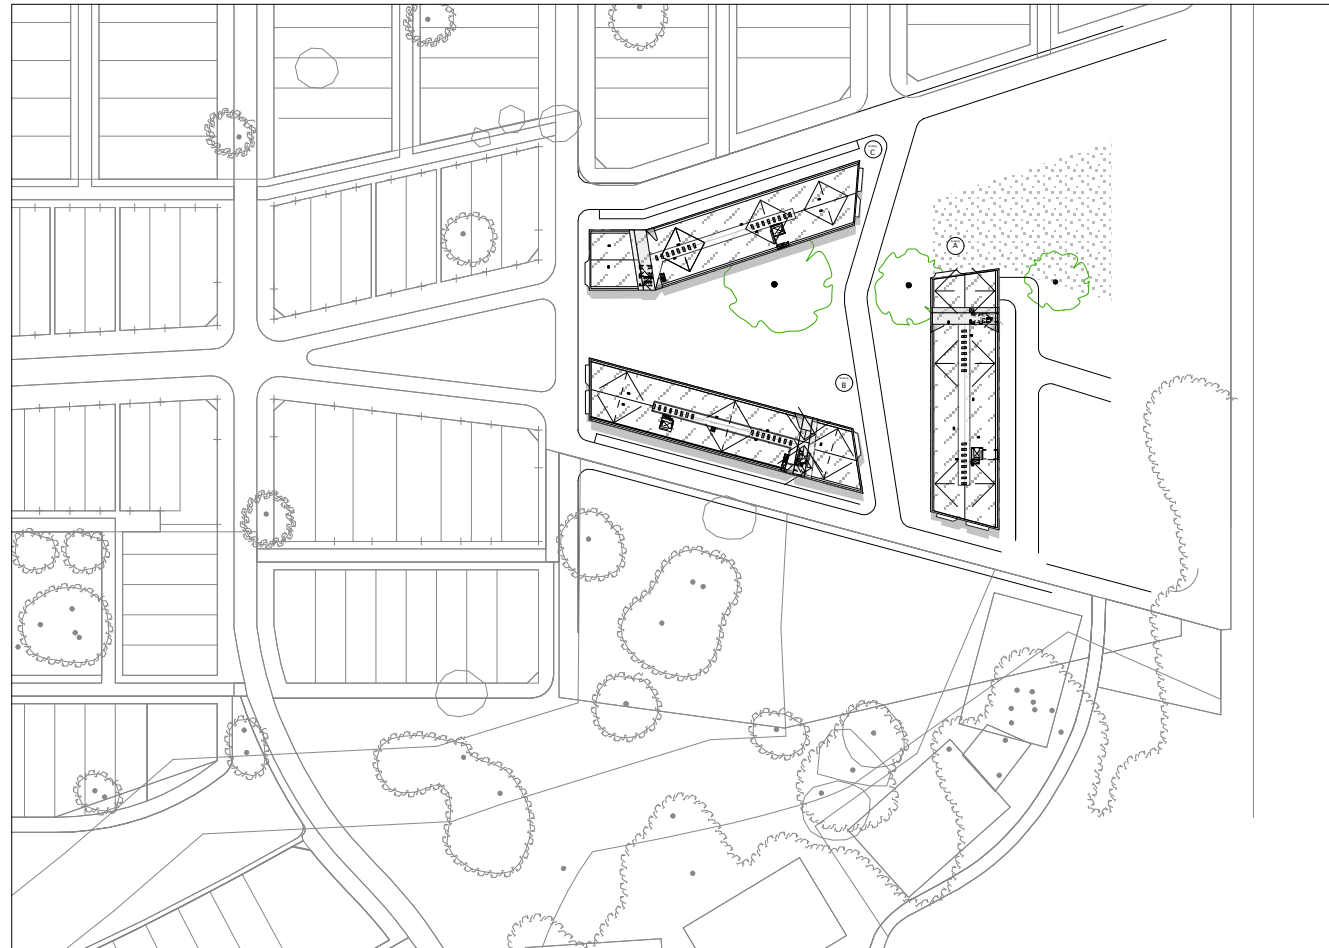

December 23rd, Noon

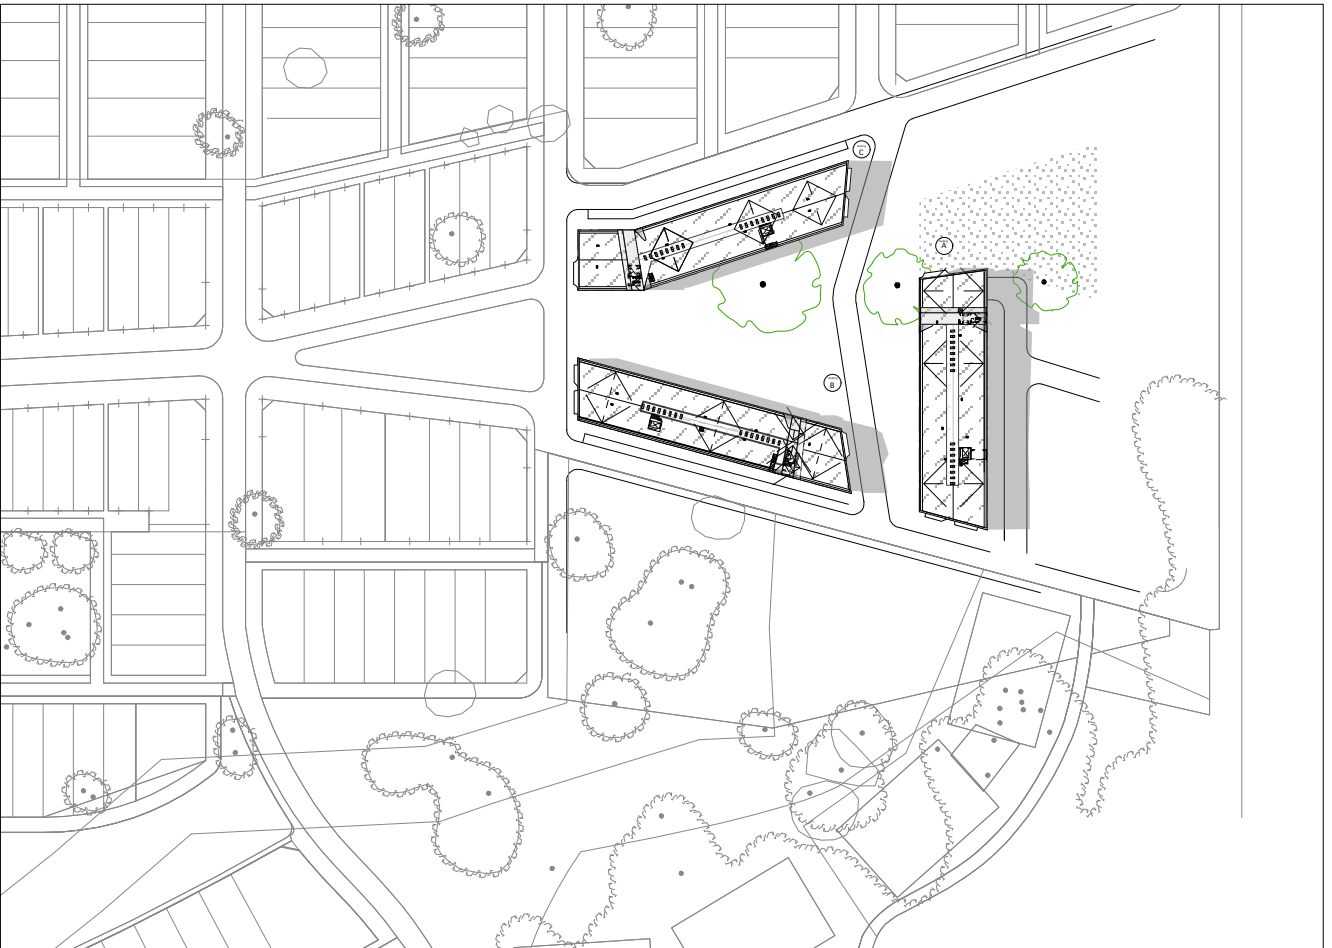

December 23rd, 3pm

DURBACH BLOCK ARCHITECTS

Level 5, 71 York Street
Sydney NSW 2000 Australia
Tel (02) 8297 3500
Fax (02) 8297 3510
mail@durbachblock.com

NOTES:

Builder/Contractor shall verify job dimensions before any job commences.
Figured dimensions take precedence over drawings and job dimensions.
All shop drawings shall be submitted to the Architect/Consultant, and manufacture shall not commence prior to return of inspected shop drawings by the Architect/Consultant.
All wall set-out dimensions (14 series and 50-59 series drawings) are dimensioned to the external faces of the studs.

KEY PLAN

KEY

LDY LAUNDRY

B BALCONY

B1 BEDROOM1

B2 BEDROOM2

B3 BEDROOM3

L/D K

K STO

AC AIR CONDITIONING

CPE CARPARK EXHAUST

REVISIONS:

REV.	DESCRIPTION	DATE
DA2	REVISED DA ISSUE	08.12.08
DA	DA ISSUE	14.6.07
SK3	CLIENT/CONSULTANT ISSUE	1.6.07
SK2	CLIENT/CONSULTANT ISSUE	21.5.07
SK1	CLIENT ISSUE	7.5.07

CONSULTANT TEAM

PLANNING/LANDSCAPE ARCHITECTURE:
EDAW
2-14 Mountain St. Ultimo NSW
2007
Tel (02) 9512 3666 F (02)
9512 4499
ACN 003 886 306
John O'Driscoll - Urban Planning
M 0411 551 512
E john.odriscoll@edaw.com
John Shinkins - Project Principal
M 0411 551 512
E john.shinkins@edaw.com
Chris Yandle - Urban Design /
Landscape
M 0405 707 144
E chris.yandle@edaw.com

ARCHITECTURE - MASTERPLANNING:
dko Architecture
C19 38-48 Macarthur St Ultimo NSW 2007
Contact: Jeff Karakatsis - Architecture - Houses
Tel: (02) 9280 2264
E jeff@dko.com.au
ARCHITECTURE (Residential):
Stanic Harding
123 Commonwealth St Surry Hills NSW 2010
ACN 003 681 301
Contact: Andy Harding - Director
T (02) 9211 6710 F (02) 9211 0366
M 0414 616 666
E andy@stancharding.com.au

ARCHITECTURE (apartments):
Durbach Block Architects
Level 5, 71 York Street
Sydney NSW 2000 Australia
Tel (02) 8297 3500
Fax (02) 8297 3510
mail@durbachblock.com

CIVIL / ACOUSTIC ENGINEERING:
Hyder Consulting
L5, 141 Walker St North Sydney NSW
2060
ABN 76 104 485 289
Contact: John McDermott - Associate
T (02) 8507 9200 F (02) 8507 9301
E john.mcdermott@hyderconsulting.com

ARCHITECTURE (apartments):
Durbach Block Architects
Level 5, 71 York Street
Sydney NSW 2000 Australia
Tel (02) 8297 3500
Fax (02) 8297 3510
mail@durbachblock.com

TRAFFIC & TRANSPORT PLANNING:
GTA Consultants
L10, 815 Pacific Hwy Chatswood NSW
1585
ACN 005 839 645
Contact: Alan Stewart - Project Manager
T (02) 9422 4447 F (02) 9448 1810
M 0422 401 006
E alan.stewart@gtac.com.au

ARCHITECTURE (apartments):
Durbach Block Architects
Level 5, 71 York Street
Sydney NSW 2000 Australia
Tel (02) 8297 3500
Fax (02) 8297 3510
mail@durbachblock.com

ECONOMIC ANALYSIS:
Sphere Property Corporation
Suite 10, Quay West Centre 96 Gloucester
St
Sydney NSW 2000
ABN 56 003 463 401
Contact: John Harrison - Managing Director
T (02) 9552 1006 F (02) 9552 7007
E john.harrison@sphere.com.au

ARCHITECTURE (apartments):
Durbach Block Architects
Level 5, 71 York Street
Sydney NSW 2000 Australia
Tel (02) 8297 3500
Fax (02) 8297 3510
mail@durbachblock.com

BUSHFIRE HAZARD:
Australian Bushfire Protection Planners
RMB 311 Dog Track Rd Somersby NSW
2250
ACN 083 610 173
Contact: Graham Swain - Principal
T (02) 4362 2112 F (02) 4362 2004
E gswain@bgspp.com.au

ARCHITECTURE (apartments):
Durbach Block Architects
Level 5, 71 York Street
Sydney NSW 2000 Australia
Tel (02) 8297 3500
Fax (02) 8297 3510
mail@durbachblock.com

EUROPEAN HERITAGE:
City Plan Heritage

ARCHITECTURE (apartments):
Durbach Block Architects
Level 5, 71 York Street
Sydney NSW 2000 Australia
Tel (02) 8297 3500
Fax (02) 8297 3510
mail@durbachblock.com

ACCESSIBILITY CONSULTANT:
Morris Goding Accessibility Consultants
Unit 106, 56 Bowman St The Coopersage
Pymont NSW 2009
ABN 70 414 330 060
Contact: David Goding
T (02) 9692 9922 F (02) 9692 8433
E david@mgac.com.au

ARCHITECTURE (apartments):
Durbach Block Architects
Level 5, 71 York Street
Sydney NSW 2000 Australia
Tel (02) 8297 3500
Fax (02) 8297 3510
mail@durbachblock.com

INDIGENOUS ARCHAEOLOGY:
NSW Archaeology Pty Ltd

ARCHITECTURE (apartments):
Durbach Block Architects
Level 5, 71 York Street
Sydney NSW 2000 Australia
Tel (02) 8297 3500
Fax (02) 8297 3510
mail@durbachblock.com

CLIENT:

SILVER SPIRIT PARTNERS

ARCHITECT:

D B A
Durbach Block Architects

LEVEL 5
71 YORK STREET
SYDNEY NSW 2000

PROJECT DETAILS:
Moruya East Village
-
Moruya Village Square
-

DRAWING TITLE:

SHADOW DIAGRAMS

DRAWN: SH

CHECKED: CB/ND

SCALE: 1:2000 @ A1

DATE: 08/06/2007

PROJECT NUMBER / SERIES / DRAWING NUMBER:

1603•109

REV:

DA2