


LEGEND

- SITE BOUNDARY
- SETBACK
- EASEMENT

- EXISTING BUILDINGS
- PROPOSED BUILDINGS
- LIFT/ STAIR/ PLANT / ROOF TERRACE ZONE
- ROOF
- LAND ZONING MAP R4 - HIGH DENSITY RESIDENTIAL
- LAND ZONING MAP B1 - NEIGHBOURHOOD CENTRE

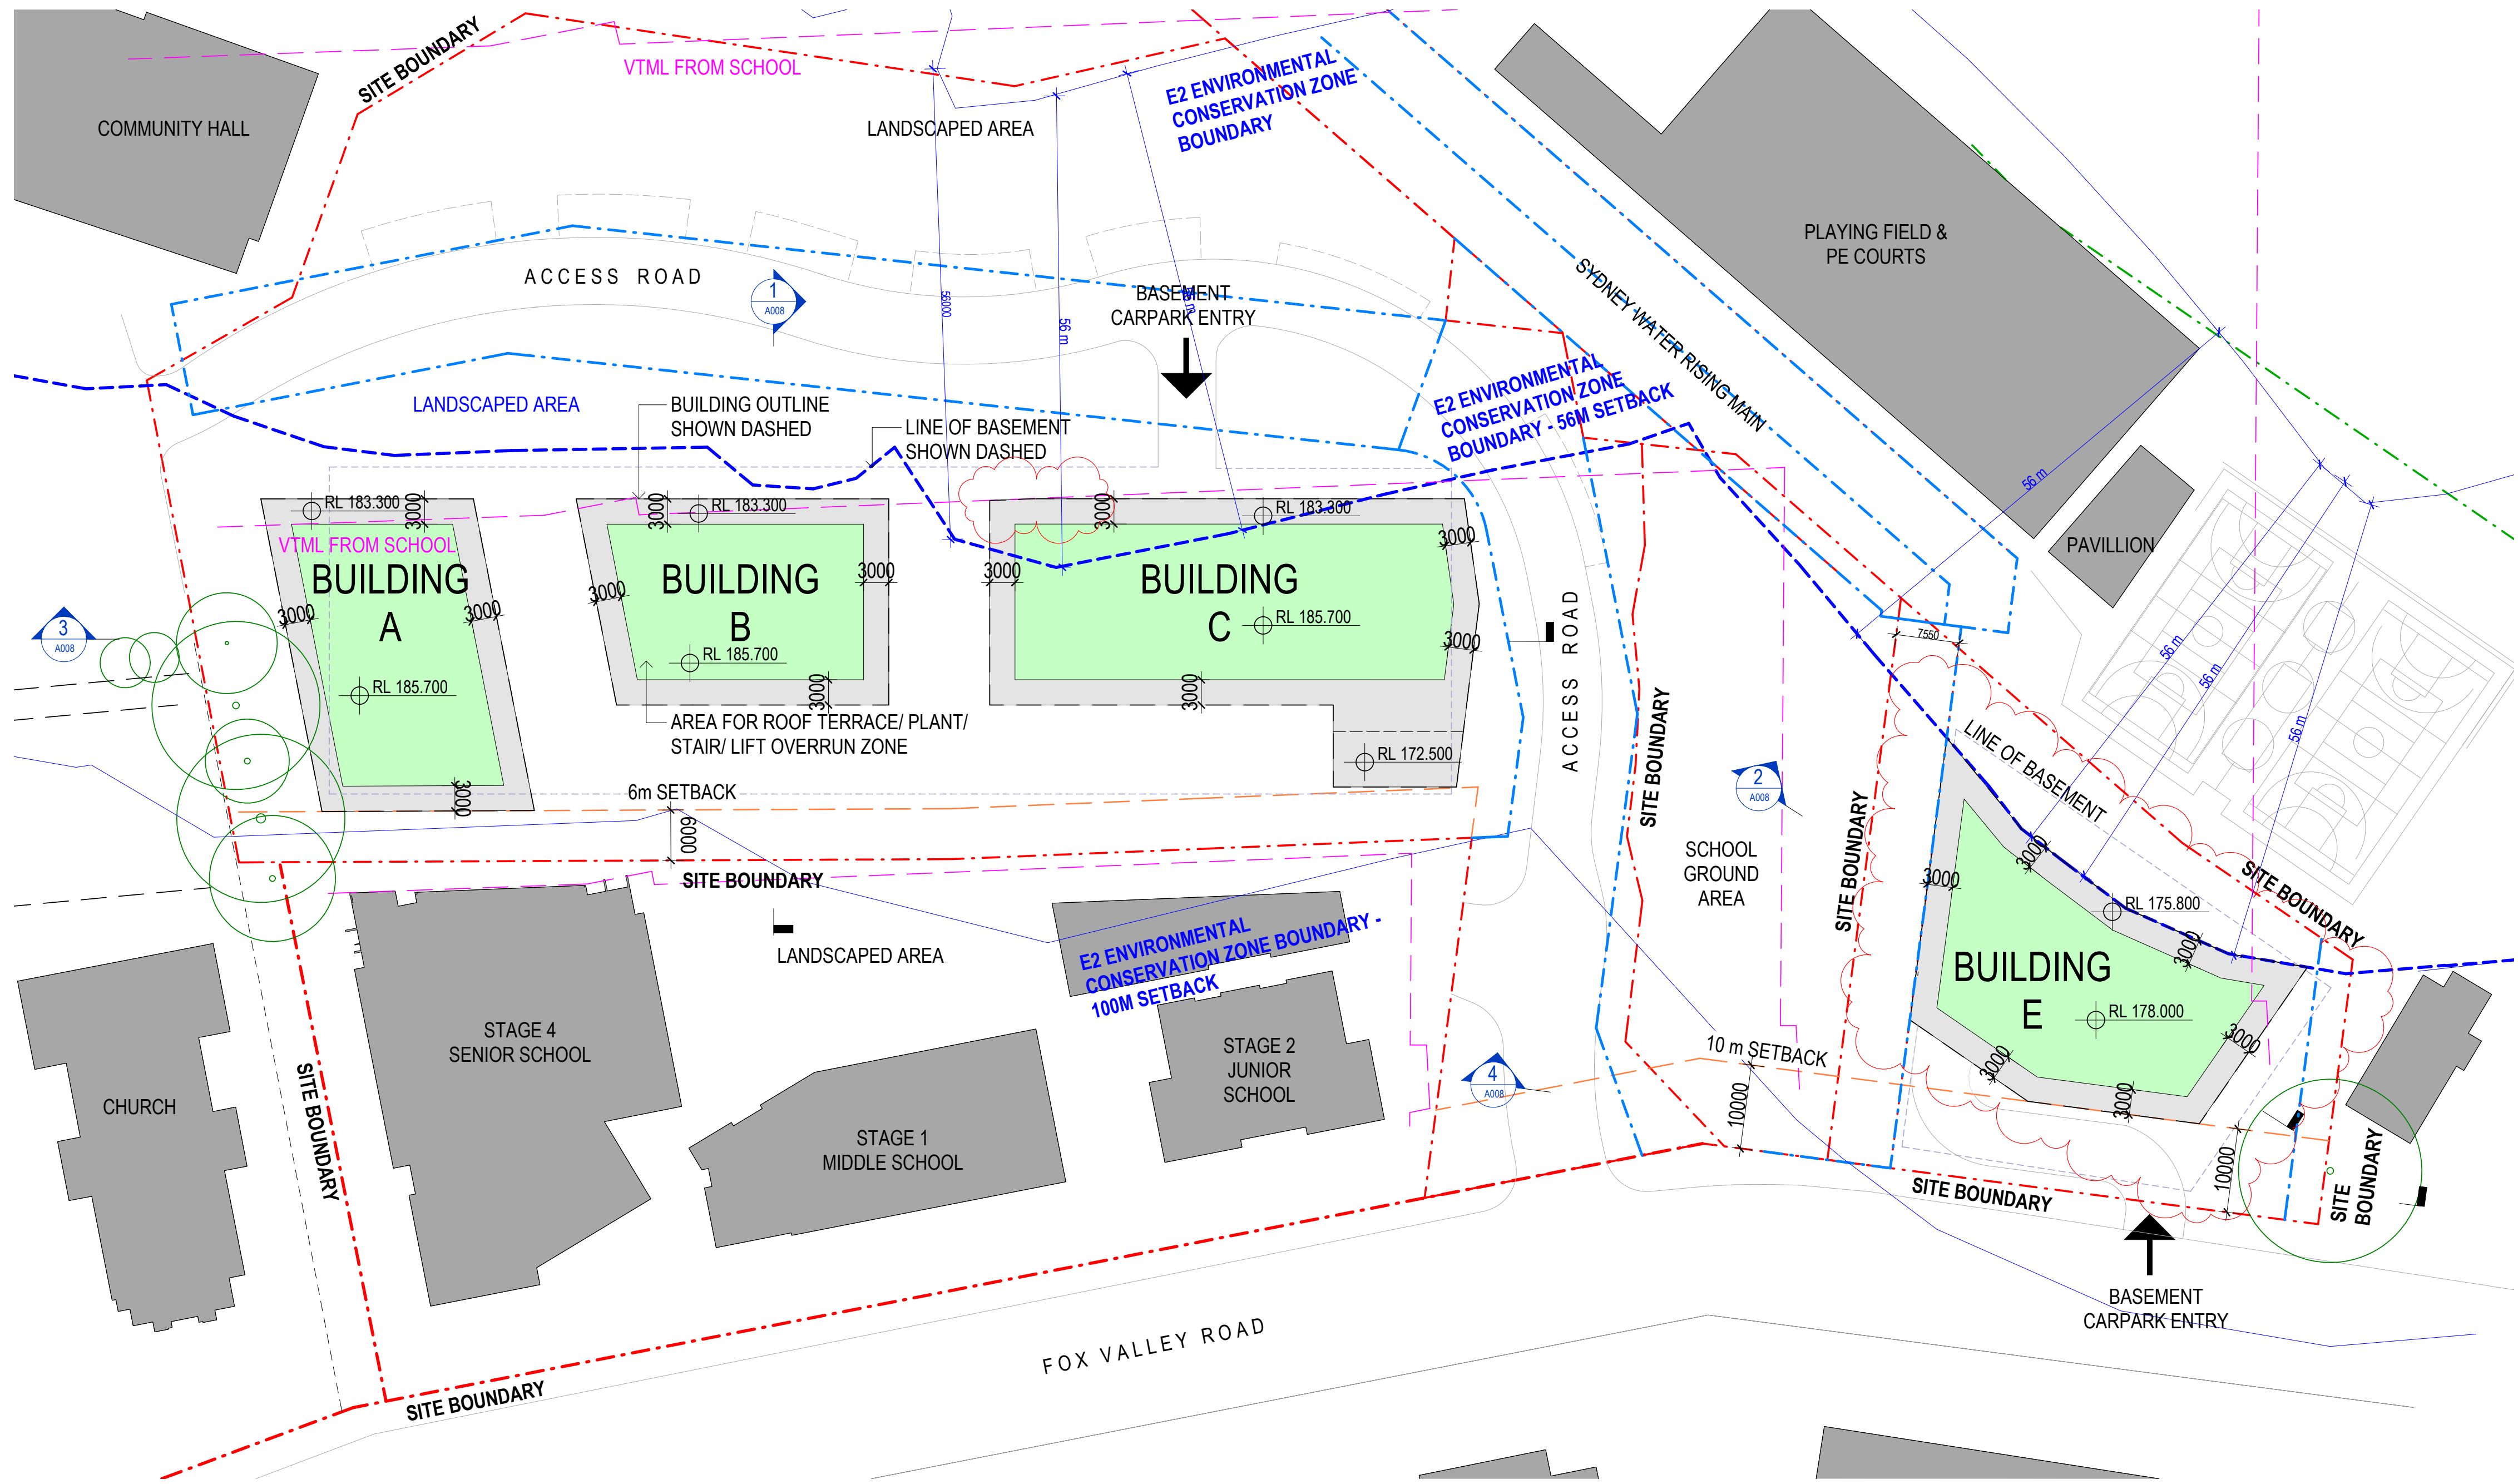

REVISION LIST

- PROPOSED BUILDING D REMOVED
- REVISED SITE BOUNDARY
- INCREASED ANNOTATION SIZE
- BASEMENT RAMP TO BUILDING E MARKED
- MINOR MODIFICATION TO BUILDING ENVELOPE
- PLANT AREA UPDATED

Amendments		
Issue	Description	Date
A	DRAFT S75W ISSUE	12.12.2017
B	S75W ISSUE	14.12.2017
C	REVISED S75W ISSUE	30.01.2018
D	REVISED S75W ISSUE	08.03.2018
E	REVISED S75W ISSUE	21.05.2019
F	FOR INFORMATION	14.07.2020
G	FOR INFORMATION	24.07.2020

Amendments		
Issue	Description	Date

Services

Insync Services
brett@insyncservices.com.au
02 9262 3400
Structure / Civil

TTW
Robertus.Pratikna@ttw.com.au, Stephen.Brain@ttw.com.au
02 9439 7288
Planning

Ethos Urban
moliver@ethosurban.com
02 9956 6962

Client

CAPITAL BLUESTONE
tzu@capitalbluestone.com.au
02 8072 4707

This drawing is the copyright of Group GSA Pty Ltd and may not be altered, reproduced or transmitted in any form or by any means in part or in whole without the written permission of Group GSA Pty Ltd.
All levels and dimensions are to be checked and verified on site prior to the commencement of any work, making of shop drawings or fabrication of components. Do not scale drawings. Use figured Dimensions.

GROUP GSA

Group GSA Pty Ltd ABN 76 002 113 779
Level 7, 80 William St East Sydney NSW
Australia 2011
www.groupgsa.com

T +612 9361 4144 F +612 9332 3458
architecture interior design urban design landscape
nom architect M. Sheldon 9990


Project Title

'THE CANOPY' WAHROONGA

Drawing Title

SECTION 75W - URBAN FORM CONTROL DIAGRAM - ROOF PLAN

FOR INFORMATION				
Plotted and checked by	NM/LL	Verified	-	Approved
Drawing Created (date)		Drawing Created (by)		NM/LL
2018				
Scale	Project No	Drawing No	Issue	
1 : 500 @ A1	15044	A007	G	

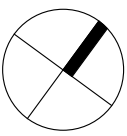

4/09/2020 9:22:48 AM