




Typical Creekline Plan > 1:200 @ A1



V1 > View Upstream in Riparian Creek

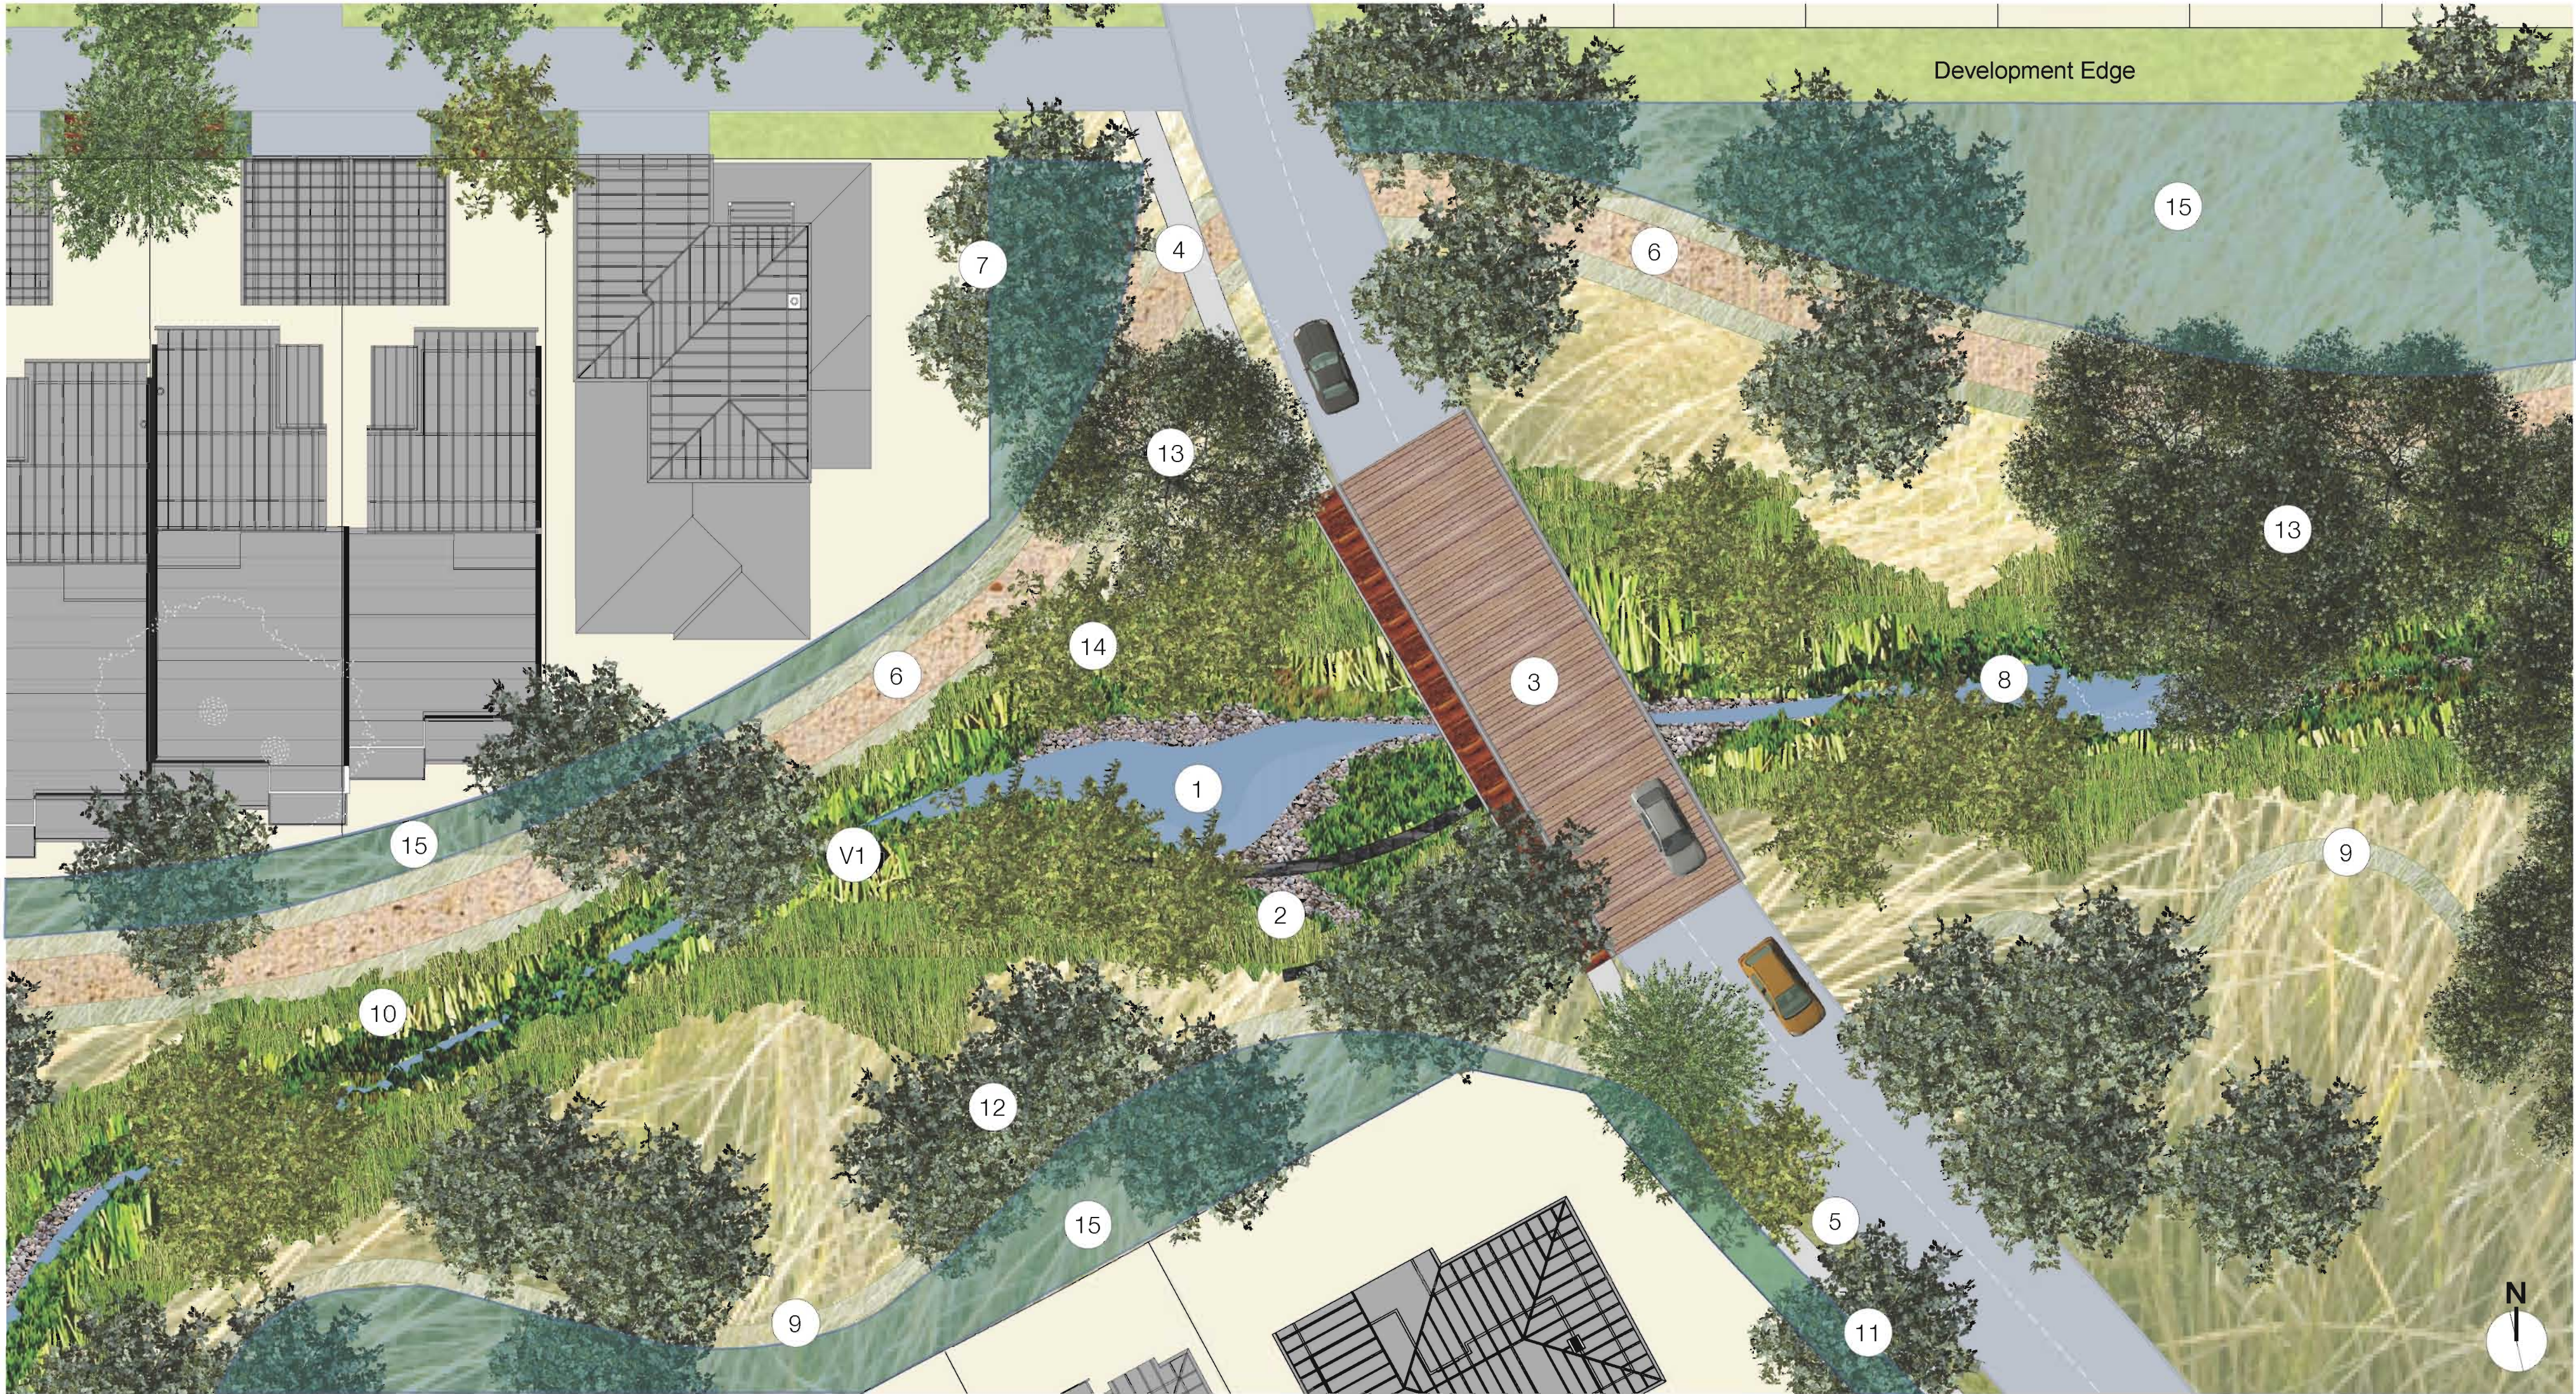

Riparian Corridor Character Images

KEY:

1

Ephemeral pond

2

Sculptural gabion walls / erosion protection to drainage outlet

3

Bridge element to creekline

4

Pedestrian access path to creekline

5

Verge planting - refer Access Rd sections

6

Pedestrian footpath 2m wide with 1m cleared either side for emergency access vehicles

7

Seating area to base of existing and proposed trees

8

Existing creekline to be enhanced and retained

9

Informal gravel "sheep track" path

10

Banded plantings to creekline - refer montage

11

Street trees

12

Copses of Eucalypts - refer Planting Schedule for detail

13

Existing trees to be retained

14

Copses of Melaleucas - refer Planting Schedule for detail

15

Managed Riparian Zone

EDAW

AECOM

NOTES:

Builder / Contractor shall verify job dimensions before any job commences.
Figured dimensions take precedence over drawings and job dimensions.
All shop drawings shall be submitted to the Architect/Consultant, and manufacture shall not commence prior to return of inspected shop drawings by the Architect/Consultant.

KEY PLAN:

REVISIONS:

C	Client Approval	09.12.08
B	Client Approval	08.04.08
A	Client Approval	13.06.07

REV. DESCRIPTION DATE

CONSULTANTS:

URBAN DESIGN / PLANNING:

EDAW
2-14 Mountain St Ultimo NSW 2007
T (02) 9212 3666 F (02) 9212 4499
ACN 003 886 306
Jon Shinkfield - Project Principal
M 0411 551 512
E jon.shinkfield@edaw.com
John O'Driscoll - Urban Planning
M 0411 759 540
E john.odriscoll@edaw.com
Cora Yandell - Urban Design / Landscape Architect
M 0405 707 144
E cora.yandell@edaw.com
Natasha Mavlan - Planning

ARCHITECTURE + MASTERPLANNING:

dko Architecture
C18 35-45 Macquarie St Ultimo NSW 2007
ABN 54 740 188 257
Contact: Jeff Kesteven (architecture - houses)
E jeff@dko.com.au
E jeff@dko.com.au

ARCHITECTURE (wellness centre):

Steno Harding
123 Commonwealth St Surry Hills NSW 2010
ACN 003 631 301
Contact: Andy Harding - Director
T (02) 9211 5710 F (02) 9211 5366
M 0414 416 686
E andy@steno-harding.com.au

CIVIL / ACOUSTIC ENGINEERING:

Hyder Consulting
L6 141 Walker St North Sydney NSW 2060
ABN 76 104 485 289
Contact: John McDermott - Associate
T (02) 9807 9000 F (02) 9807 9001
M 0408 031 971
E john.mcdermott@hyderconsulting.com

ARCHITECTURE (apartments):

Durbach Brock
Level 7 71 York Street Sydney NSW 2000
ABN
Contact: Neil Durbach
T (02) 9297 3500 F (02) 9297 3510
M 0414 472 310
E neil@durbachbrock.com

TRAFFIC & TRANSPORT PLANNING:

CTA Consultants
L10 815 Pacific Hwy Chatswood NSW 2057
ACN 006 633 646
Contact: Alan Stewart - Project Manager
T (02) 9448 1800 F (02) 9448 1810
M 0422 401 006
E alan.stewart@cta.com.au

BASIC:

Damen CT/Opie Town Planning
L2 29 Shepherd St Chippendale NSW 2008
ABN
Contact: Damien O'Keefe
T (02) 9200 4541 F (02) 9200 4577
M 0413 031 971
E damien@overplanning.net.au

ECONOMIC ANALYSIS:

Sphere Property Corporation
Suite 10 Quay West Centre
96 Gloucester St Sydney NSW 2000
ABN 34 003 463 461
Contact: John Jackson - Managing Director
T (02) 9252 7066 F (02) 9252 7067
M 0418 293 025
E sphere@sphere.com.au

FLOOD MANAGEMENT / WSUD:

Evans & Peck
20/306 Eastern Valley Way East Roseville NSW 2059
ACN 008 008 815
Contact: Steve Peters - Principal
T (02) 9882 0500 F (02) 9417 8850
M 0413 244 400
E speters@evanspeck.com

BUSHFIRE HAZARD:

Australian Bushfire Protection Planners
RMB 311 Dog Track Rd Somersby NSW 2250
ACN 083 510 173
Contact: Graham Smith - Principal
T (02) 4362 2112 F (02) 4362 2204
M 0427 422 204
E gsmith@bgsppd.net.au

SOILS CAPABILITY:

Sydney Environmental & Soil Laboratory
16 Chivers Rd Pennant Hills NSW 2120
PO Box 207 Pennant Hills NSW 2115
ACN 106 810 708
Contact: Simon Seel - Principal
T (02) 9680 6554 F (02) 9484 2427
M 0403 128 729
E simon@seel.com.au

EUROPEAN HERITAGE:

City Plan Heritage

ECOLOGY:

Keystone Ecological
PO Box 9096 Singsie Bay NSW 2257
ACN 099 456 149
Contact: Elizabeth Jubb - Senior Ecologist
T (02) 4368 1108 F (02) 4368 2361
E e.jubb@keystone-ecological.com.au

ACCESSIBILITY CONSULTANTS:

Mavis Coding Accessibility Consultants
Unit 105 55 Bowman St The Coopers
Pyrmont NSW 2009
Contact: David Sengco
T (02) 9692 9322 F (02) 9692 8433
E david@mgac.com.au

INDIGENOUS ARCHAEOLOGY:

NSW Archaeology Pty Ltd

CLIENT:

SILVER SPIRIT PARTNERS

ARCHITECT:

SYDNEY BRISBANE
MELBOURNE
SUNSHINE COAST

EDAW

AECOM

2-14 MOUNTAIN STREET ULTIMO NSW 2007
T 02 9212 3666 F 02 9212 4499 E SYDNEY@EDAW.COM

PROJECT DETAILS:

Moruya East Village

DRAWING TITLE:

Riparian Corridor
Detail Plan and Perspectives

DRAWN: CY/DG

CHECKED:

SCALE: 1:200 @ A1

DATE: 23/03/2007

PROJECT NUMBER:

DRAWING NUMBER:

REV:

06502307

SK03

C