


KEY PLAN

THE PROPERTY IN THIS DRAWING AND IN THE CONCEPTS REMAIN WITH MNIA ARCHITECTS PTY LTD. ANY UNAUTHORISED USE OF THIS DRAWING WHETHER AS THE WHOLE OR PART MAY RENDER THE USER LIABLE IN AN ACTION FOR DAMAGES. CONSEQUENTIAL DAMAGES ARISING FROM UNWARRANTED OR UNAUTHORISED USE SHALL NOT RENDER MNIA ARCHITECTS PTY LTD LIABLE.

DIMENSIONS MUST NOT BE SCALED FROM DRAWINGS.

ALL DIMENSIONS TO BE CONFIRMED ON SITE PRIOR TO THE COMMENCEMENT OF ANY WORK.

NOTE:  
EXISTING SITE BASED ON ADW JOHNSON  
DRAWING SK 009/G, DATED 11-02-10

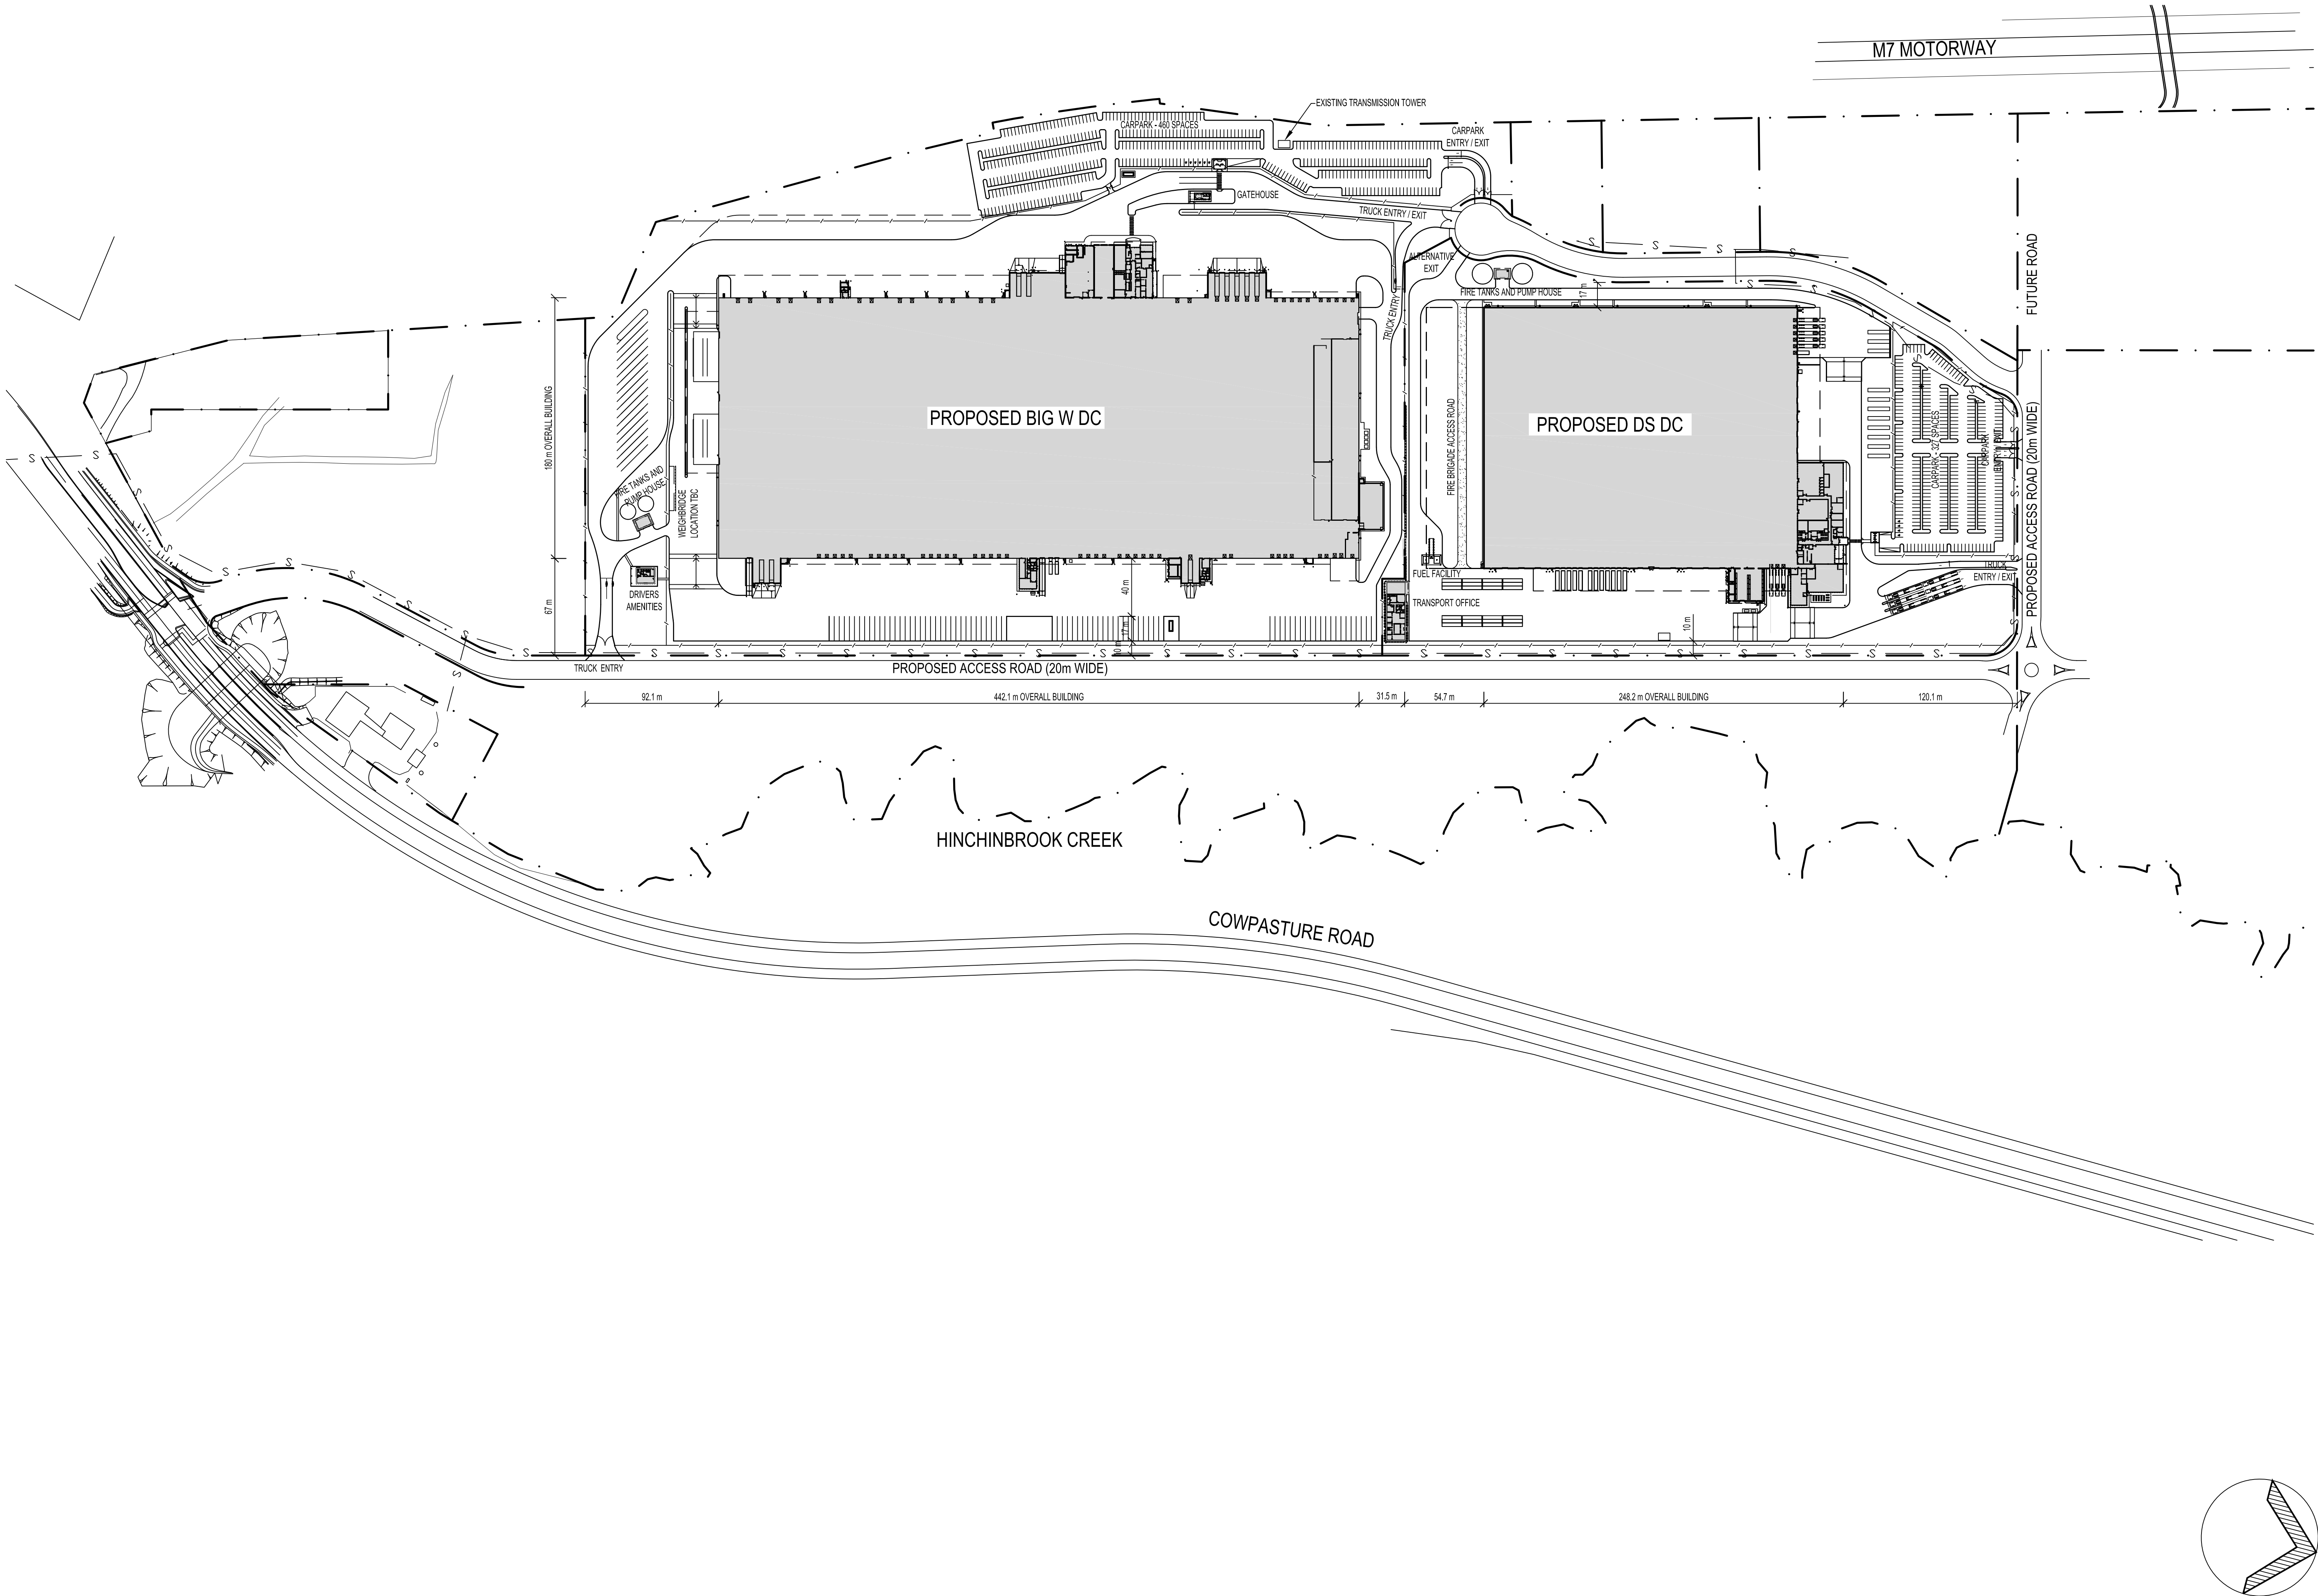

|      |          |   |        |
|------|----------|---|--------|
| D    | 15.02.10 | BIG W TRUCK ENTRY, TRUCK ENTRY/EXIT, ROAD NEAR    | FZ     |
|      |          | GATEHOUSE & FIRE PUMP HOUSE ALTERED, FIRE         |        |
|      |          | PUMP HOUSE REPOSITIONED, DS TRUCK ENTRY/EXIT      |        |
|      |          | & ROUNDABOUT ALTERED, BASED ON ADW JOHNSON        |        |
|      |          | DRAWING SK 009/G, DATED 11-02-10                  |        |
| C    | 05.02.10 | SITE ALTERED BASED ON ADW JOHNSON DRAWING         | FZ     |
|      |          | SK 009/E, DATED 04-02-10                          |        |
| B    | 18.01.10 | DRIVERS AMENITIES & FIRE PUMP HOUSE RELOCATED, FZ |        |
|      |          | WATER TANKS DELETED, DS FUEL FACILITY ADDED       |        |
| A    | 10.12.09 | NEW DRAWING, BASED ON DWG ARS01/8                 | SRC    |
| REV. | DATE     | AMENDMENT   | SIGNED |

CLIENT

Mirvac Projects Pty. Ltd  
ABN 72 001 089 245

Level 26, 80 Margaret St.  
Sydney, NSW, 2000  
tel. 02 9080 8000  
fax. 02 9080 8181

PROJECT

**BIG W**  
**DISTRIBUTION CENTRE**  
**HOXTON PARK NSW**

ARCHITECT

Level 4, 8 Help Street  
PO Box 1212  
Chatswood NSW 2067

Telephone (02) 9495 6400  
Facsimile (02) 9495 6444  
mail@mnia.com.au

STRUCTURAL & CIVIL ENGINEERS

**COSTIN ROE CONSULTING PTY LTD**  
Suite 310, 55 Harrington St, The Rocks Sydney NSW 1220  
Tel: (02) 9251 7699 Fax: (02) 9241 3731

ELECTRICAL & MECHANICAL ENGINEERS

**SHELMERDINES**  
55 Hume St Crows Nest NSW 2065  
Tel: (02) 9436 3021 Fax: (02) 9439 8709

FIRE ENGINEERS

**AECOM**  
Level 11, 44 Market St Sydney NSW 2000  
Tel: (02) 8295 7555 Fax: (02) 8295 7500

HYDRAULIC ENGINEERS

**NIVEN DONNELLY & PARTNERS PTY LTD**  
Suite 1, 769 Pacific Highway, Chatswood NSW 2067  
Tel: (02) 9884 8911 Fax: (02) 9884 8977

TITLE

**CONCEPT SITE PLANS**  
**BIG W AND DICK SMITH**

|          |             |             |       |         |       |
|----------|-------------|-------------|-------|---------|-------|
| DATE     | 10-12-09    | PROJECT No. | 0930  | STATUS  | AR/DA |
| SCALE    | 1:2000 (B1) |             |       |         |       |
| DRAWN    | SRC         |             |       |         |       |
| CHECKED  |             | DWG No.     |       | REV No. |       |
| APPROVED |             |             | DA 01 | /D      |       |