
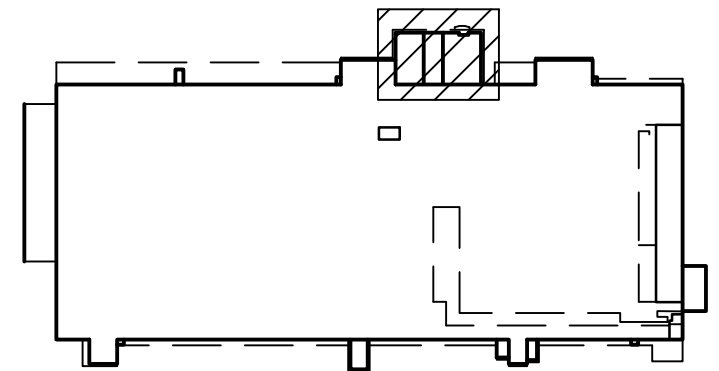


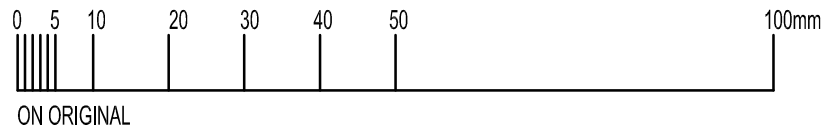

KEY PLAN

THE PROPERTY IN THIS DRAWING AND IN THE CONCEPTS REMAIN WITH MNIA ARCHITECTS PTY LTD. ANY UNAUTHORISED USE OF THIS DRAWING WHETHER AS THE WHOLE OR PART MAY RENDER THE USER LIABLE IN AN ACTION FOR DAMAGES. CONSEQUENTIAL DAMAGES ARISING FROM UNWARRANTED OR UNAUTHORISED USE SHALL NOT RENDER MNIA ARCHITECTS PTY LTD LIABLE.

DIMENSIONS MUST NOT BE SCALED FROM DRAWINGS.


ALL DIMENSIONS TO BE CONFIRMED ON SITE PRIOR TO THE COMMENCEMENT OF ANY WORK.

LEGEND

- FHR FIRE HYDRANT
- EDB / MCB FIRE HOSE REEL
- RDF DISTRIBUTION BOARDS
- WS REFRIGERATED DRINKING FOUNTAIN
- FD WORK STATION
- COMMS FLOOR DISTRIBUTOR

REV	DATE	AMENDMENT	SIGNED
B	05.02.10	TITLE BLOCK ALTERED	FZ
A	18.01.10	NEW DRAWING, PROMOTED FROM 0930 ARD0280A	FZ

CLIENT
Mirvac Projects Pty Ltd
AS/NZS 2201:089 245
Level 26, 80 Margaret St.
Sydney, NSW 2000
tel. 02 9080 8000
fax. 02 9080 8181

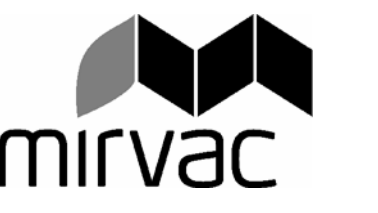

PROJECT
BIG W DISTRIBUTION CENTRE
HOXTON PARK NSW

ARCHITECT
MNIA ARCHITECTS
Level 4, 8 Help Street
PO Box 1212
Chatswood NSW 2067
Telephone (02) 9495 6400
Facsimile (02) 9495 6444
mail@mnia.com.au

STRUCTURAL & CIVIL ENGINEERS
COSTIN ROE CONSULTING PTY LTD
Suite 310, 55 Harrington St, The Rocks Sydney NSW 1220
Tel: (02) 9251 7699 Fax: (02) 9241 3731

ELECTRICAL & MECHANICAL ENGINEERS
SHELMERDINES
55 Hume St, Crows Nest NSW 2065
Tel: (02) 9436 3021 Fax: (02) 9439 8709


FIRE ENGINEERS
AECOM
Level 11, 44 Market St Sydney NSW 2000
Tel: (02) 6295 7535 Fax: (02) 6295 7500

HYDRAULIC ENGINEERS
NIVEN DONNELLY & PARTNERS PTY LTD
Suite 1, 769 Pacific Highway, Chatswood NSW 2067
Tel: (02) 9884 8911 Fax: (02) 9884 8977

TITLE

MAIN OFFICE AREA
FLOOR PLAN LEVEL 1

DATE	25-11-09	PROJECT No.	0930	STATUS	AR/DA
SCALE	1:100	(B1)			
DRAWN	SRC				
CHECKED		DWG No.		REV No.	
APPROVED			DA 13	/B	

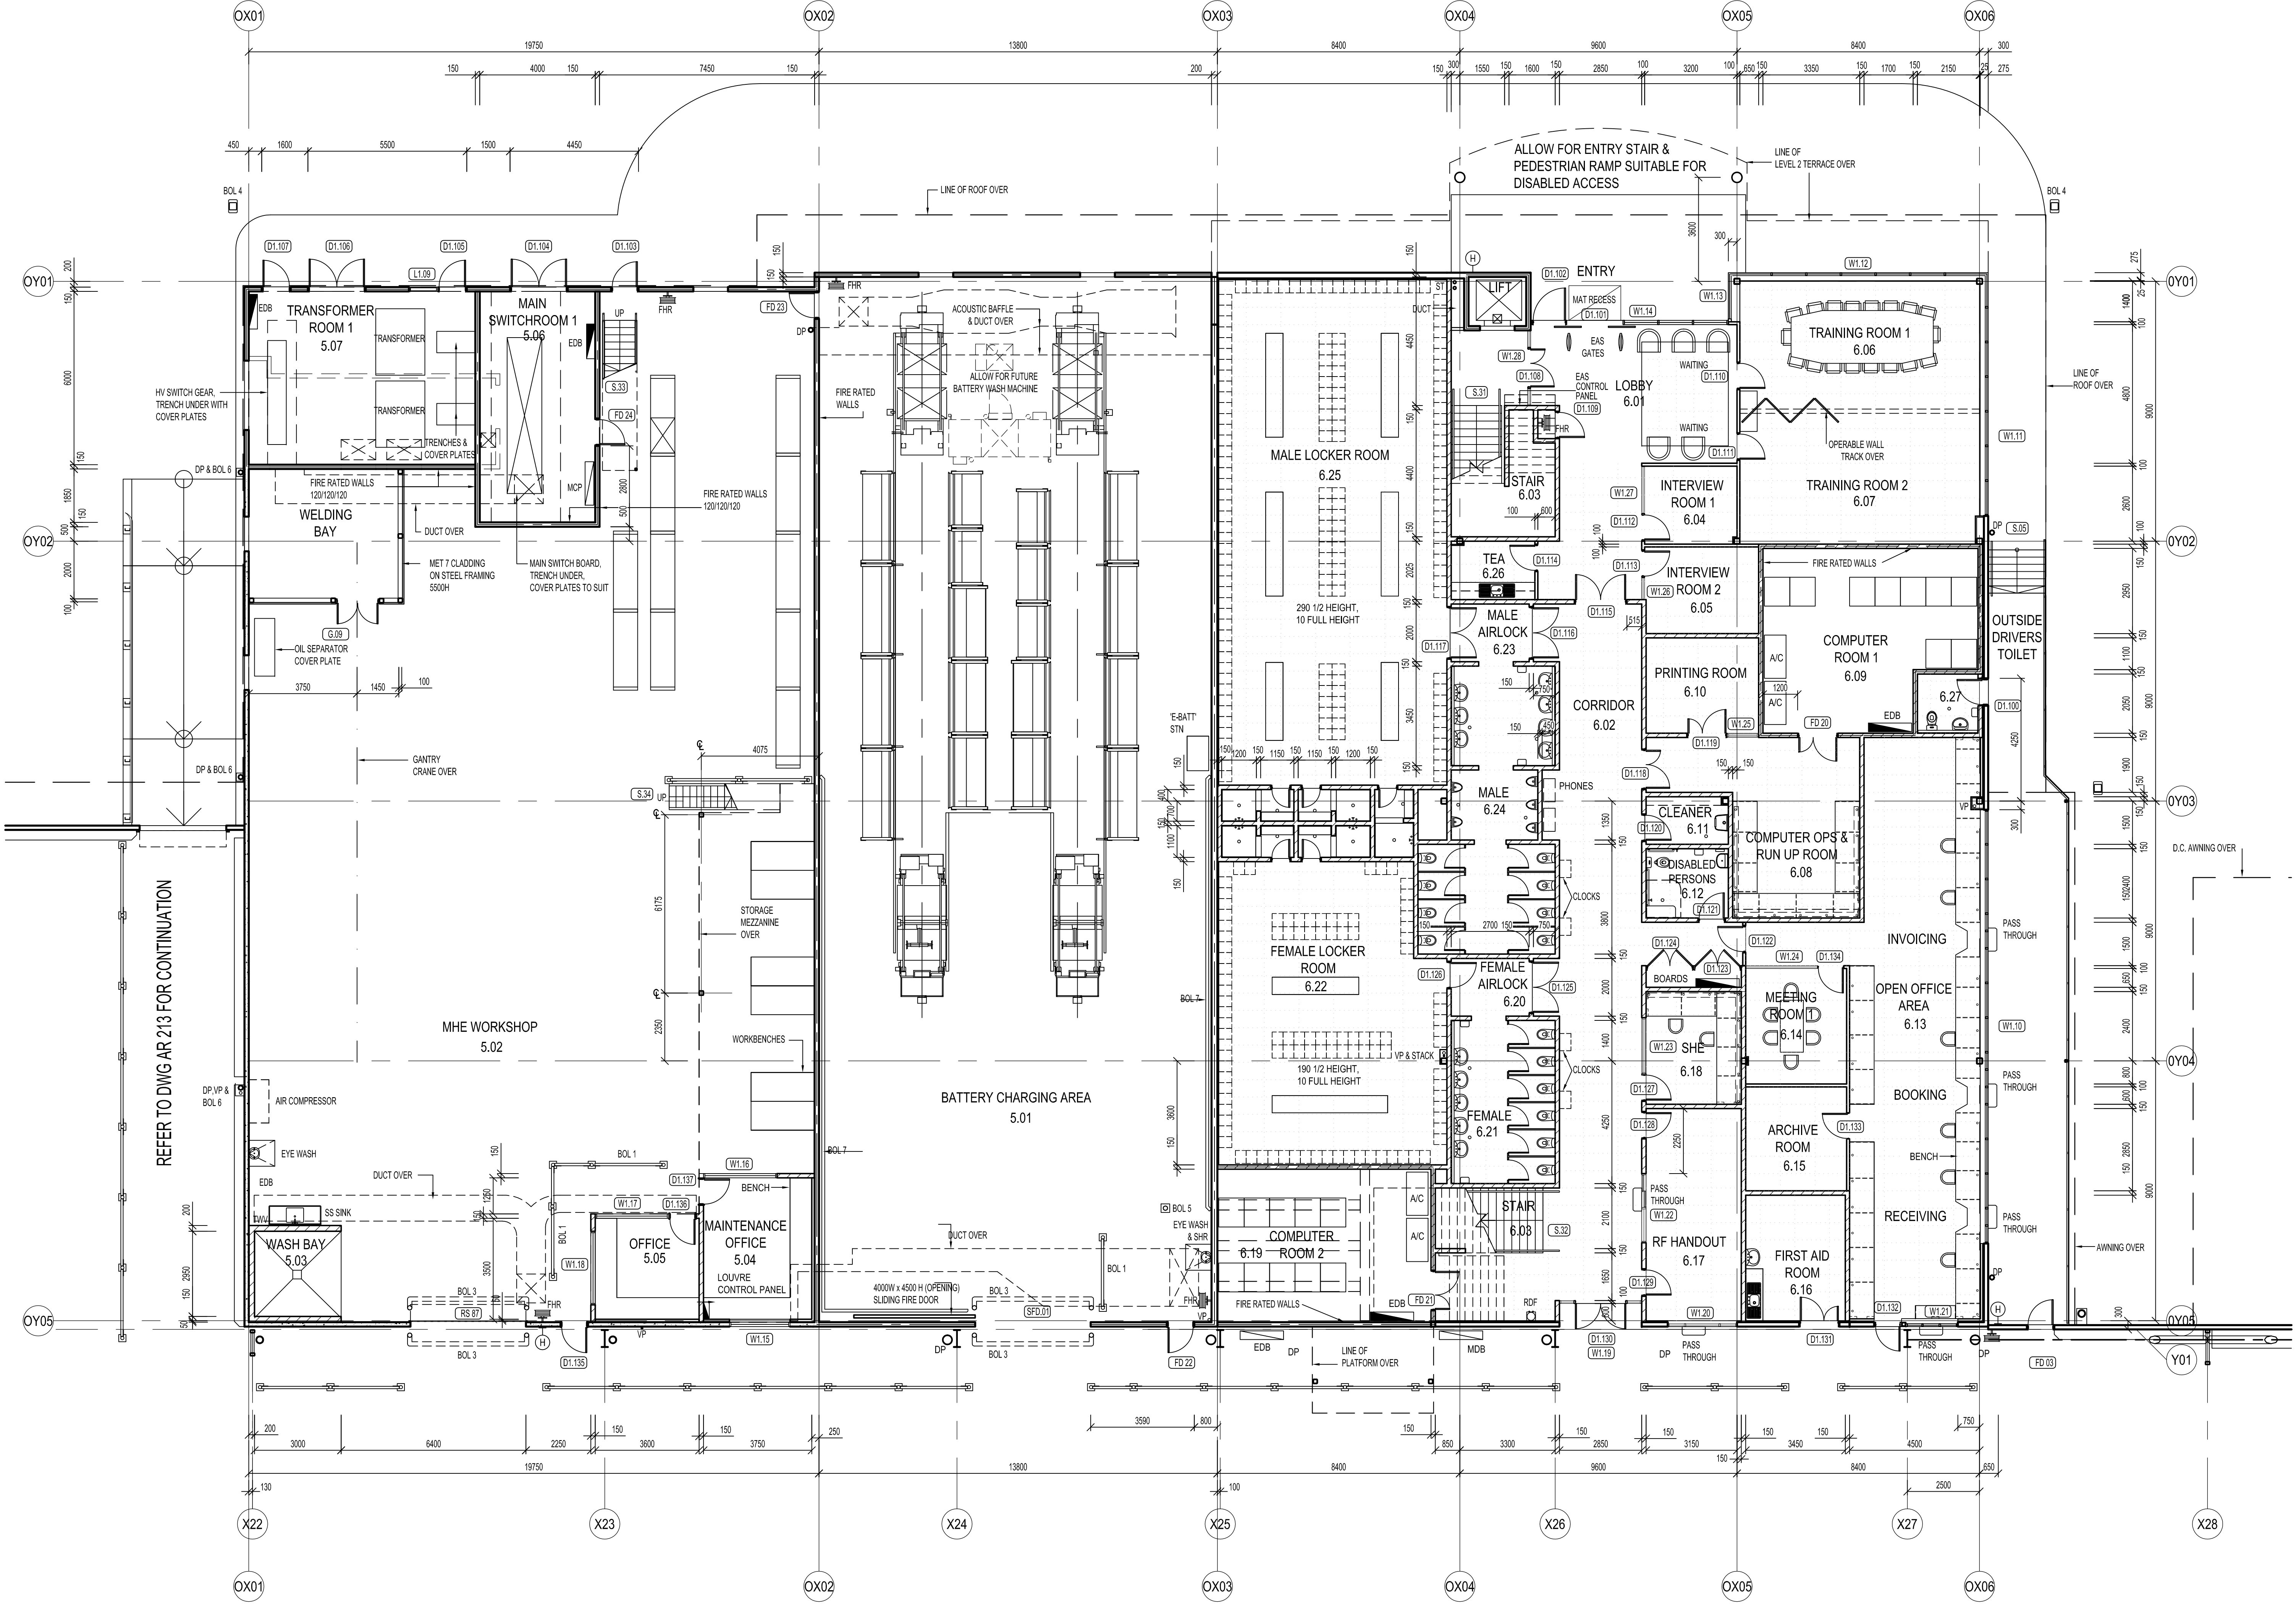

01 OFFICE AREA FLOOR PLAN LEVEL 1