




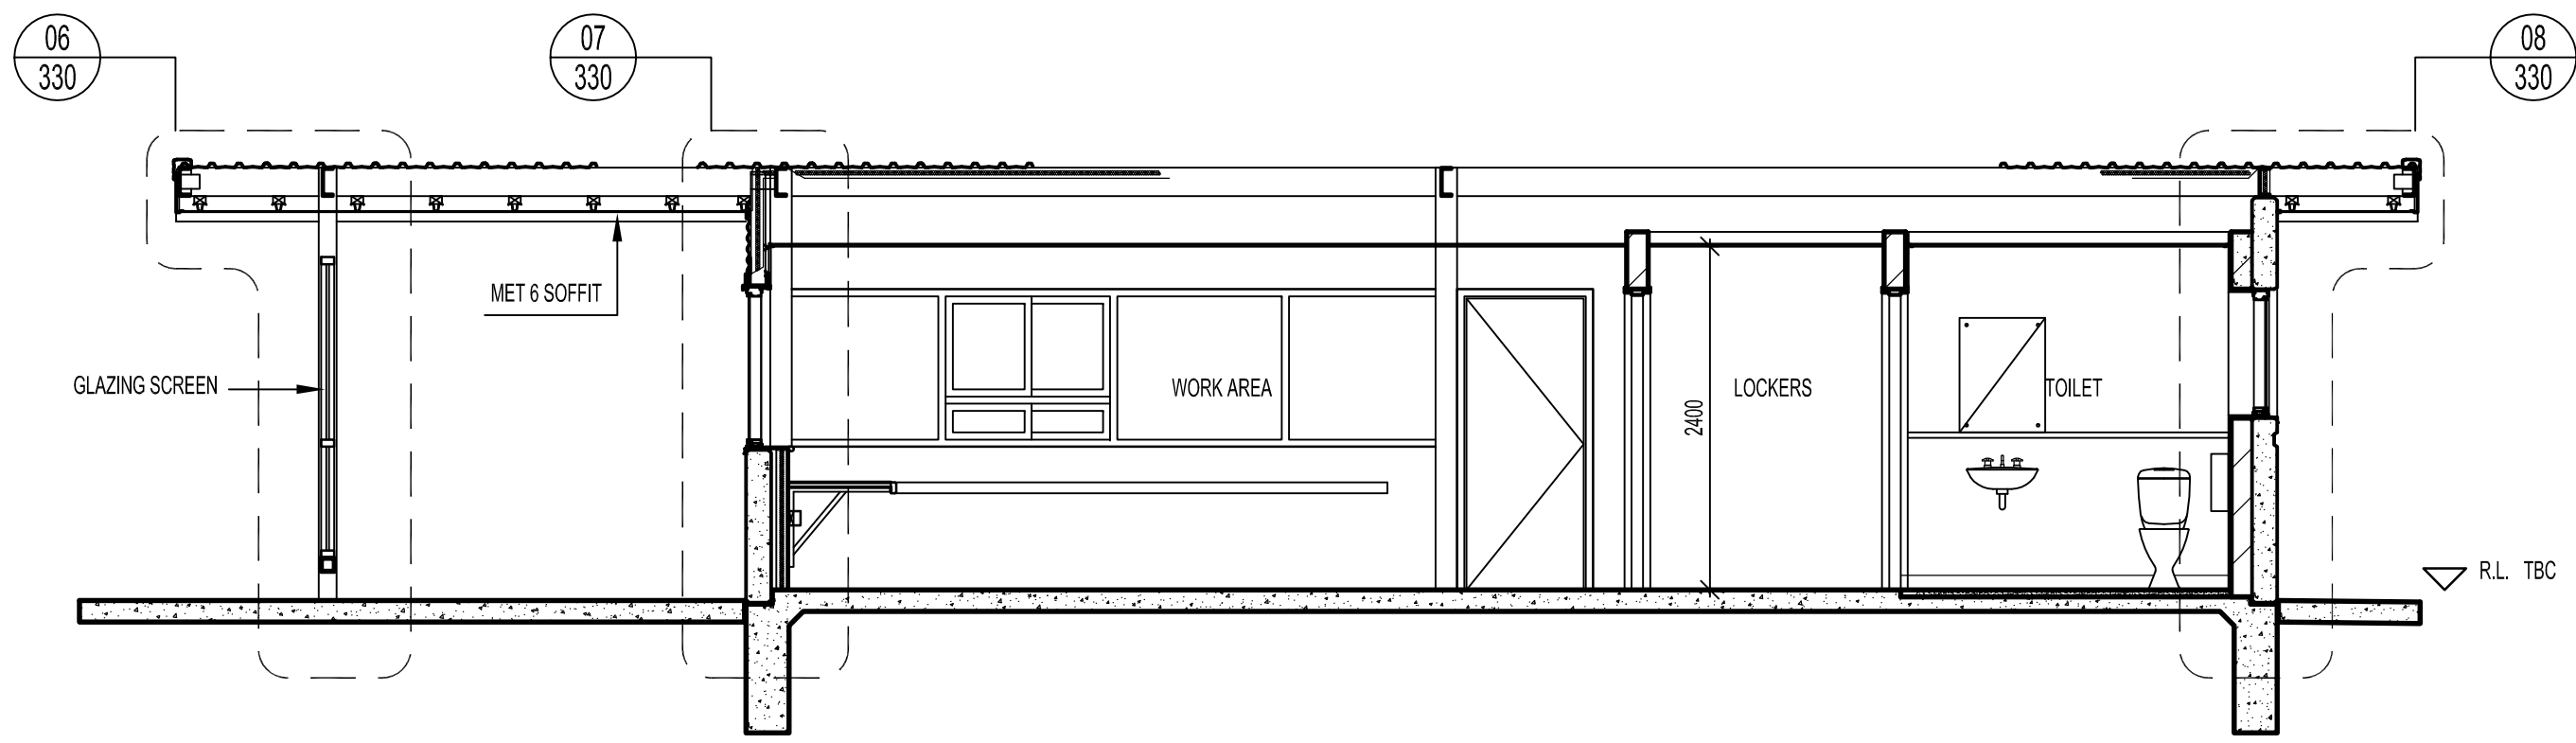


04 SECTION
1:50

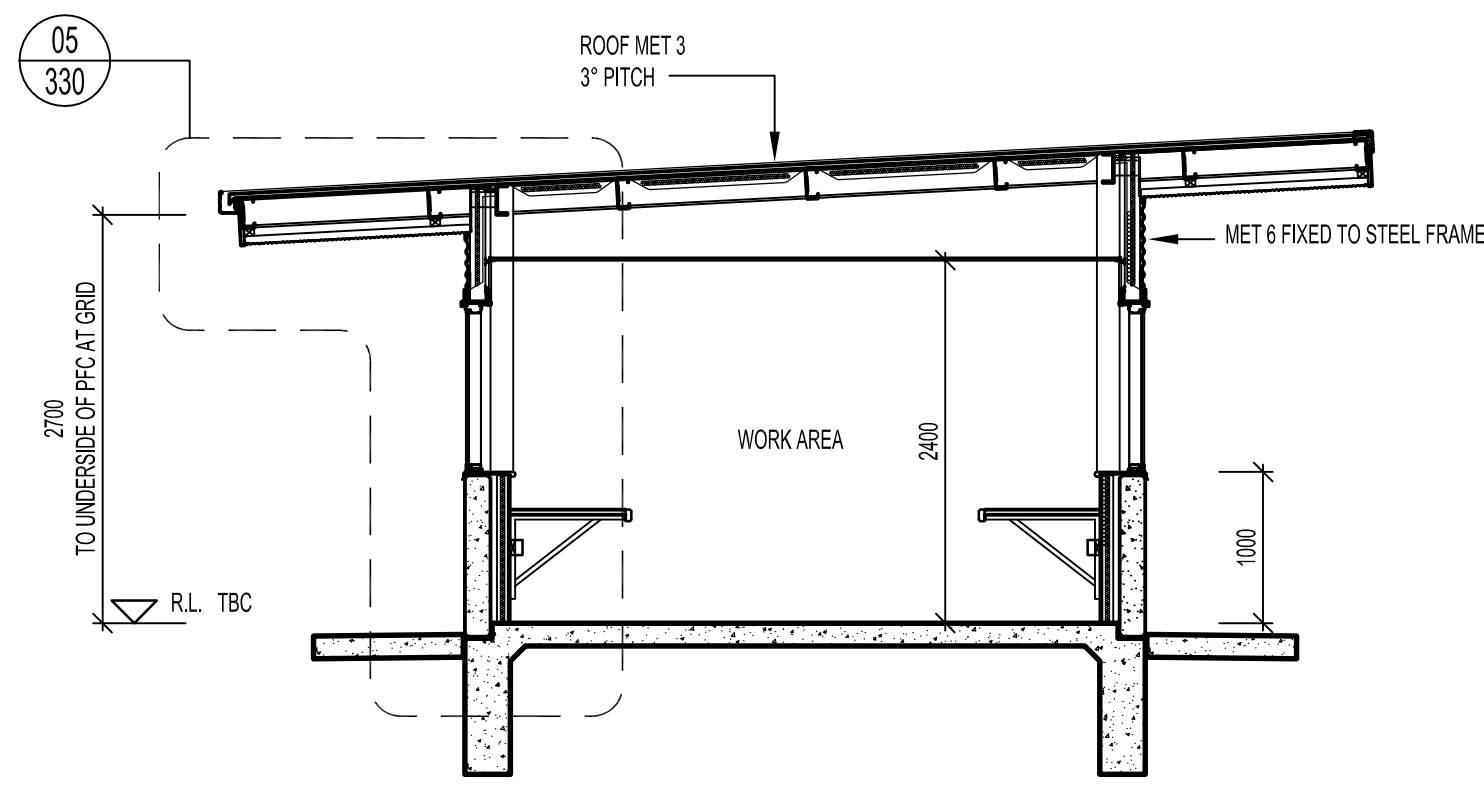


05 SECTION
1:50

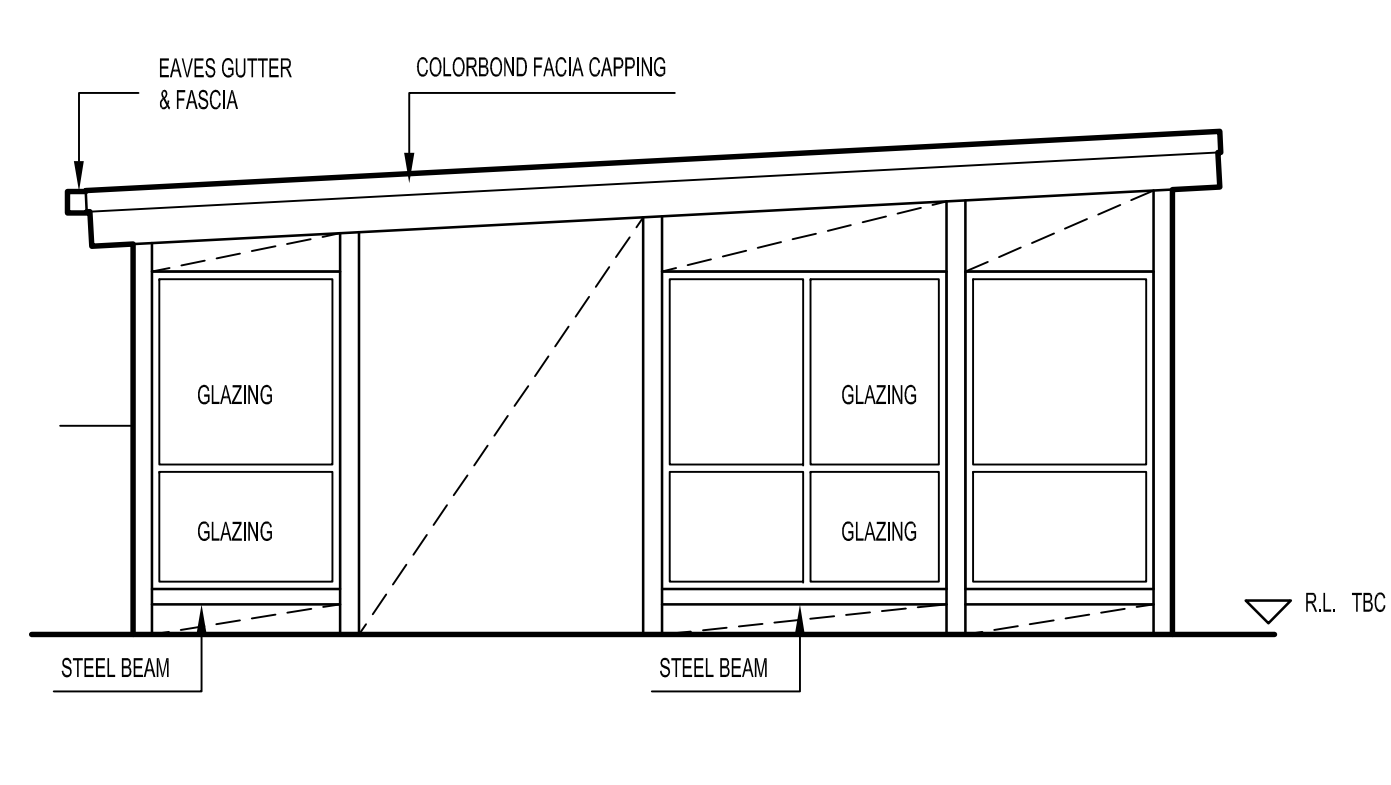


06 SCREEN ELEVATION
1:50

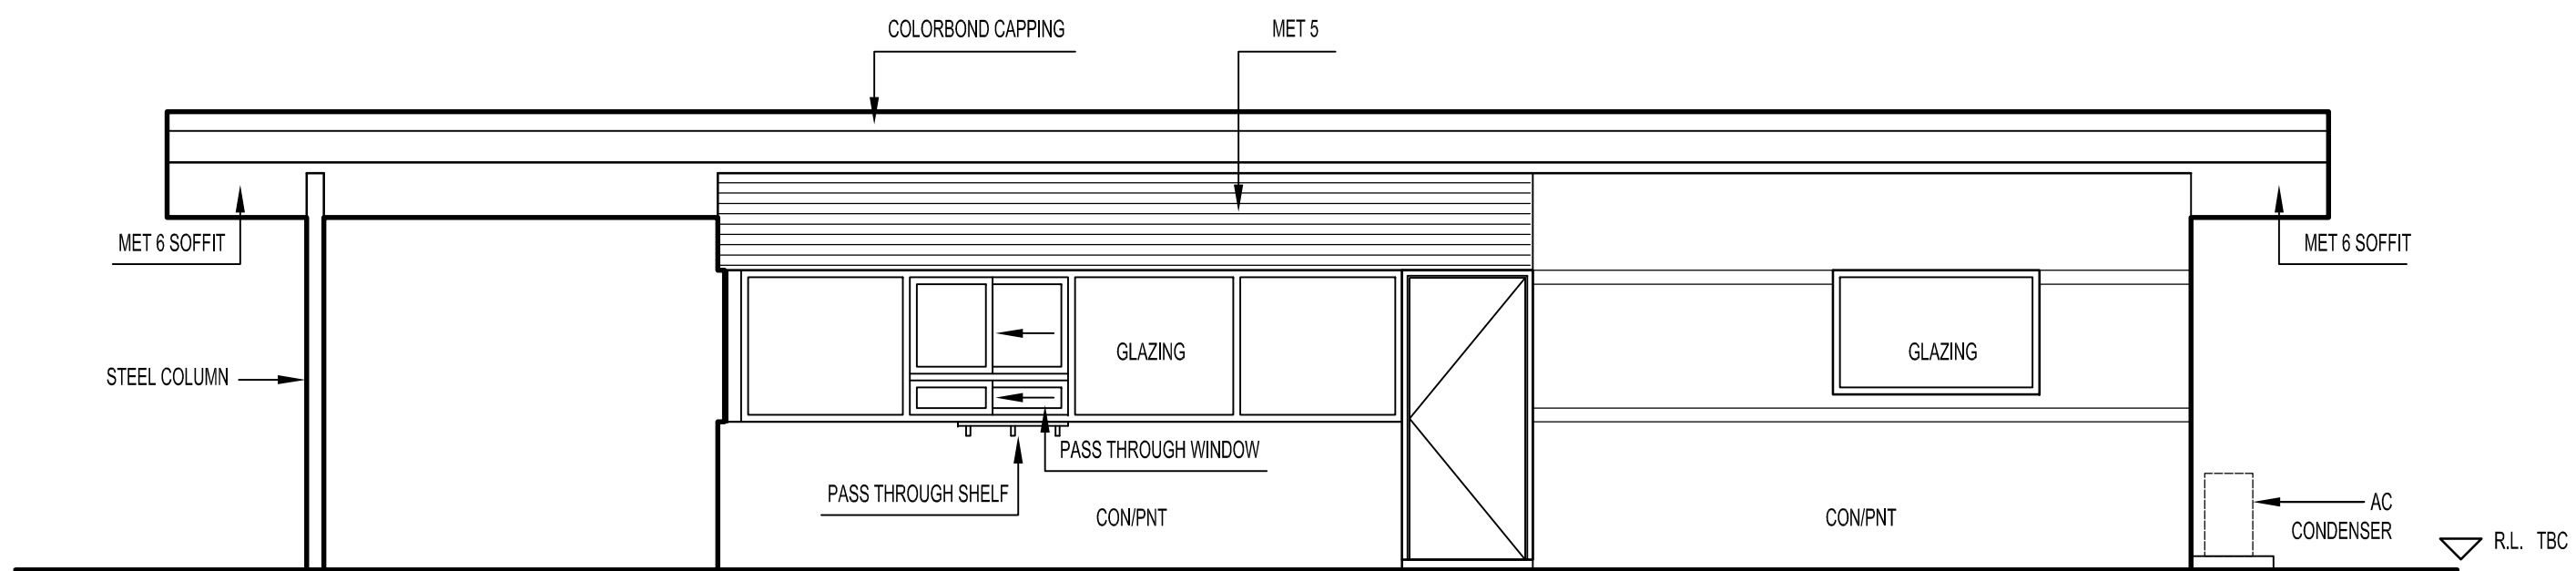


07 EAST ELEVATION
1:50

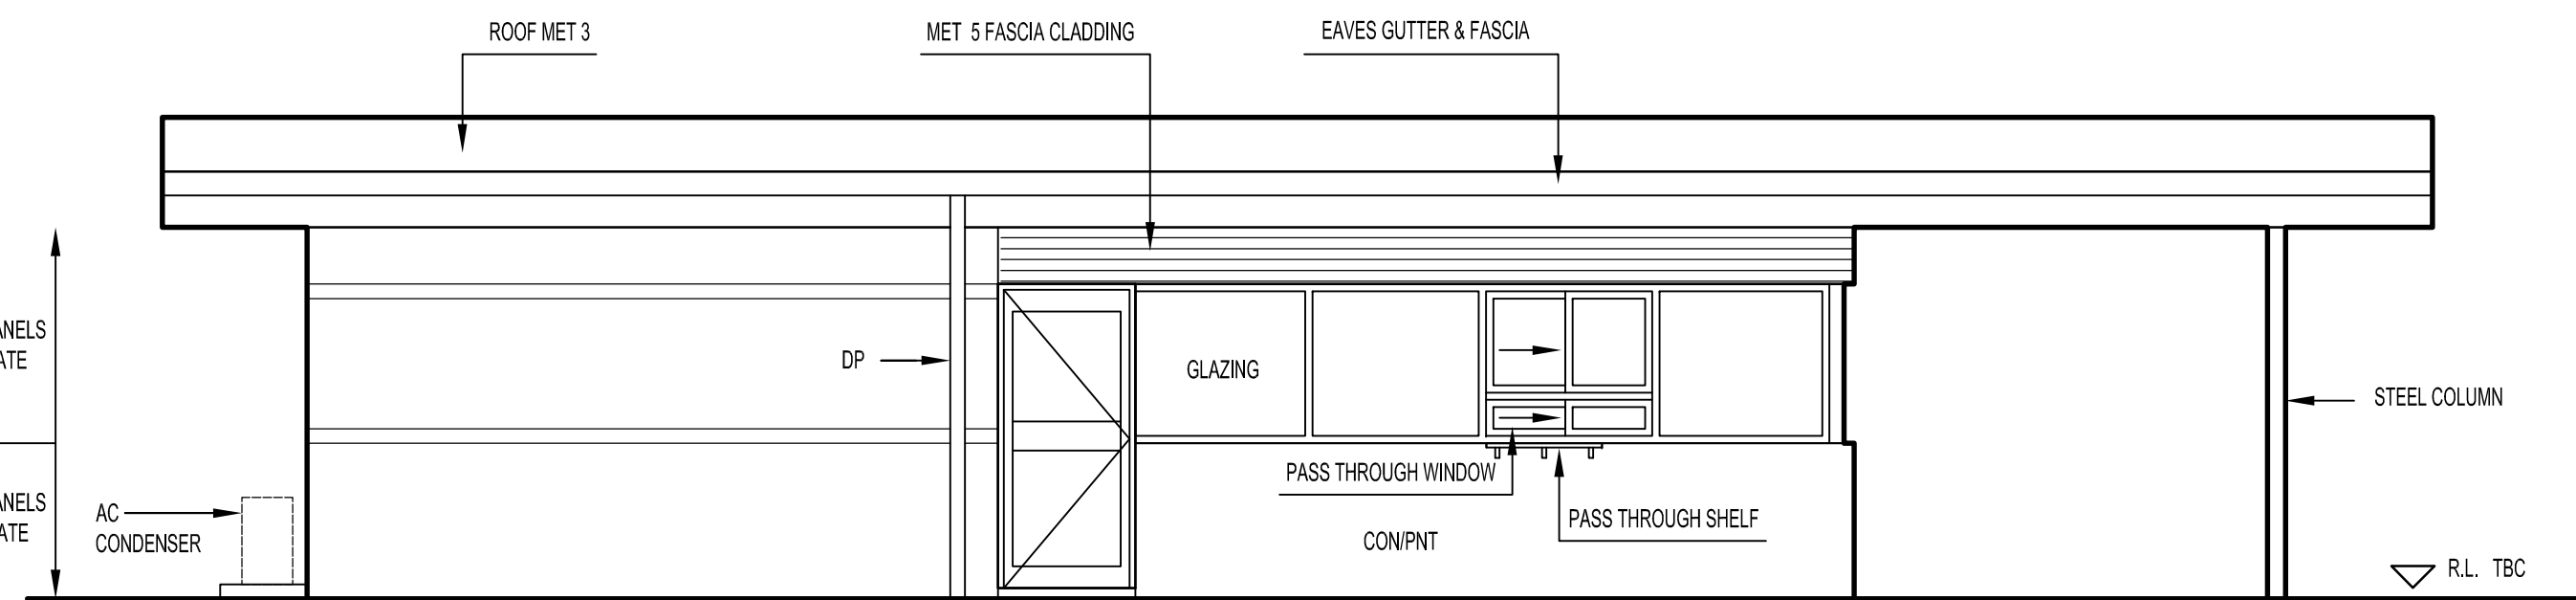


08 WEST ELEVATION
1:50

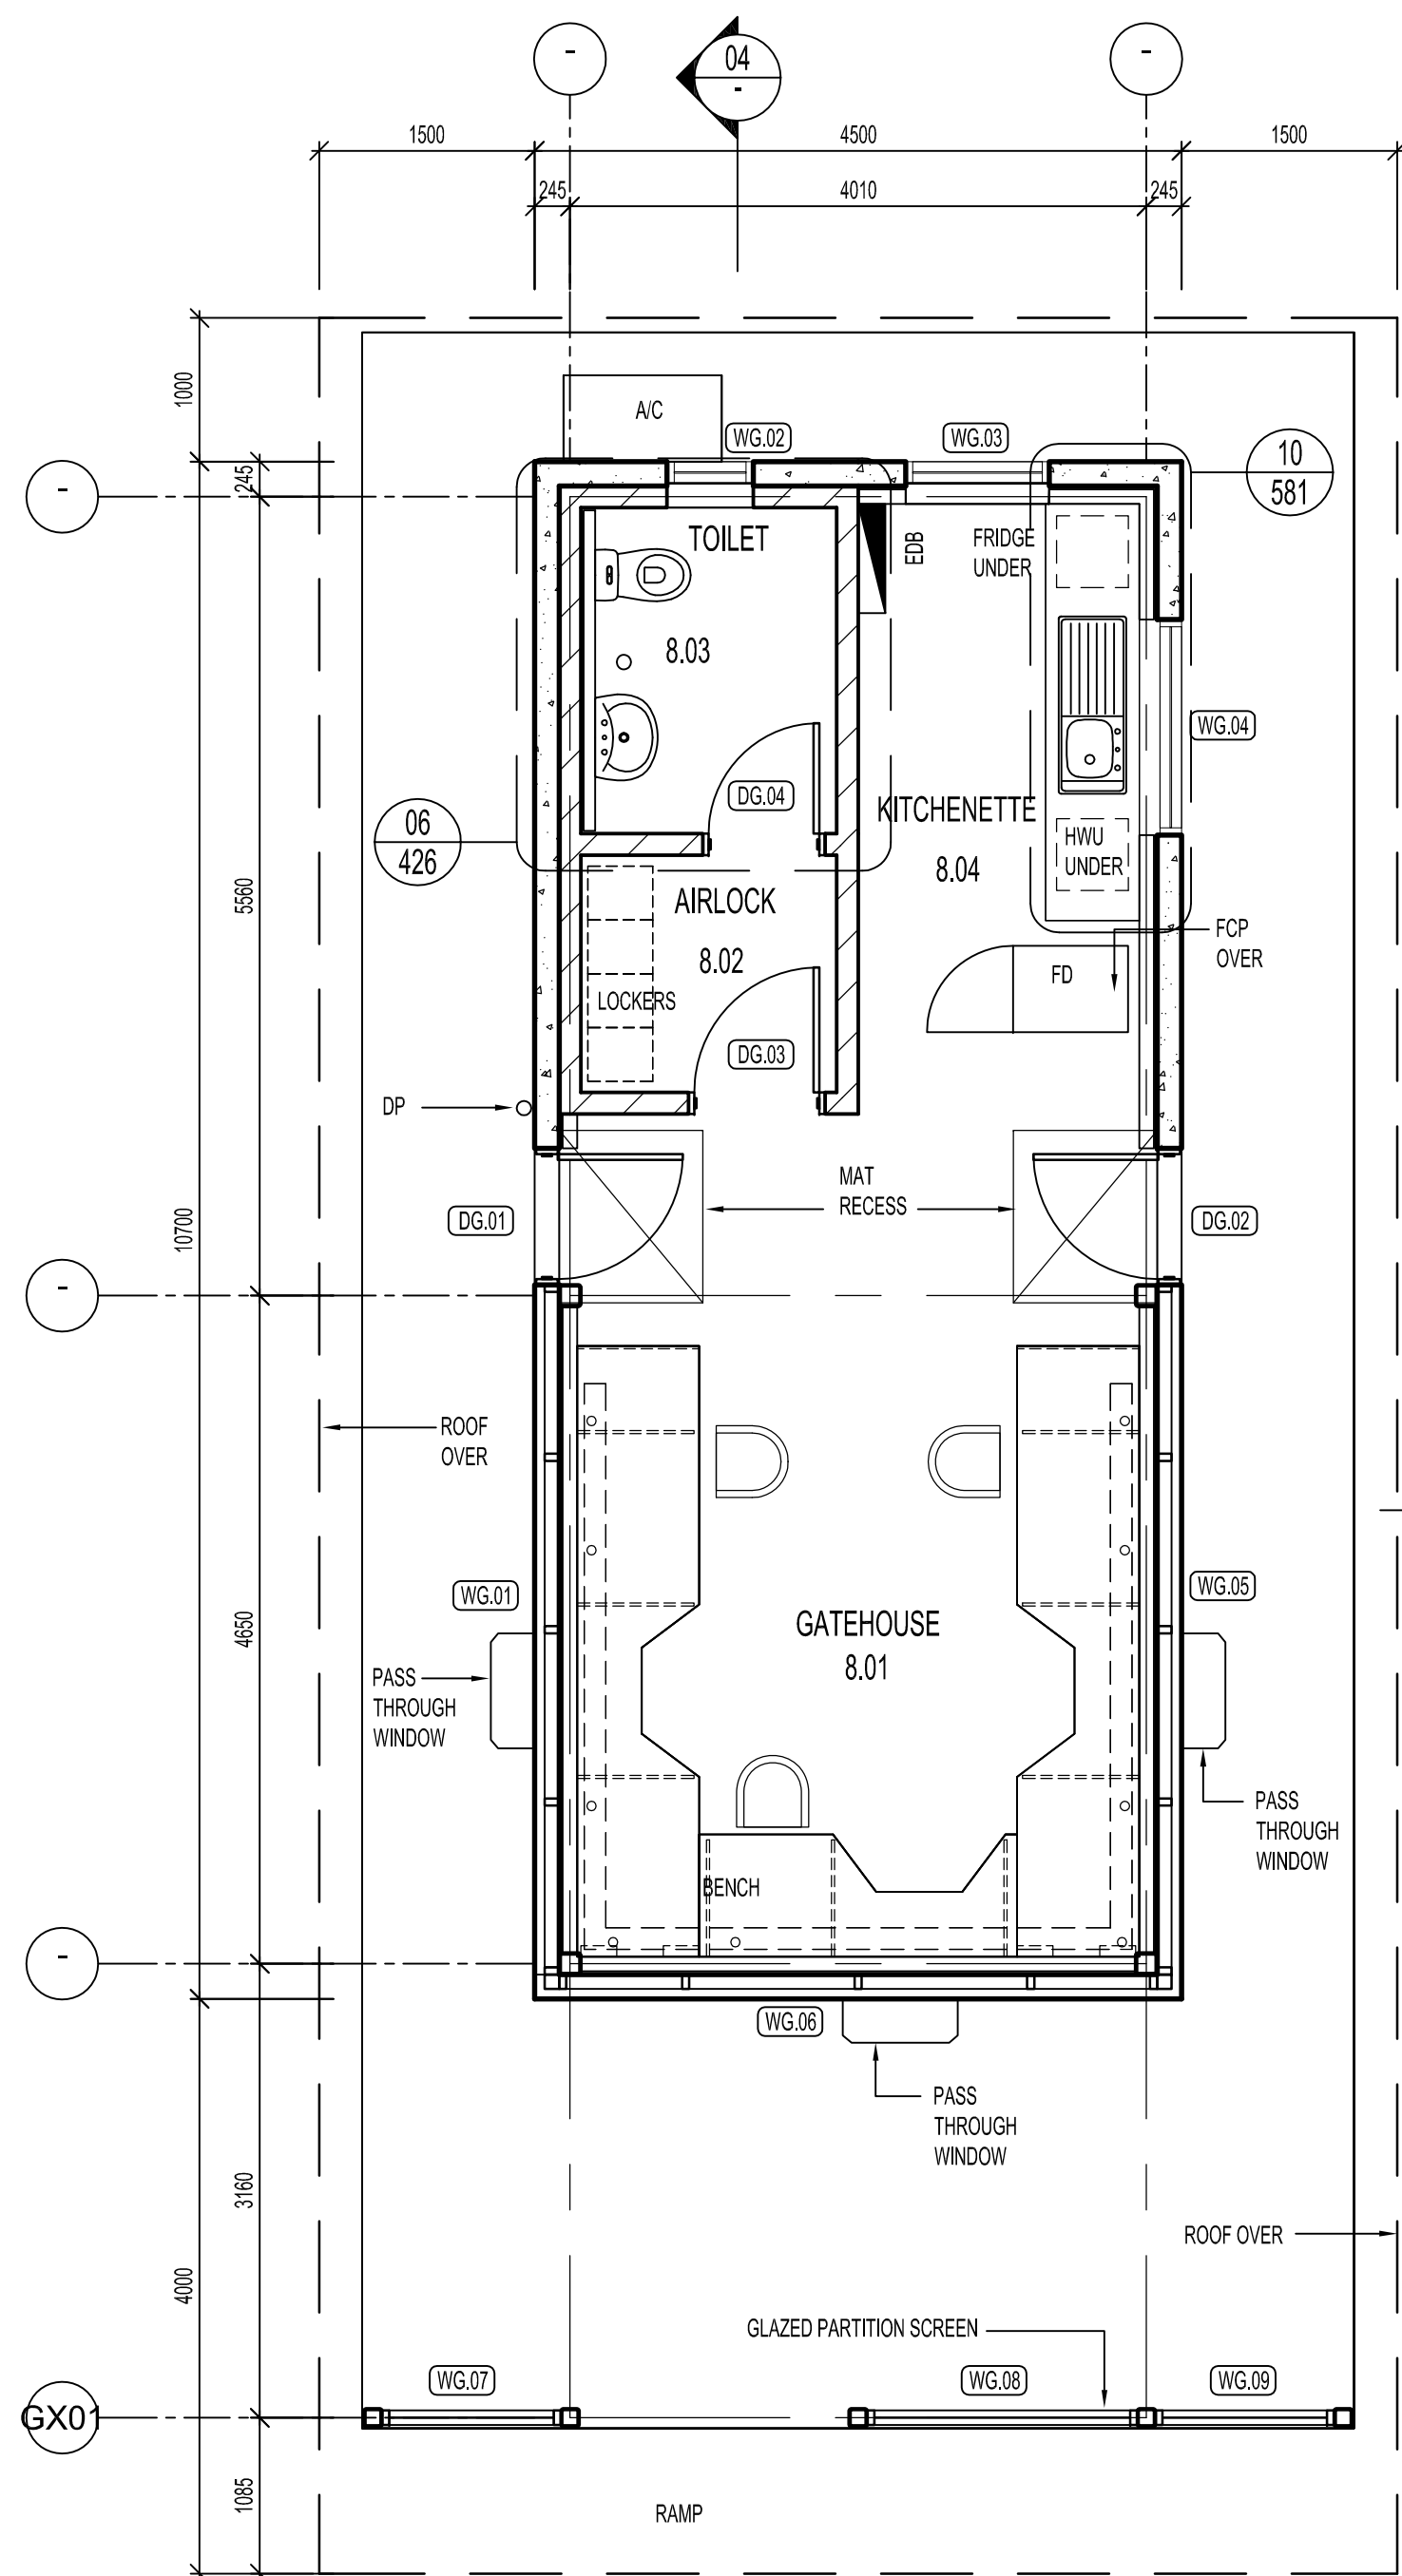


01 FLOOR PLAN
1:50

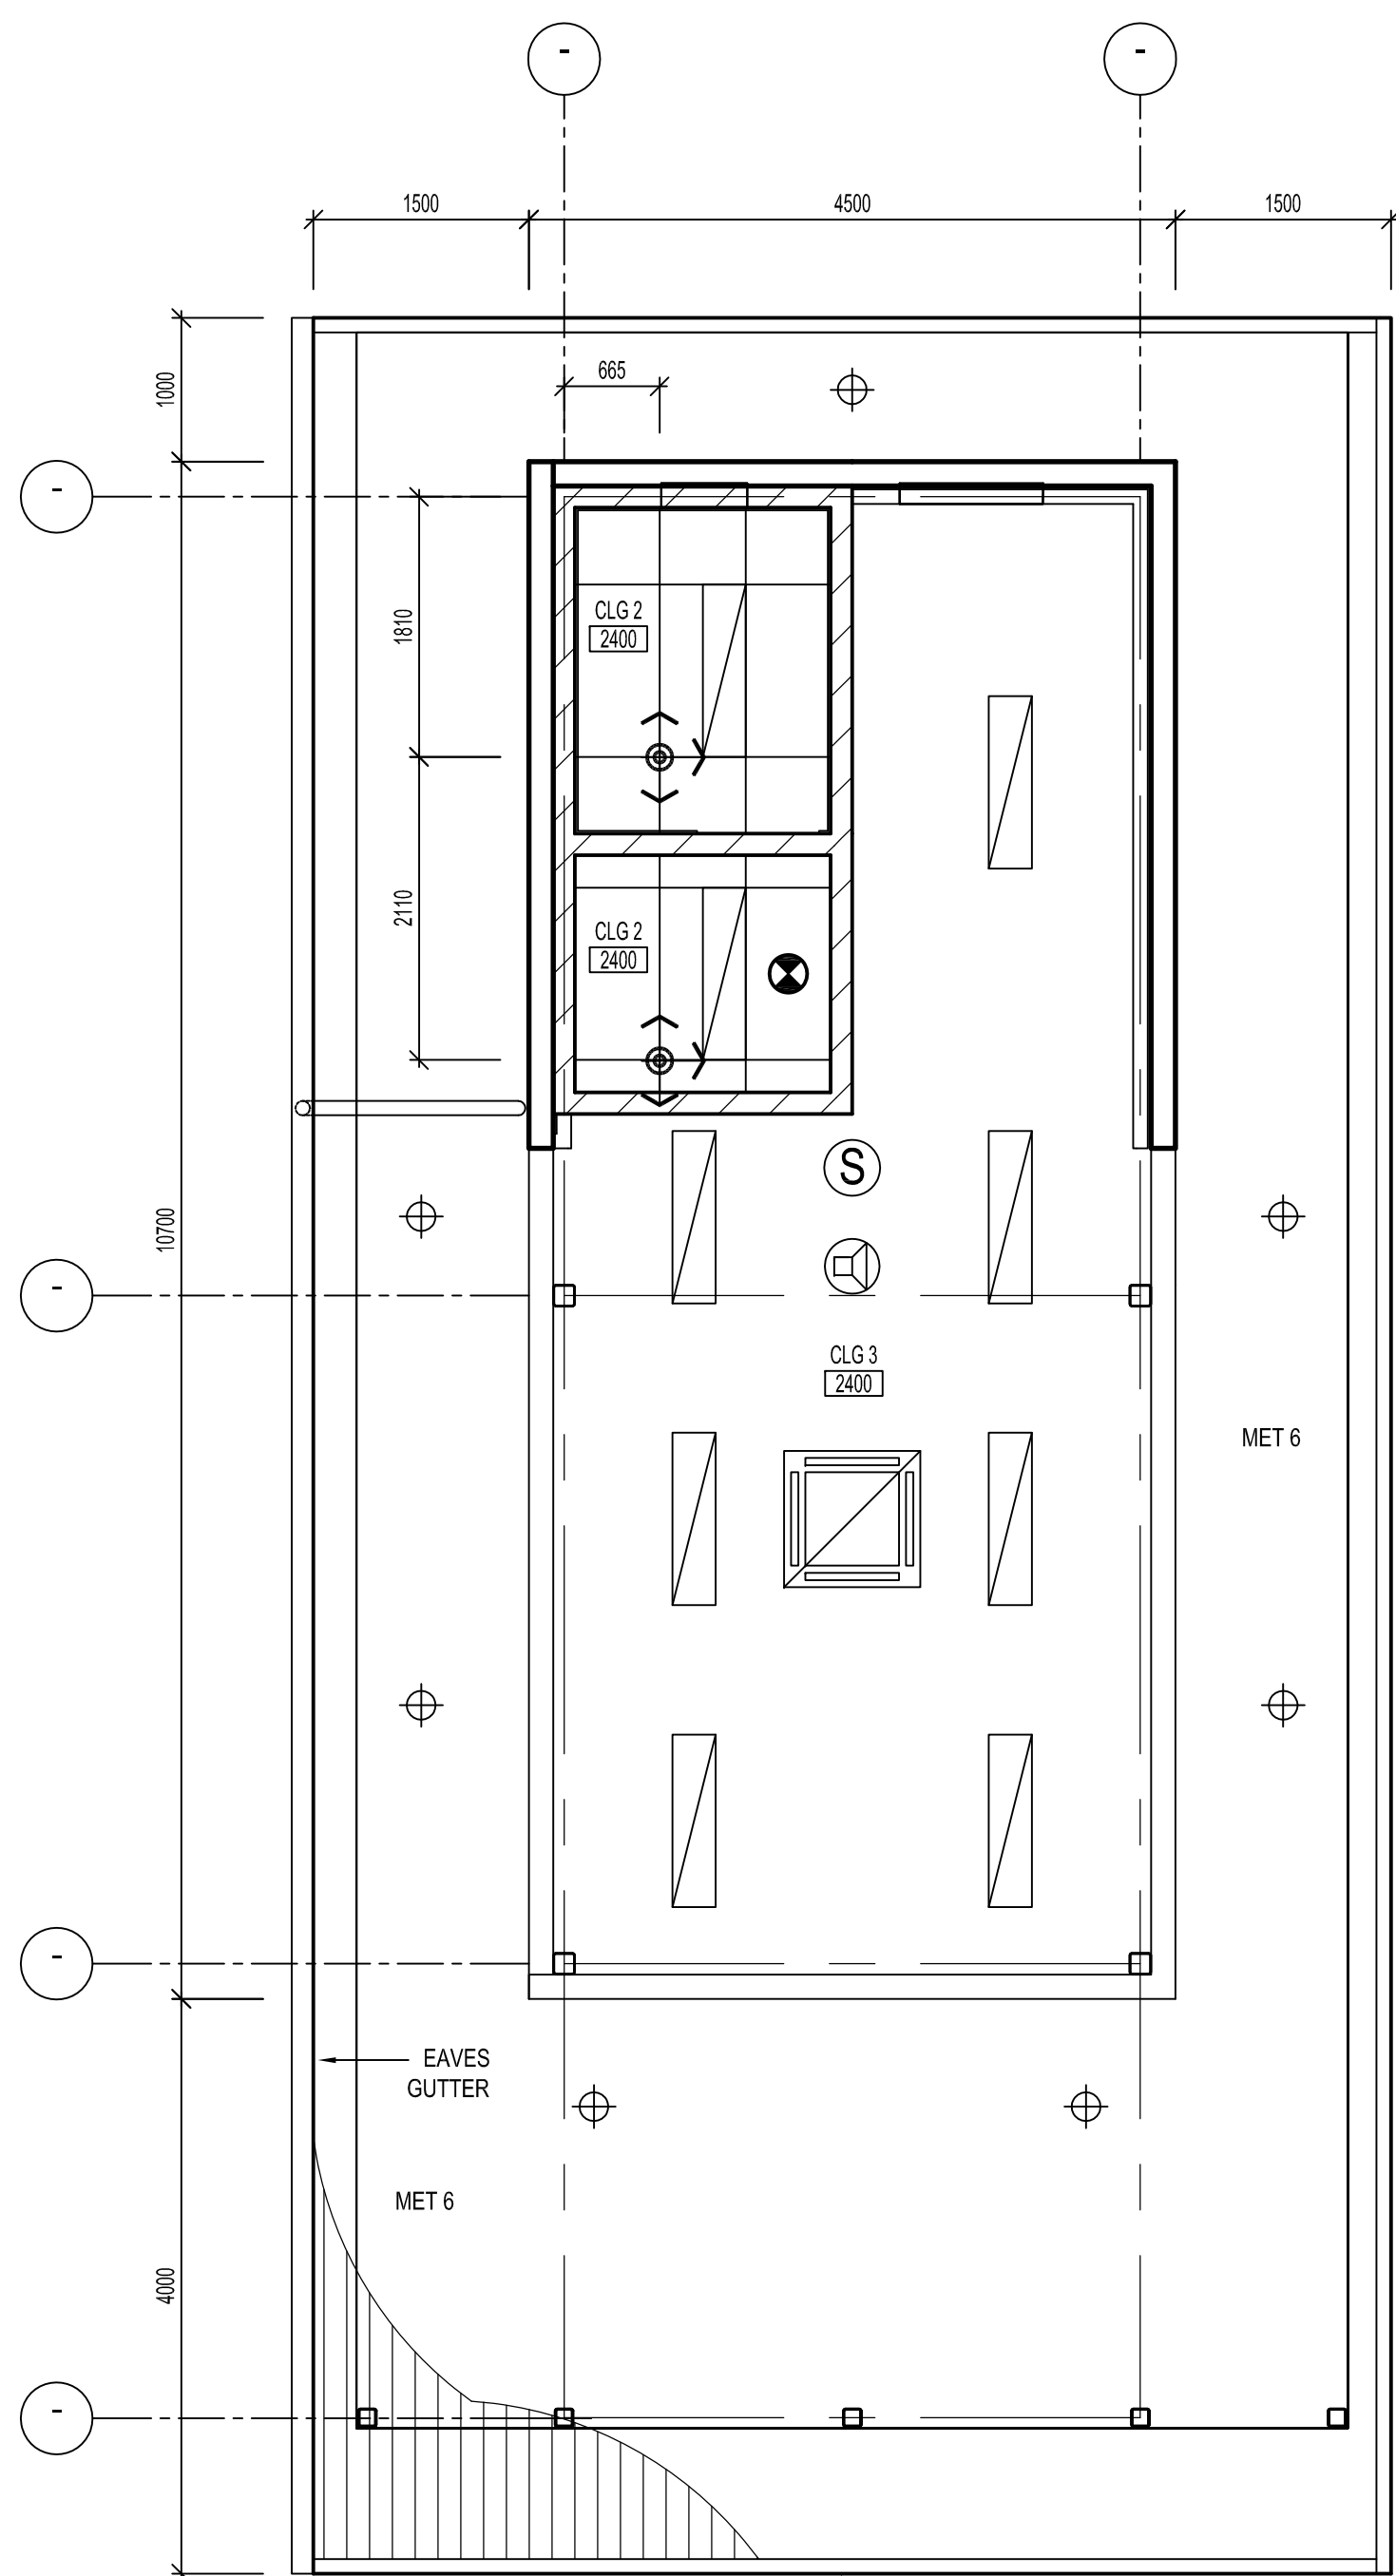


02 REFLECTED CEILING PLAN
1:50

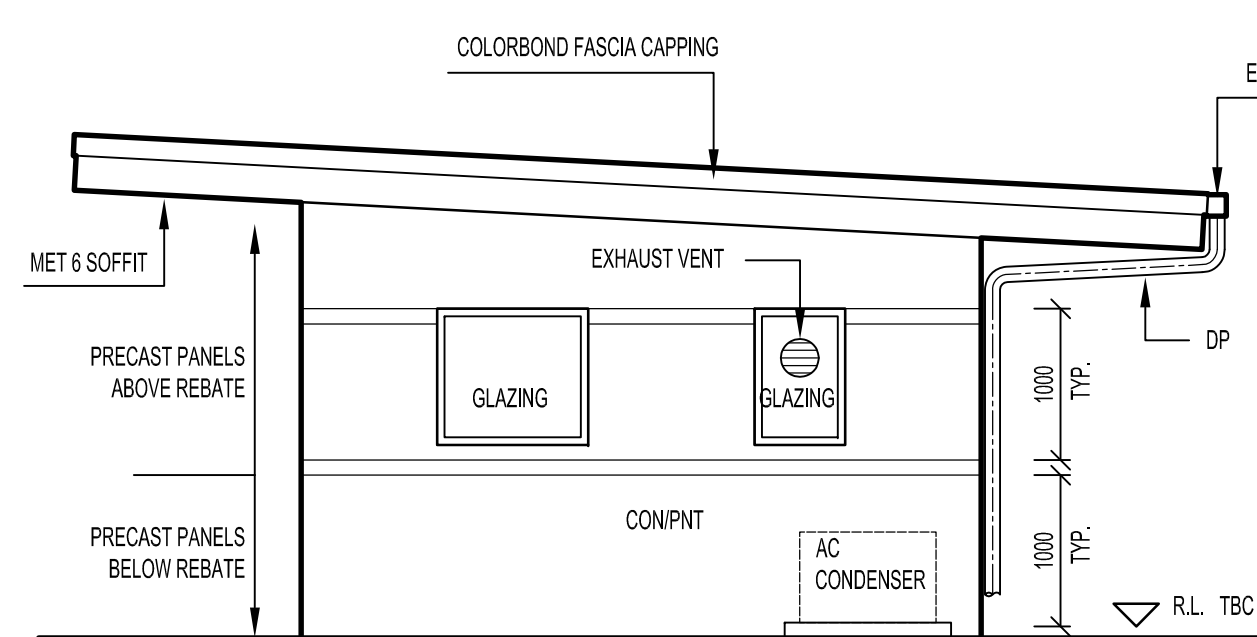

09 NORTH ELEVATION
1:50

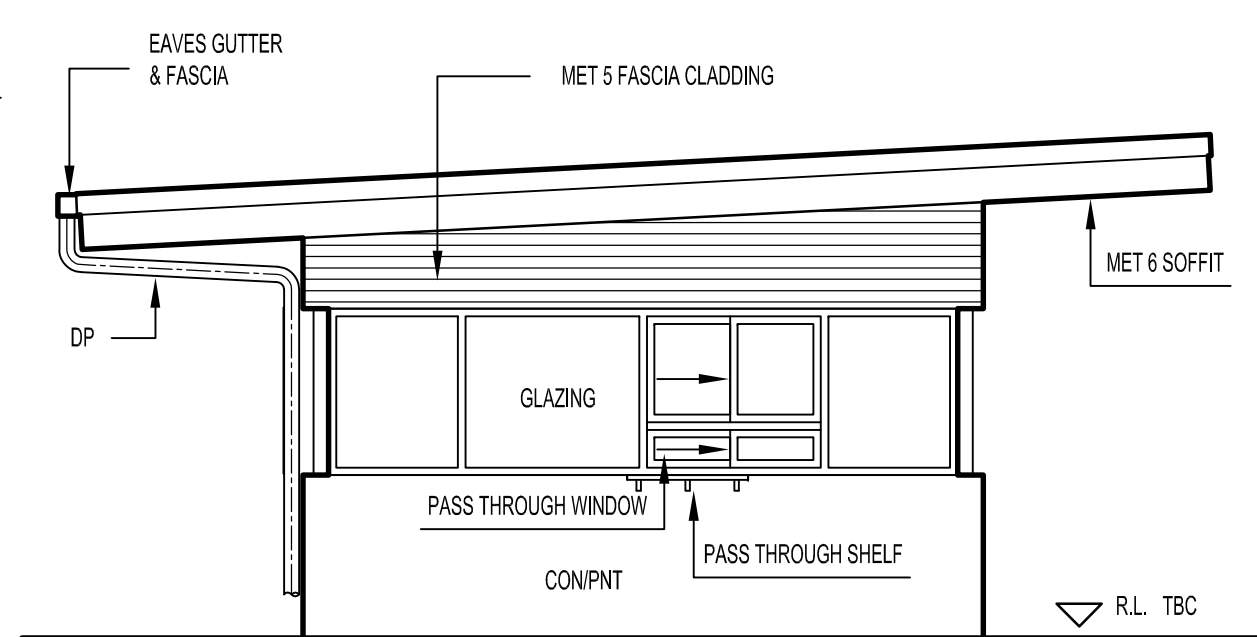


10 SOUTH ELEVATION
1:50

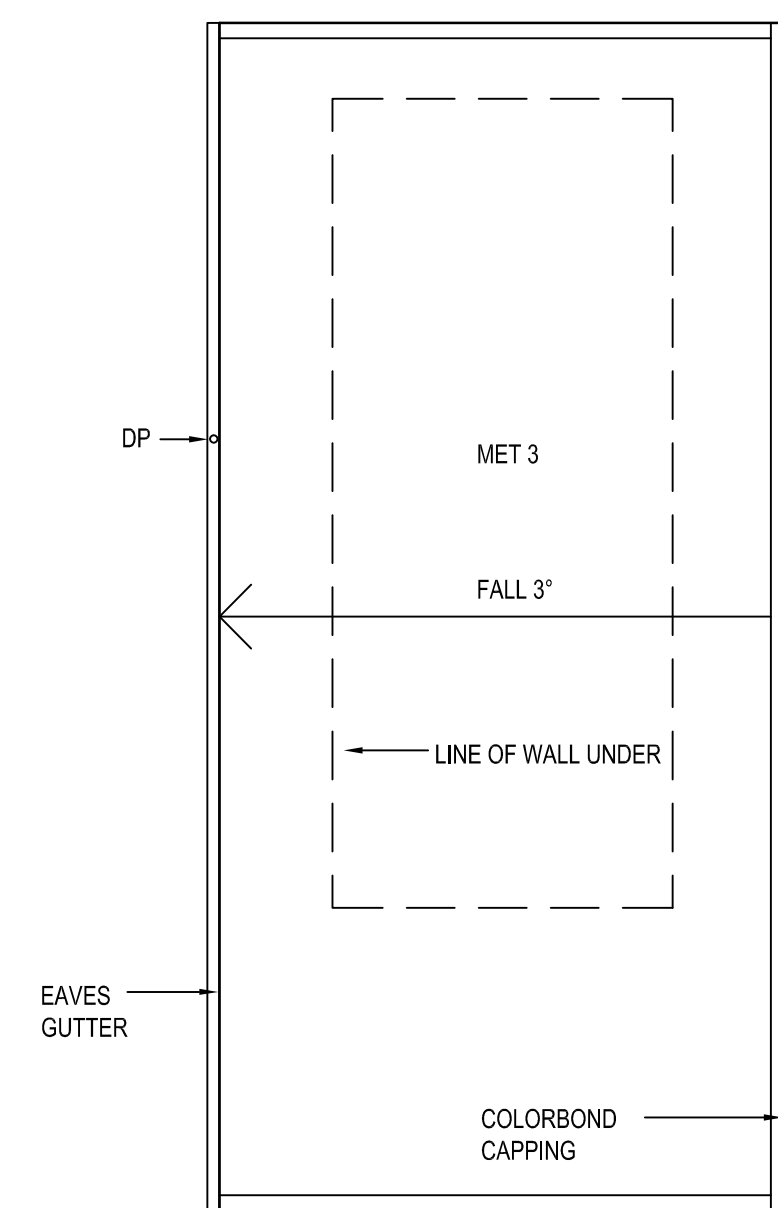

03 ROOF PLAN
1:100

LEGEND

- | | |
|--|---|
| | DISTRIBUTION BOARDS |
| | COAMS FLOOR DISTRIBUTOR |
| | CEILING GRID SETOUT POINTS |
| | FINISHED CEILING LEVEL ABOVE PFL |
| | LIGHT FITTINGS |
| | EMERGENCY LIGHT |
| | EXIT SIGN |
| | CEILING DIFFUSER |
| | RETURN AIR GRILLE |
| | EXHAUST GRILLE |
| | PENDANT SPRINKLER THROUGH TILE / SET PLASTERBOARD |
| | EXPOSED SPRINKLER HEAD |
| | SMOKE DETECTOR |
| | SPEAKER |
| | MOVEMENT JOINT |

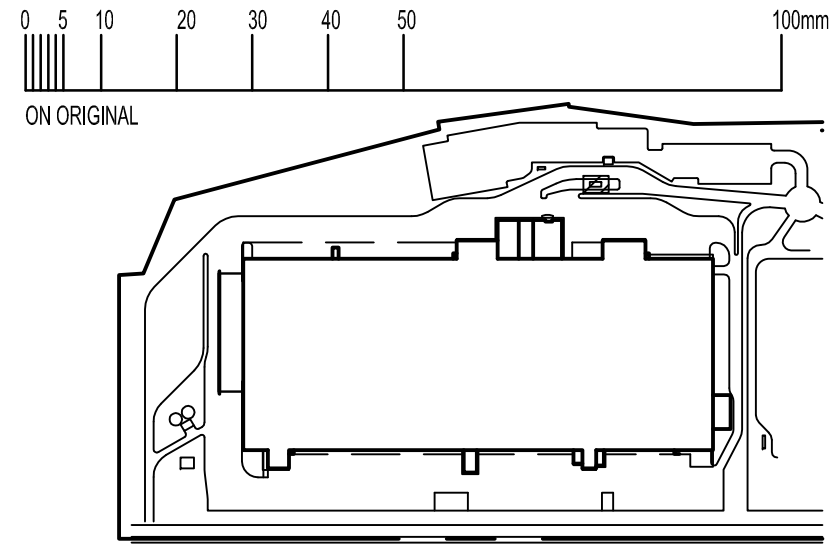

KEY PLAN

THE PROPERTY IN THIS DRAWING AND IN THE CONCEPTS REMAIN WITH MNIA ARCHITECTS PTY LTD. ANY UNAUTHORISED USE OF THIS DRAWING WHETHER AS THE WHOLE OR PART MAY RENDER THE USER LIABLE IN AN ACTION FOR DAMAGES. CONSEQUENTIAL DAMAGES ARISING FROM UNAUTHORISED OR UNAUTHORISED USE SHALL NOT RENDER MNIA ARCHITECTS PTY LTD LIABLE.

DIMENSIONS MUST NOT BE SCALED FROM DRAWINGS.

ALL DIMENSIONS TO BE CONFIRMED ON SITE PRIOR TO THE COMMENCEMENT OF ANY WORK.

B	05.02.10	TITLE BLOCK ALTERED	FZ
A	18.01.10	NEW DRAWING, PROMOTED FROM 0980 ARD0470A	FZ

REV. DATE AMENDMENT SIGNED

CLIENT
Mirvac Projects Pty. Ltd
ABN 72 001 089 245
Level 26, 80 Margaret St.
Sydney, NSW, 2000
tel. 02 9080 8000
fax. 02 9080 8181



PROJECT
BIG W
DISTRIBUTION CENTRE
HOXTON PARK NSW

ARCHITECT
MNIA ARCHITECTS
Level 4, 8 Help Street
PO Box 1212
Chatswood NSW 2067
Telephone (02) 9495 6400
Facsimile (02) 9495 6444
mail@mnia.com.au

STRUCTURAL & CIVIL ENGINEERS
COSTIN ROE CONSULTING PTY LTD
Suite 310, 55 Harrington St, The Rocks Sydney NSW 1220
Tel: (02) 9251 7699 Fax: (02) 9241 3731

ELECTRICAL & MECHANICAL ENGINEERS
SHELMERDINES
55 Hume St, Crows Nest NSW 2065
Tel: (02) 9436 3021 Fax: (02) 9439 8709

FIRE ENGINEERS
AECOM
Level 11, 44 Market St Sydney NSW 2000
Tel: (02) 6295 7535 Fax: (02) 6295 7500

HYDRAULIC ENGINEERS
NIVEN DONNELLY & PARTNERS PTY LTD
Suite 1, 769 Pacific Highway, Chatswood NSW 2067
Tel: (02) 9884 8911 Fax: (02) 9884 8977

TITLE
GATEHOUSE

DATE	18-12-09	PROJECT No.	0930	STATUS	AR/DA
SCALE	1:50 / 1:100 (B1)				
DRAWN	SC/GL				
CHECKED		DWG No.		REV No.	
APPROVED			DA 20	/B	