


Disclaimer: Robert Bird Group Pty Ltd (RBG) and its related entities (RBG) do not warrant the accuracy, currency, or completeness of any information or data they supply or transfer by electronic means. You are responsible for verifying that any information or data supplied or transferred by electronic means satisfies the information or data on the corresponding paper or other version issued by RBG. RBG shall not be liable for any loss or damage, however caused, which you or any other party may directly or indirectly suffer in connection with your access to or use of that information or data.

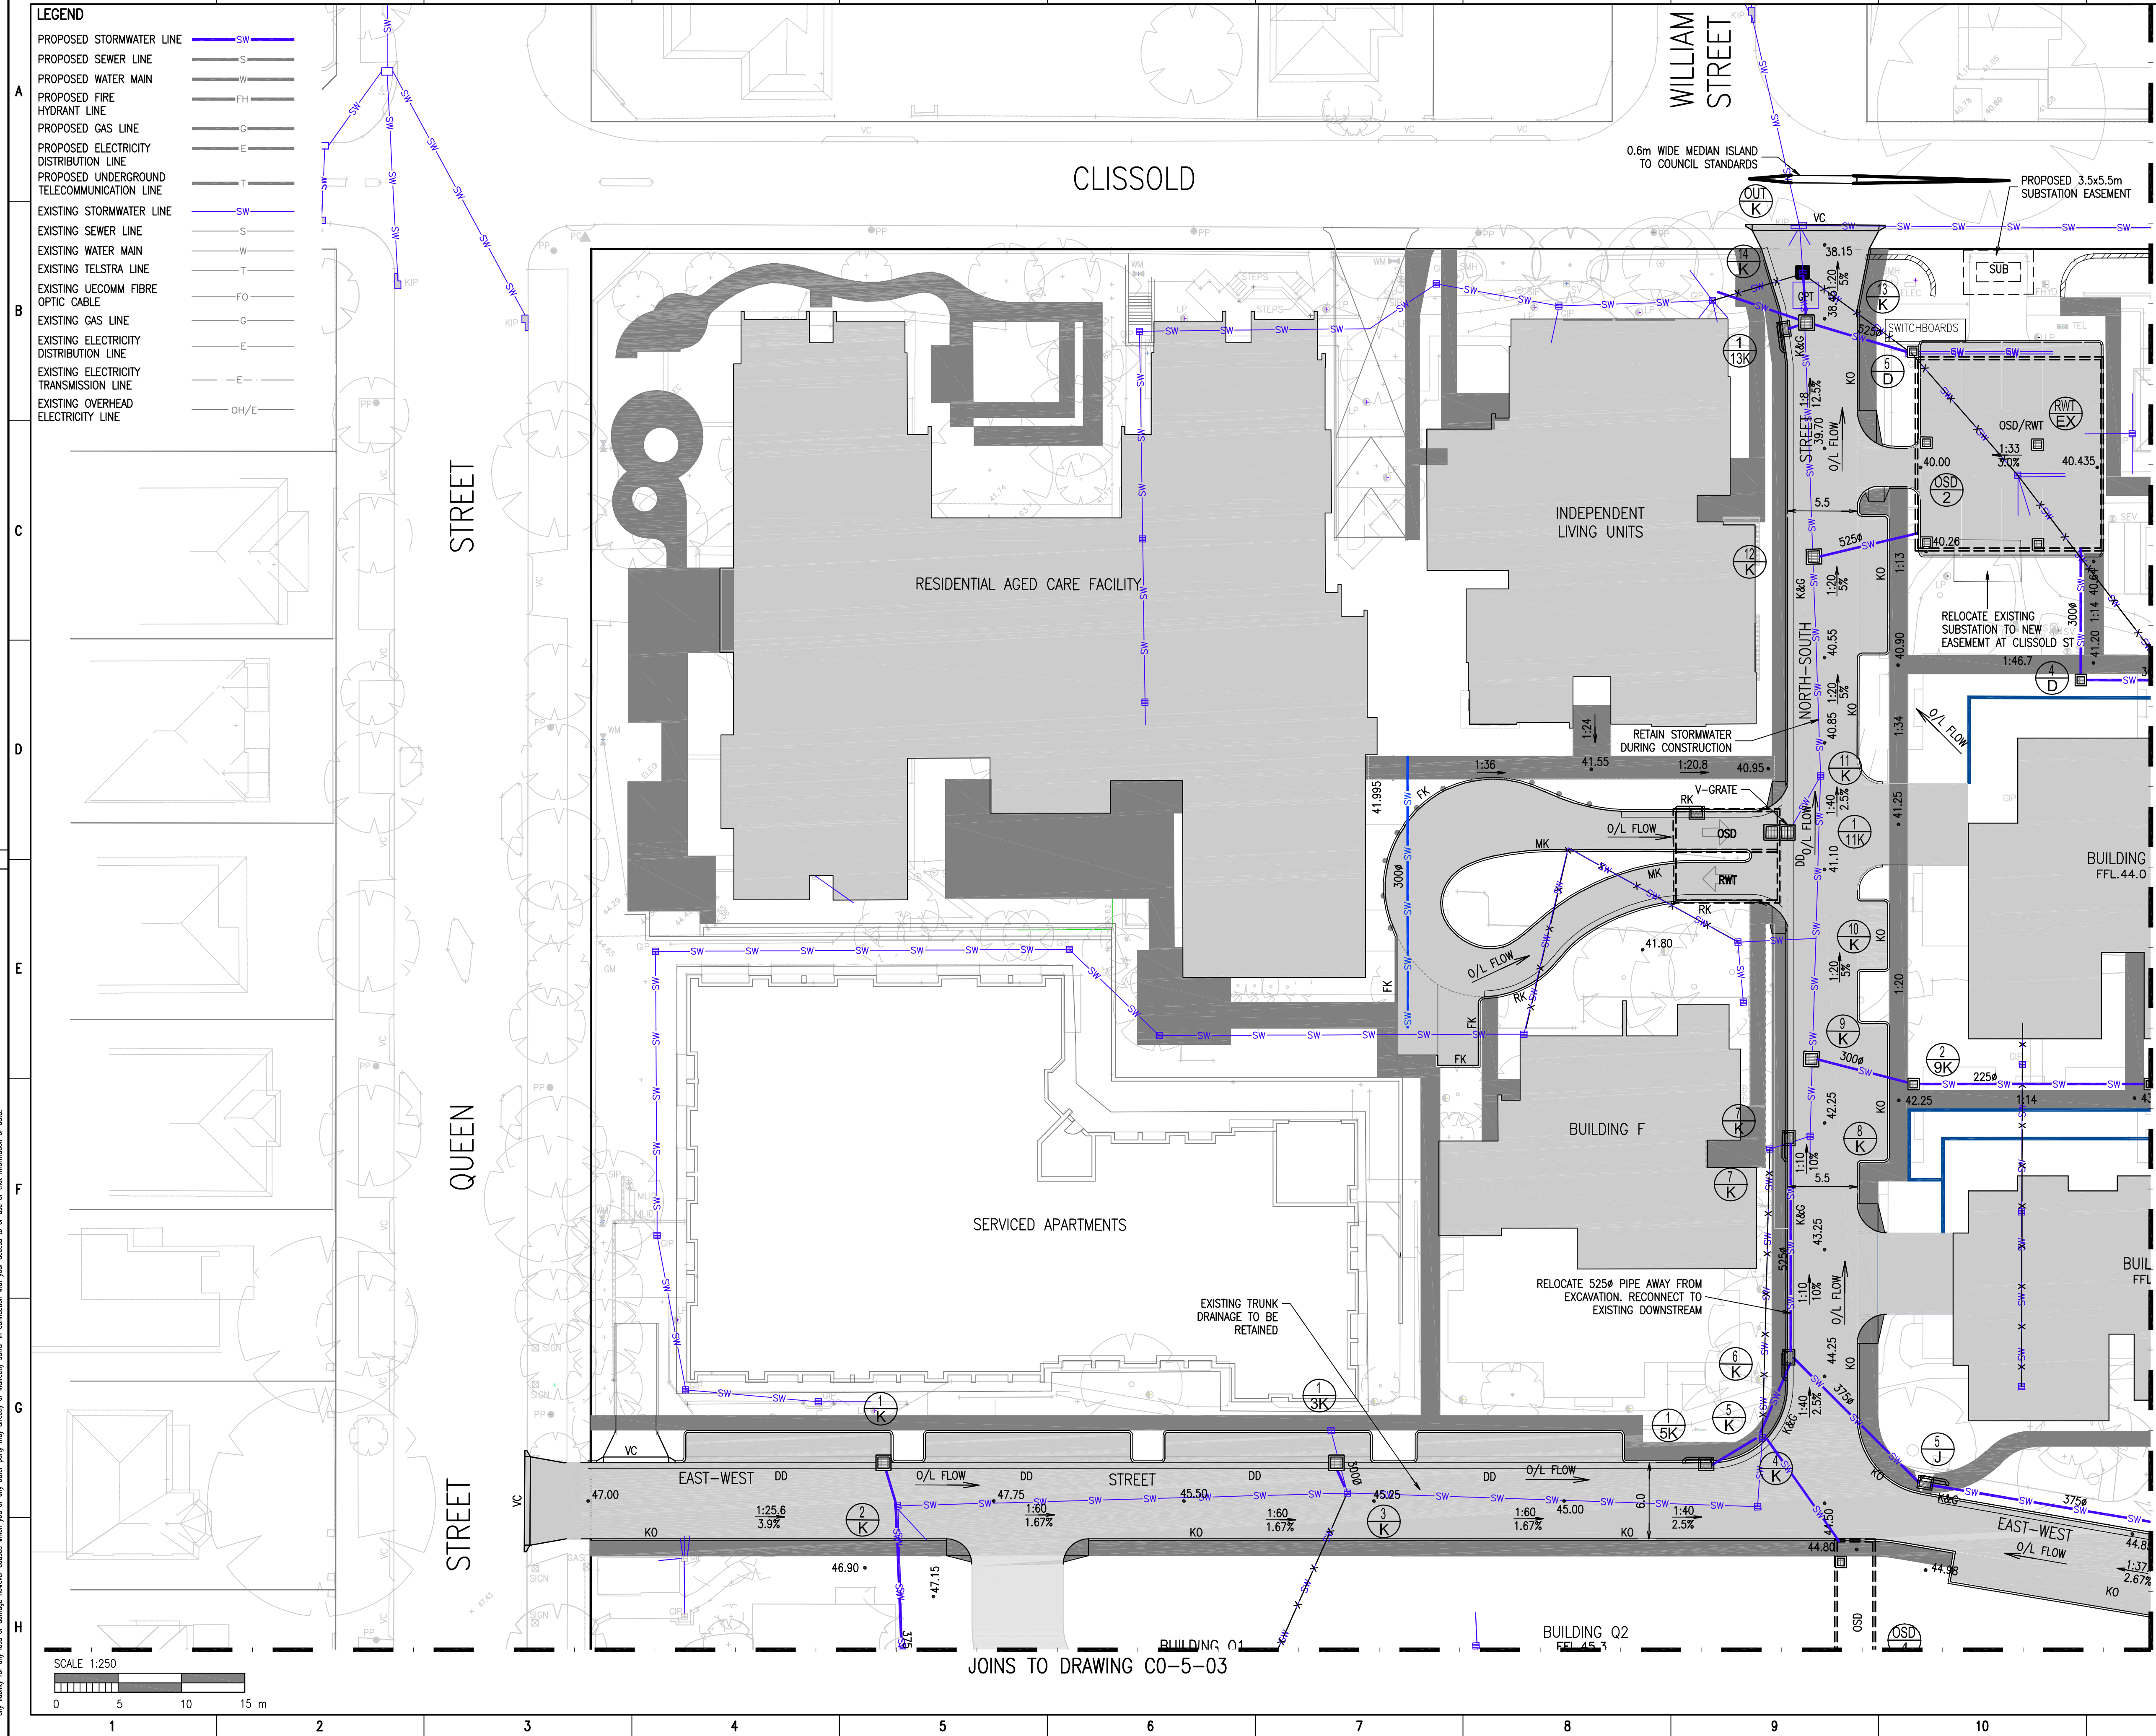

DO NOT SCALE DRAWINGS, USE FIGURED DIMENSIONS
REFER COVER SHEET FOR NOTES UNLESS NOTED OTHERWISE

FOR APPROVAL

KEYPLAN

C0-5-01 C0-5-02 C0-5-03 C0-5-04

| Rev. | Revision Description | By | App. | Date |
|------|-------------------------|-----|------|----------|
| 3 | ISSUED FOR APPROVAL | CFB | CFB | 14.10.09 |
| 2 | ISSUED FOR COORDINATION | TQD | CFB | 31.07.09 |
| 1 | ISSUED FOR COORDINATION | TQD | CFB | 25.05.09 |

Structural & Civil Engineering Consultant

RobertBirdGroup

Client

AEVUM LIMITED
Level 6, 23-35 O'Connell St, Sydney, NSW 2000
PH (02) 8223 0900
FAX (02) 8753 2222

Project

CARDINAL FREEMAN VILLAGE MASTERPLAN

Title


STORMWATER DRAINAGE PLAN SHEET 1 OF 4

| Date | Design | Checked |
|----------|-------------|---------|
| 13.10.09 | C.Bartolome | |

| Scale | Drawn | Approved |
|----------|---------|----------|
| AS SHOWN | C.Waite | |

| Job Number | Drawing Number | Revision |
|------------|----------------|----------|
| 09162 | C0-5-01 | 3 |

Disclaimer: Robert Bird Group Pty Ltd (RBG) and its related entities (RBG) do not warrant the accuracy, currency, or completeness of any information or data they supply or transfer by electronic means. You are responsible for verifying that any information or data supplied or transferred by electronic means satisfies the information or data for the corresponding project or figure version issued by RBG. RBG shall not be liable for any loss or damage, however caused, which you or any other party may directly or indirectly suffer in connection with your access to or use of that information or data.

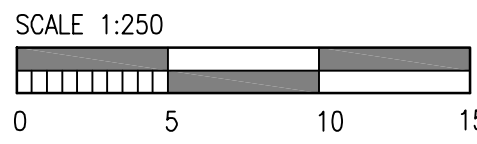

JOINS TO DRAWING C0-5-01

JOINS TO DRAWING C0-5-04


STREET

STREET

VICTORIA

LEGEND

PROPOSED STORMWATER LINE — SW —
PROPOSED SEWER LINE — S —
PROPOSED WATER MAIN — W —
PROPOSED FIRE — FH —
PROPOSED GAS LINE — G —
PROPOSED ELECTRICITY DISTRIBUTION LINE — E —
PROPOSED UNDERGROUND TELECOMMUNICATION LINE — T —
EXISTING STORMWATER LINE — SW —
EXISTING SEWER LINE — S —
EXISTING WATER MAIN — W —
EXISTING TELSTRA LINE — T —
EXISTING UECOMM FIBRE OPTIC CABLE — FO —
EXISTING GAS LINE — G —
EXISTING ELECTRICITY DISTRIBUTION LINE — E —
EXISTING ELECTRICITY TRANSMISSION LINE — E —
EXISTING OVERHEAD ELECTRICITY LINE — OH/E —

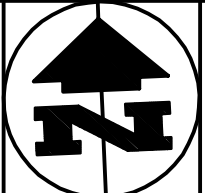


Unless agreed otherwise by Robert Bird Group Pty Ltd (RBG) ACN 010 580 348 in writing, intellectual property rights in any information or data supplied or transferred to you (including copyright in all text, graphics, logos, icons, sound recordings and software) are owned by, or licensed to, RBG. Other than for purposes authorised by RBG in writing, you must not copy, adapt, reproduce, store, publish or commercialise any information or data supplied or transferred by electronic means without RBG's prior written permission. © Robert Bird Group Pty Ltd 2009

DO NOT SCALE DRAWINGS, USE FIGURED DIMENSIONS
REFER COVER SHEET FOR NOTES UNLESS NOTED OTHERWISE

FOR APPROVAL

KEYPLAN

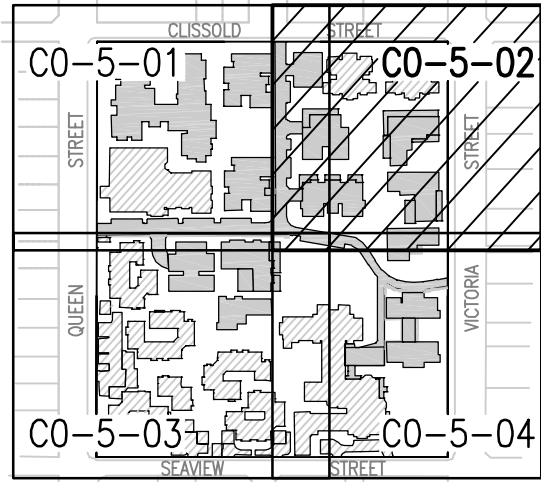

| | | | | |
|---|-------------------------|-----|-----|----------|
| 3 | ISSUED FOR APPROVAL | CFB | CFB | 14.10.09 |
| 2 | ISSUED FOR COORDINATION | TQD | CFB | 31.07.09 |
| 1 | ISSUED FOR COORDINATION | TQD | CFB | 25.06.09 |

| Rev. | Revision Description | By | App. | Date |
|------|----------------------|----|------|------|
|------|----------------------|----|------|------|

Structural & Civil Engineering Consultant
RobertBirdGroup
BRISBANE OFFICE:
Robert Bird Group Pty Ltd
PO Box 7035, Riverside Centre,
Brisbane, QLD 4001
Level 5, 333 Ann St
Brisbane QLD
Ph: (07) 3319 2777
Fax: (07) 3319 2799
ACN: 010 580 348

Client
AEVUM LIMITED
Level 6, 23-35 O'Connell St, Sydney, NSW 2000
PH (02) 8223 0900
FAX (02) 8753 2222

Project
CARDINAL FREEMAN VILLAGE MASTERPLAN

Title
STORMWATER DRAINAGE PLAN SHEET 2 OF 4

Date
13.10.09
Scale
AS SHOWN
AS SHOWN

Design
C.Bartolome
Drawn
C.Waite

Checked
Approved



Job Number
09162

Drawing Number
C0-5-02

Revision
3

Disclaimer: Robert Bird Group Pty Ltd ACN 010 580 248 and its related entities (RBG) do not warrant the accuracy, currency, or completeness of any information or data they supply or transfer by electronic means. You are responsible for verifying that any information or data supplied or transferred by electronic means satisfies the information or data on the corresponding paper or other version issued by RBG. RBG shall not be liable for any loss or damage, however caused, which you or any other party may directly or indirectly suffer in connection with your access to or use of that information or data.

A1

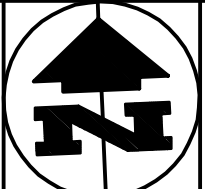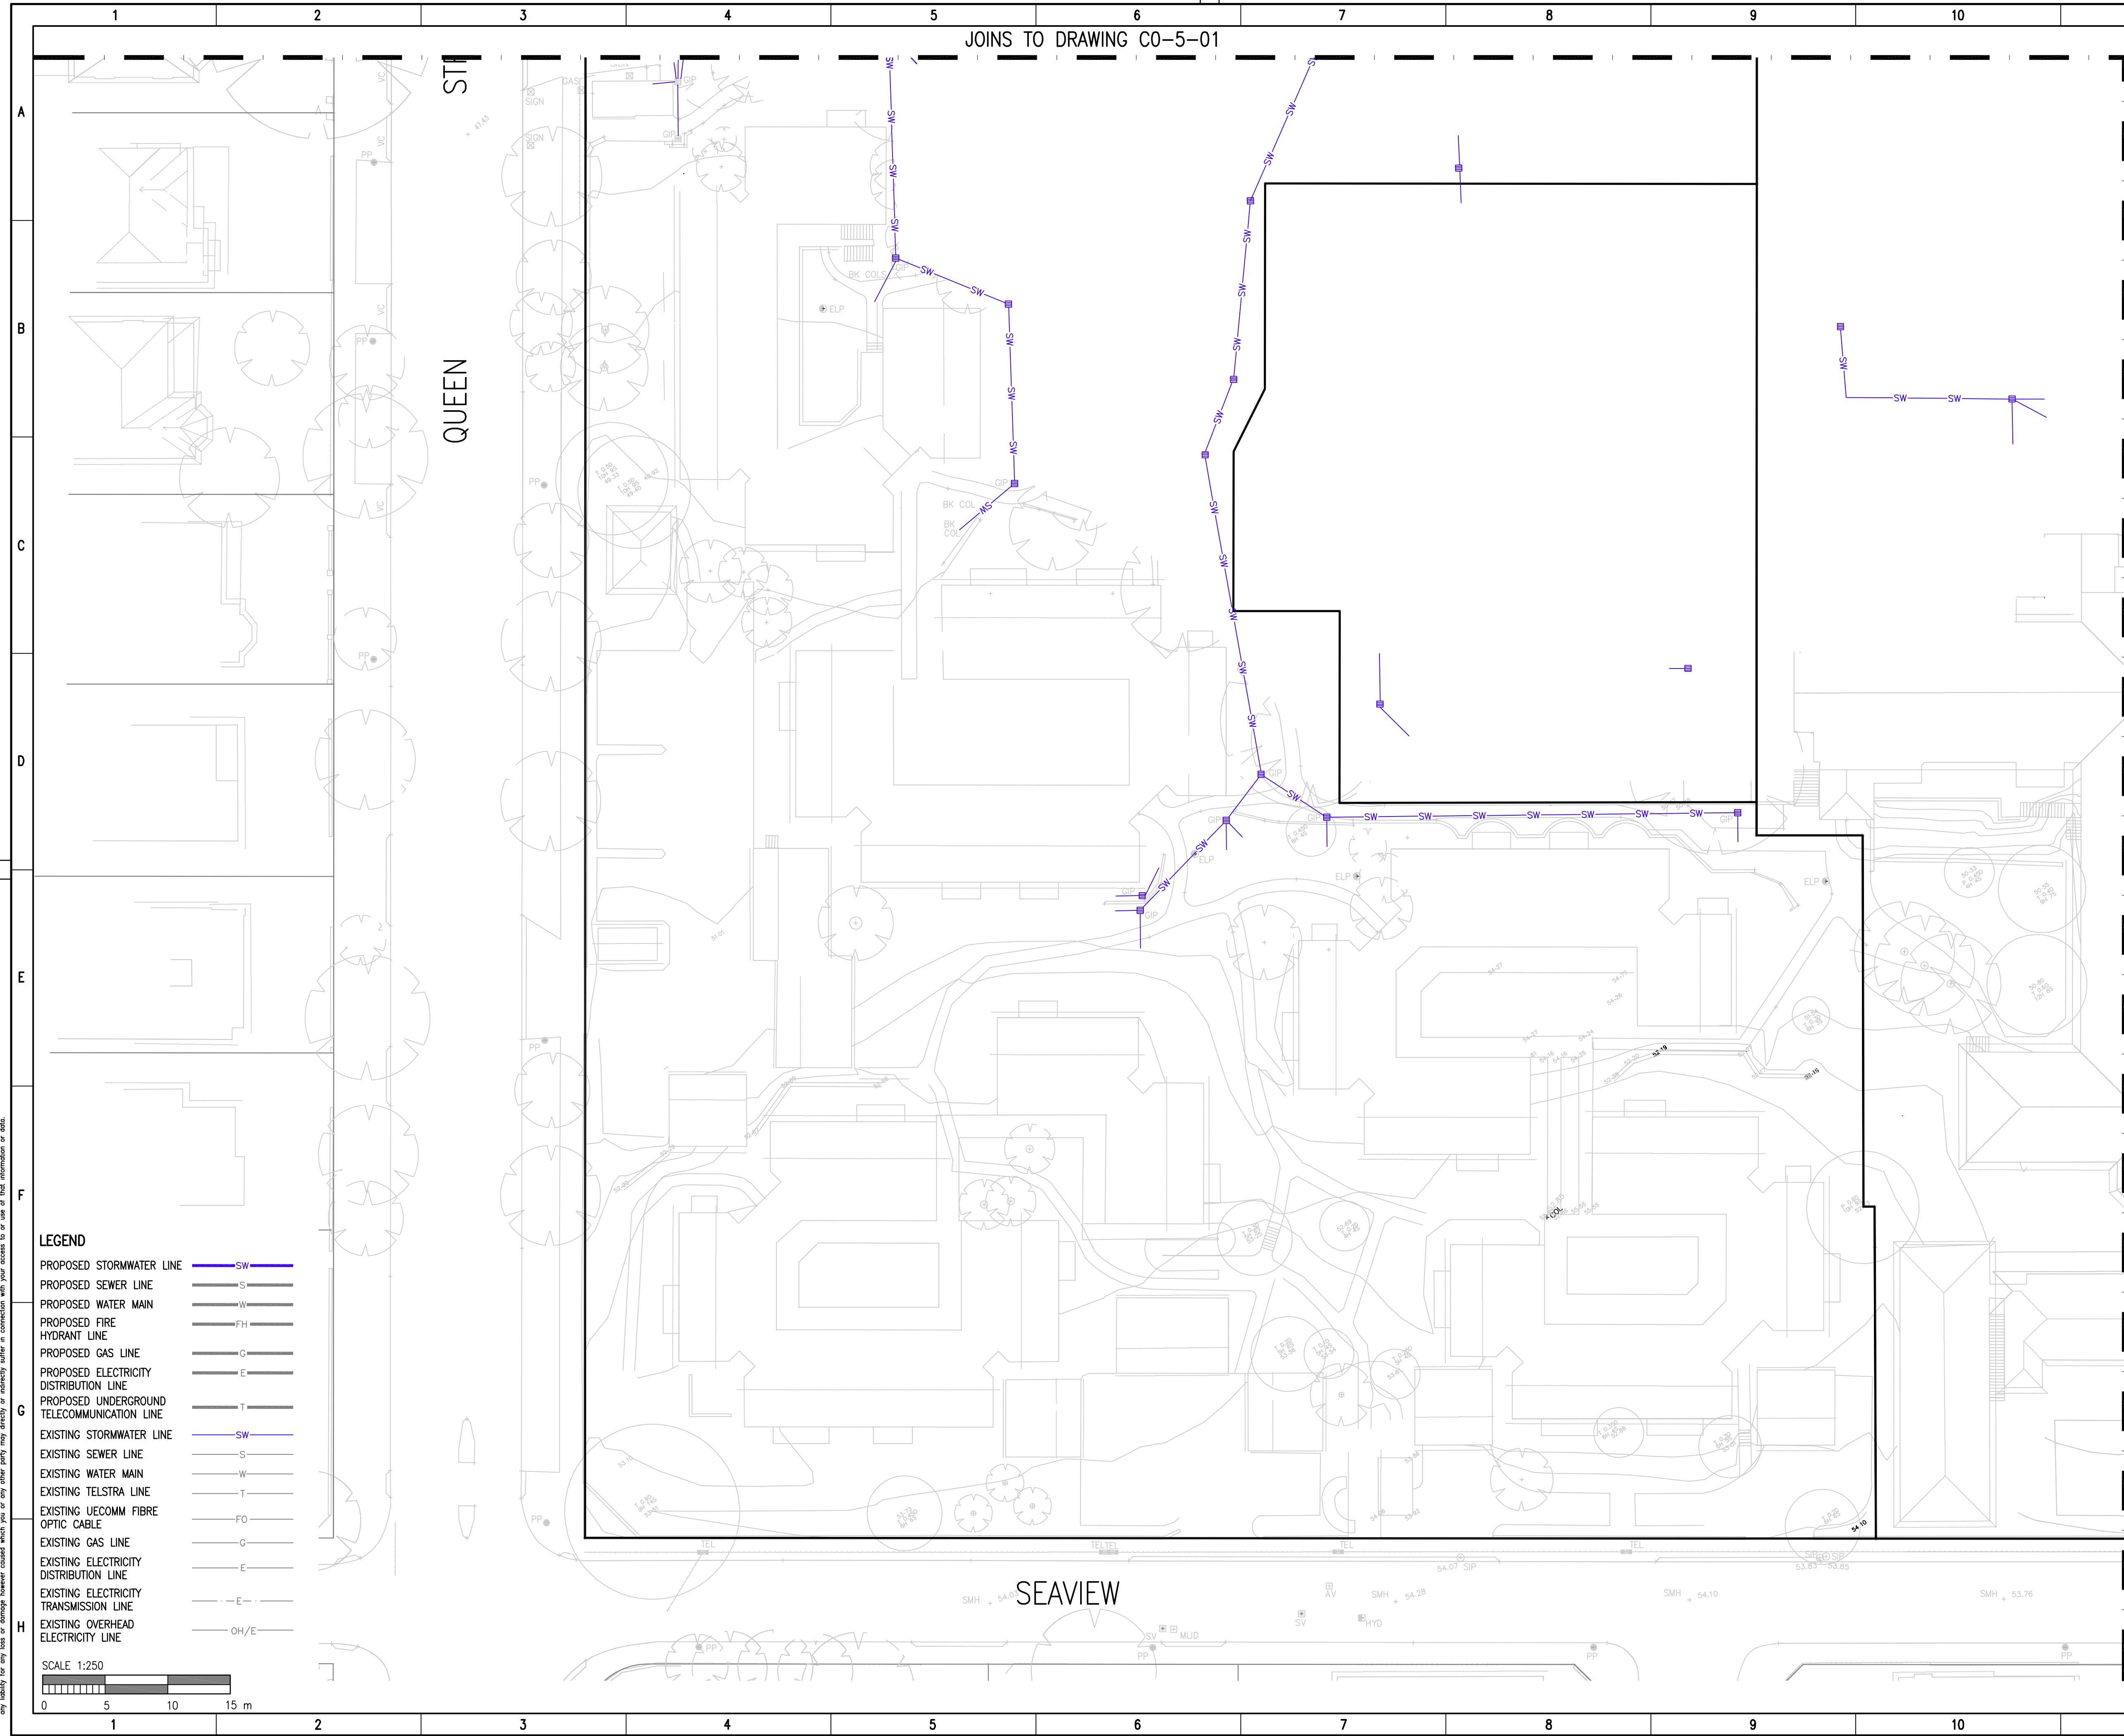


Unless agreed otherwise by Robert Bird Group Pty Ltd (RBG) ACN 010 580 248 in writing, intellectual property rights in any information or data supplied or transferred to you (including copyright in all text, graphics, logos, icons, sound recordings and software) are owned by, or licensed to, RBG. Other than for purposes authorised by RBG in writing, you must not copy, adapt, reproduce, store, publish or commercialise any information or data supplied or transferred by electronic means without RBG's prior written permission. © Robert Bird Group Pty Ltd 2009

DO NOT SCALE DRAWINGS, USE FIGURED DIMENSIONS
REFER COVER SHEET FOR NOTES UNLESS NOTED OTHERWISE

FOR APPROVAL

KEYPLAN

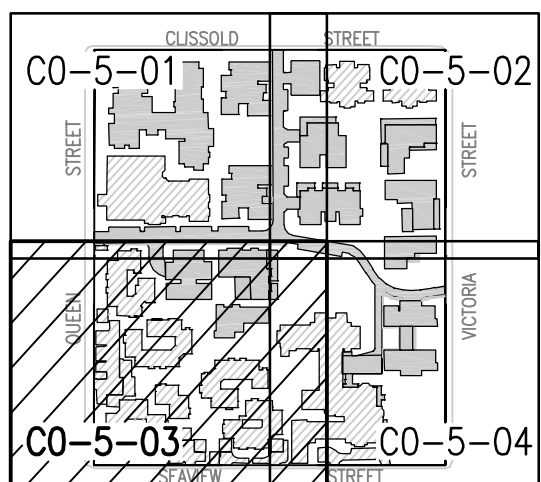

JOINS TO DRAWING C0-5-04

| | | | | |
|---|-------------------------|-----|-----|----------|
| 3 | ISSUED FOR APPROVAL | CFB | CFB | 14.10.09 |
| 2 | ISSUED FOR COORDINATION | TQD | CFB | 31.07.09 |
| 1 | ISSUED FOR COORDINATION | TQD | CFB | 25.05.09 |

| Rev. | Revision Description | By | App. | Date |
|------|----------------------|----|------|------|
|------|----------------------|----|------|------|

Structural & Civil Engineering Consultant



RobertBirdGroup

BRISBANE OFFICE:
Robert Bird Group Pty Ltd
PO Box 7035, Riverside Centre,
Brisbane, QLD 4001
Level 5, 333 Ann St
Brisbane QLD
Ph. (07) 3319 2777
Fax. (07) 3319 2799
ACN 010 580 248

Web Site: www.robertbird.com

Client
AEVUM LIMITED
Level 6, 23-35 O'Connell St, Sydney, NSW 2000
PH (02) 8223 0900
FAX (02) 8753 2222

Project
**CARDINAL FREEMAN VILLAGE
MASTERPLAN**

Title
**STORMWATER DRAINAGE PLAN
SHEET 3 OF 4**

| | | |
|----------------------------|----------------------------------|----------------------|
| Date 13.10.09 | Design C.Barlome | Checked |
| Scale @ A1 AS SHOWN | Drawn C.Waite | Approved |
| Job Number 09162 | Drawing Number C0-5-03 | Revision 3 |

Disclaimer: Robert Bird Group Pty Ltd (RBG) and its related entities (RBG) do not warrant the accuracy, currency, or completeness of any information or data they supply or transfer by electronic means. You are responsible for verifying that any information or data supplied or transferred by electronic means satisfies the information or data on the corresponding paper or other version issued by RBG. RBG shall not be liable for any loss or damage, however caused, which you or any other party may directly or indirectly suffer in connection with your access to or use of that information or data.

JOINS TO DRAWING C0-5-03



JOINS TO DRAWING C0-5-02

VICTORIA STREET

LEGEND

- PROPOSED STORMWATER LINE — SW —
- PROPOSED SEWER LINE — S —
- PROPOSED WATER MAIN — W —
- PROPOSED FIRE HYDRANT LINE — FH —
- PROPOSED GAS LINE — G —
- PROPOSED ELECTRICITY DISTRIBUTION LINE — E —
- PROPOSED UNDERGROUND TELECOMMUNICATION LINE — T —
- EXISTING STORMWATER LINE — SW —
- EXISTING SEWER LINE — S —
- EXISTING WATER MAIN — W —
- EXISTING TELSTRA LINE — T —
- EXISTING UECOMM FIBRE OPTIC CABLE — FO —
- EXISTING GAS LINE — G —
- EXISTING ELECTRICITY DISTRIBUTION LINE — E —
- EXISTING ELECTRICITY TRANSMISSION LINE — E —
- EXISTING OVERHEAD ELECTRICITY LINE — OH/E —

 
SCALE 1:250

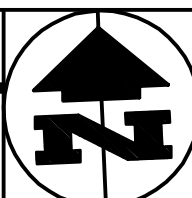

DO NOT SCALE DRAWINGS, USE FIGURED DIMENSIONS
REFER COVER SHEET FOR NOTES UNLESS NOTED OTHERWISE

FOR APPROVAL

KEYPLAN

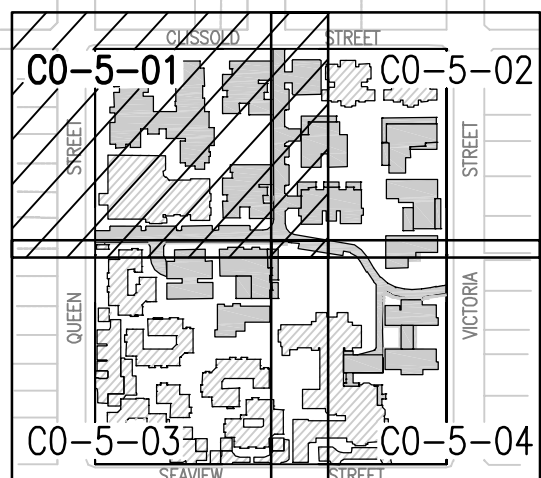

| | | | | |
|---|-------------------------|-----|-----|----------|
| 3 | ISSUED FOR APPROVAL | CFB | CFB | 14.10.09 |
| 2 | ISSUED FOR COORDINATION | TQD | CFB | 31.07.09 |
| 1 | ISSUED FOR COORDINATION | TQD | CFB | 25.05.09 |

| Rev. | Revision Description | By | App. | Date |
|------|----------------------|----|------|------|
|------|----------------------|----|------|------|

Structural & Civil Engineering Consultant



RobertBirdGroup

BRISBANE OFFICE:
Robert Bird Group Pty Ltd
PO Box 7035, Riverside Centre,
Brisbane, QLD 4001
Level 5, 333 Ann St
Brisbane QLD
Ph. (07) 3319 2777
Fax. (07) 3319 2799
ACN 010 580 248

Web Site: www.robertbird.com



Client
AEVUM LIMITED
Level 6, 23-35 O'Connell St, Sydney, NSW 2000
PH (02) 8223 0900
FAX (02) 8753 2222

Project
CARDINAL FREEMAN VILLAGE MASTERPLAN

Title
**STORMWATER DRAINAGE PLAN
SHEET 4 OF 4**

| | | |
|----------------------------|----------------------------------|----------------------|
| Date 31.07.09 | Design C.Bartolome | Checked |
| Scale AS SHOWN | Drawn C.Walke | Approved |
| Job Number 09162 | Drawing Number C0-5-04 | Revision 3 |


Disclaimer: Robert Bird Group Pty Ltd (RBG) and its related entities (RBG) do not warrant the accuracy, currency, or completeness of any information or data they supply or transfer by electronic means. You are responsible for verifying that any information or data supplied or transferred by electronic means satisfies the information in data on the corresponding paper or other version issued by RBG. Any liability for any loss or damage, however caused, which you or any other party may directly or indirectly suffer in connection with your access to or use of that information or data, is excluded.

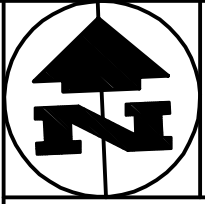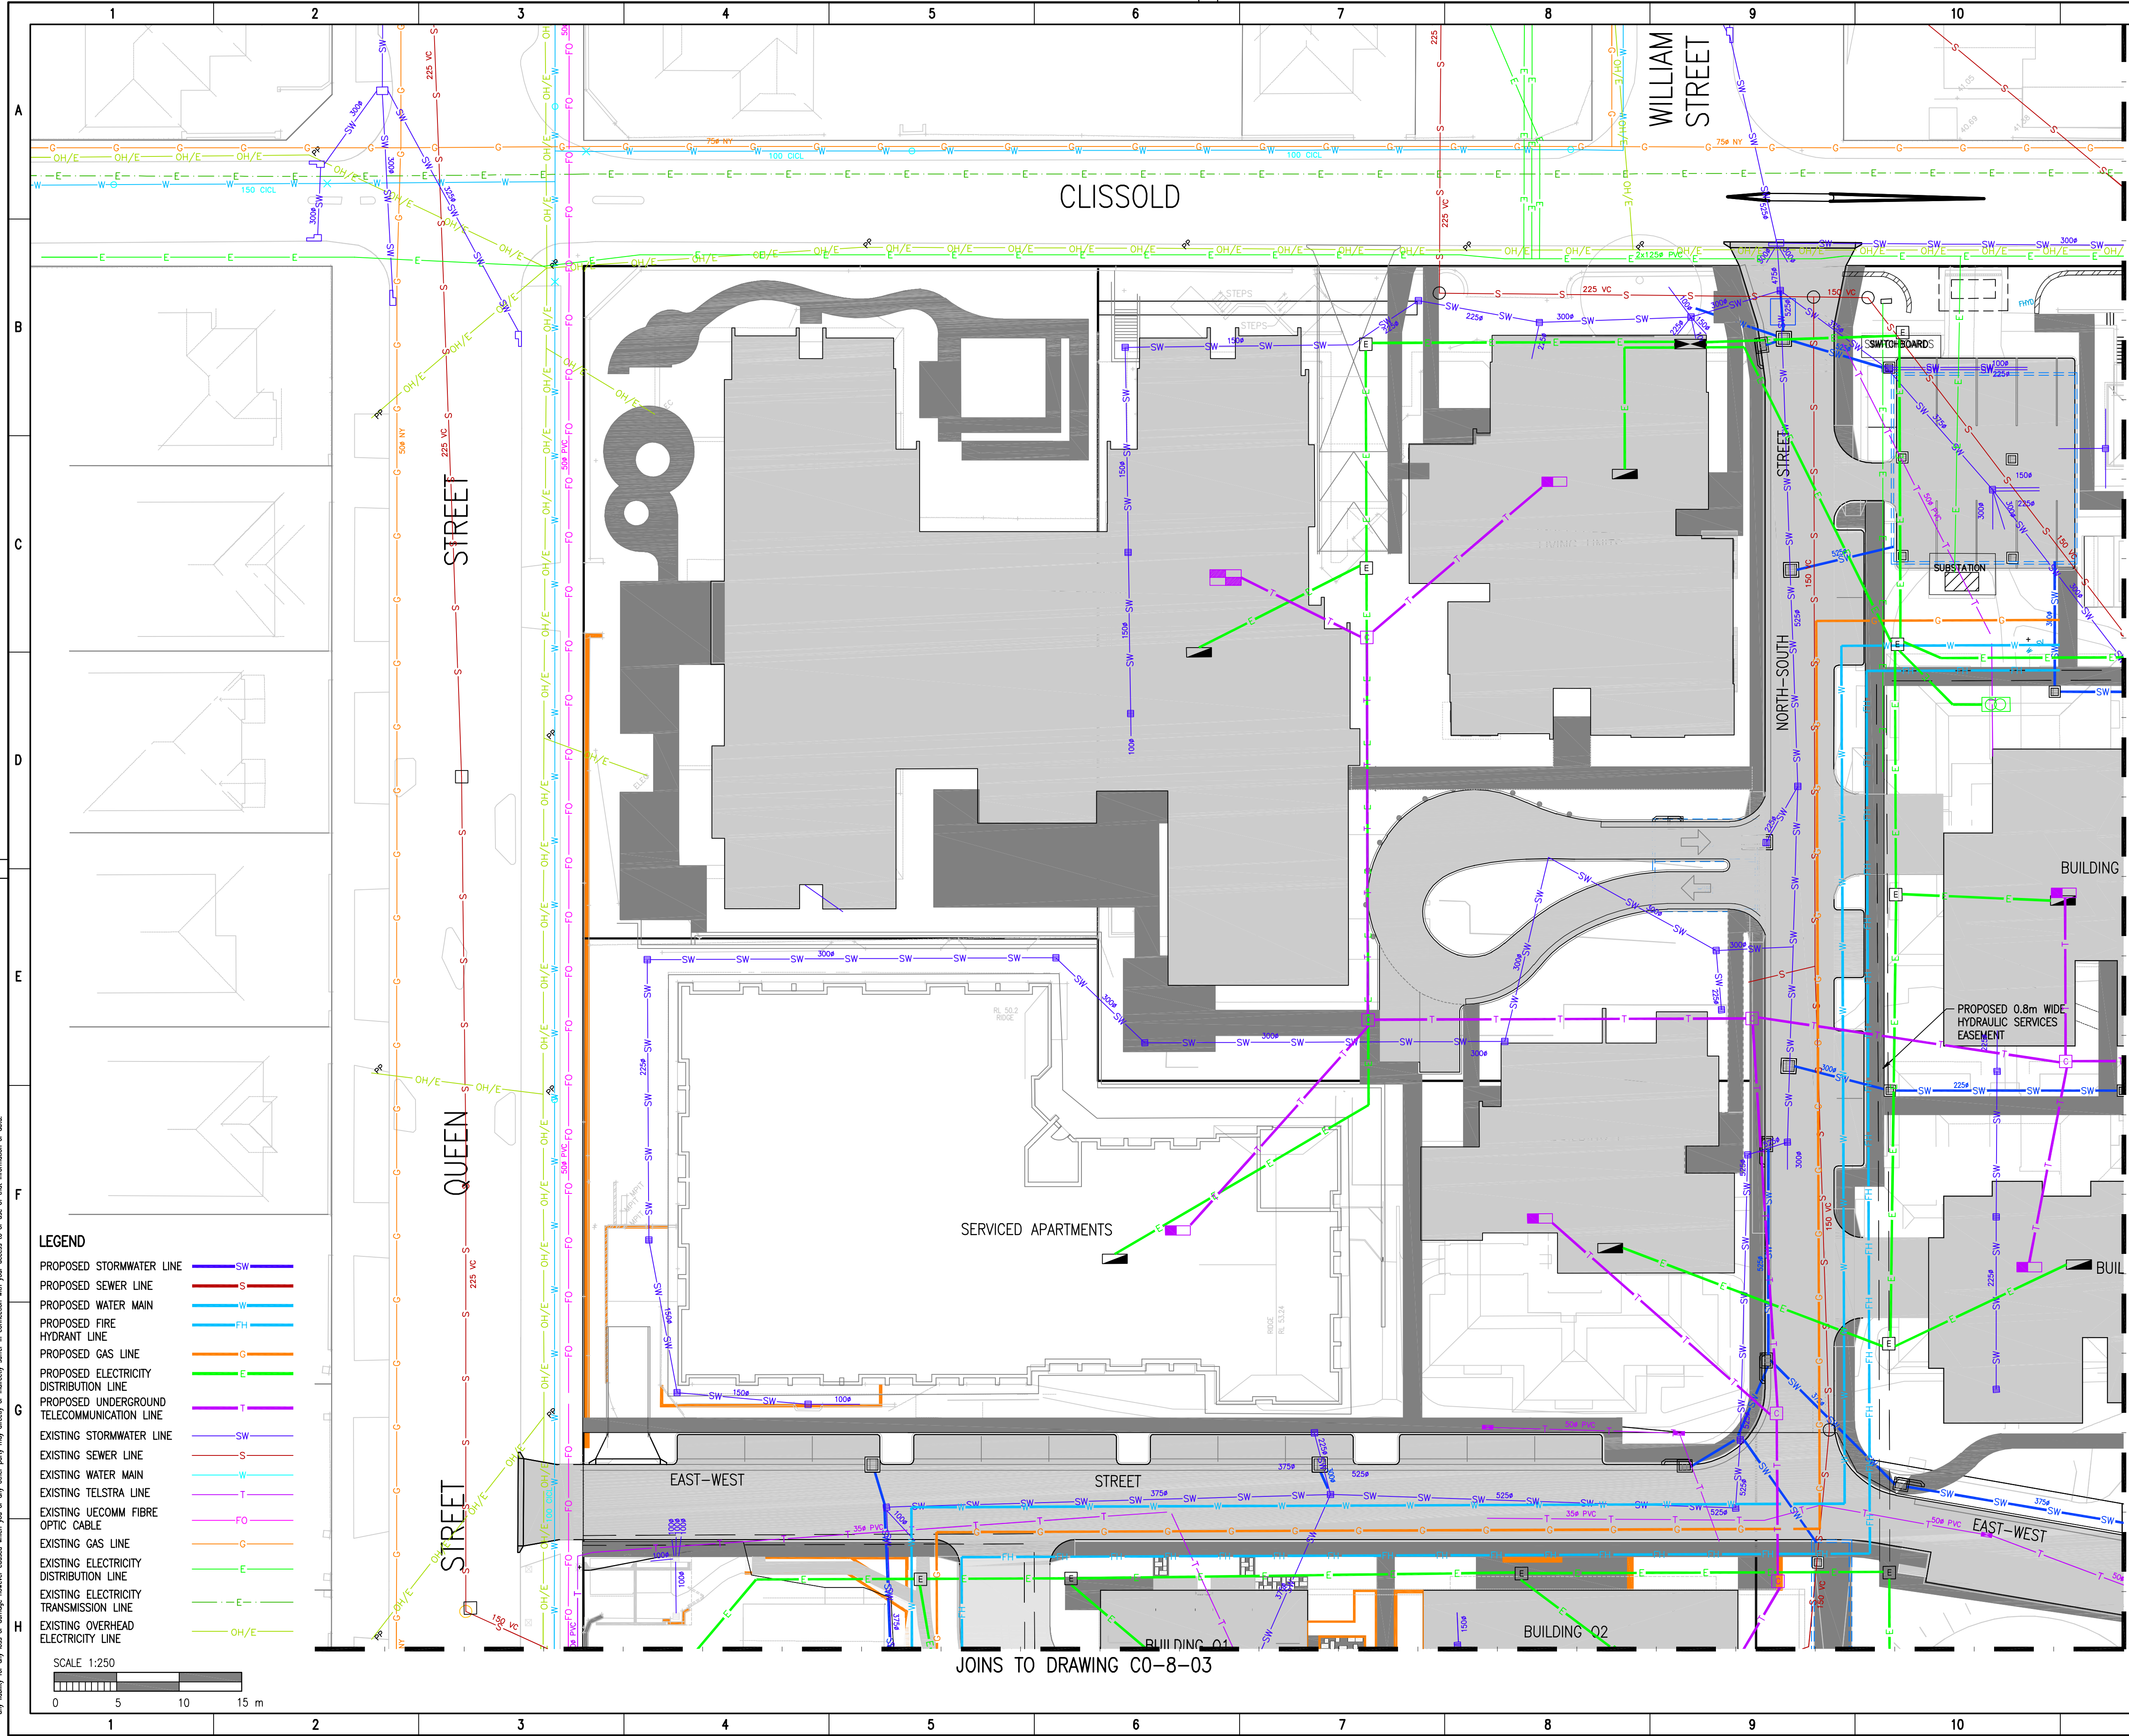

DO NOT SCALE DRAWINGS, USE FIGURED DIMENSIONS
REFER COVER SHEET FOR NOTES UNLESS NOTED OTHERWISE

FOR APPROVAL

KEYPLAN

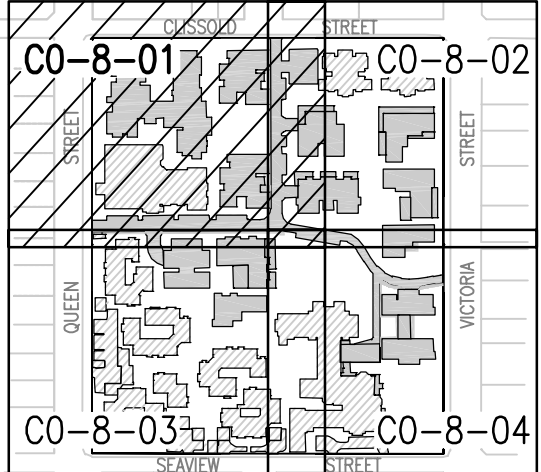

| | | | | |
|---|-------------------------|-----|-----|----------|
| 4 | ISSUED FOR APPROVAL | CFB | CFB | 14.10.09 |
| 3 | ISSUED FOR COORDINATION | TQD | CFB | 31.07.09 |
| 2 | ISSUED FOR COORDINATION | TQD | CFB | 25.05.09 |
| 1 | ISSUED FOR COORDINATION | OW | CB | 06.04.09 |

Rev. Revision Description By App. Date

Structural & Civil Engineering Consultant



RobertBirdGroup

Client
AEVUM LIMITED
Level 6, 23-35 O'Connell St, Sydney, NSW 2000
PH (02) 8223 0900
FAX (02) 8753 2222

Project
CARDINAL FREEMAN VILLAGE MASTERPLAN


Title
COMBINED SERVICES PLAN SHEET 1 OF 4

| | | |
|---------------------|---------------------------|---------------|
| Date 13.10.09 | Design C.Barlome | Checked |
| Scale AS SHOWN | Drawn C.Wate | Approved |
| Job Number 09162 | Drawing Number C0-8-01 | Revision 4 |


Disclaimer: Robert Bird Group Pty Ltd (RBG) and its related entities (RBG) do not warrant the accuracy, currency, or completeness of any information or data they supply or transfer by electronic means. You are responsible for verifying that any information or data supplied or transferred by electronic means satisfies the information or data on the corresponding PDF or other version issued by RBG. RBG shall not be liable for any loss or damage, however caused, which you or any other party may directly or indirectly suffer in connection with your access to or use of that information or data.

JOINS TO DRAWING C0-8-01

JOINS TO DRAWING C0-8-04

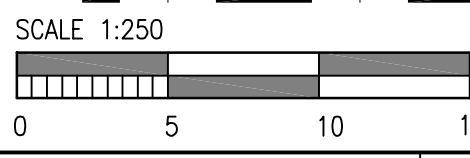

- LEGEND**
- PROPOSED STORMWATER LINE
 - PROPOSED SEWER LINE
 - PROPOSED WATER MAIN
 - PROPOSED FIRE HYDRANT LINE
 - PROPOSED GAS LINE
 - PROPOSED ELECTRICITY DISTRIBUTION LINE
 - PROPOSED UNDERGROUND TELECOMMUNICATION LINE
 - EXISTING STORMWATER LINE
 - EXISTING SEWER LINE
 - EXISTING WATER MAIN
 - EXISTING TELSTRA LINE
 - EXISTING UECOMM FIBRE OPTIC CABLE
 - EXISTING GAS LINE
 - EXISTING ELECTRICITY DISTRIBUTION LINE
 - EXISTING ELECTRICITY TRANSMISSION LINE
 - EXISTING OVERHEAD ELECTRICITY LINE

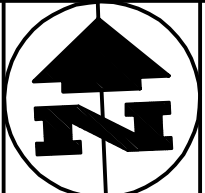


Unless agreed otherwise by Robert Bird Group Pty Ltd (RBG) and its related entities (RBG) in writing, intellectual property rights in any information or data supplied or transferred to you (including copyright in all text, graphics, logos, icons, sound recordings and software) are owned by, or licensed to, RBG. Other than for purposes authorised by RBG in writing, you must not copy, adapt, reproduce, store, publish or commercialise any information or data supplied or transferred by electronic means without RBG's prior written permission. © Robert Bird Group Pty Ltd 2009

DO NOT SCALE DRAWINGS, USE FIGURED DIMENSIONS
REFER COVER SHEET FOR NOTES UNLESS NOTED OTHERWISE

FOR APPROVAL

KEYPLAN

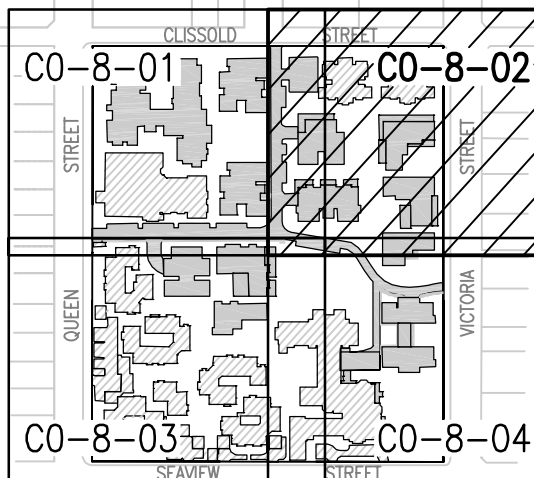

| | | | | |
|---|-------------------------|-----|-----|----------|
| 3 | ISSUED FOR APPROVAL | CFB | CFB | 14.10.09 |
| 2 | ISSUED FOR COORDINATION | TQD | CFB | 31.07.09 |
| 1 | ISSUED FOR COORDINATION | TQD | CFB | 25.06.09 |

| Rev. | Revision Description | By | App. | Date |
|------|----------------------|----|------|------|
|------|----------------------|----|------|------|

Structural & Civil Engineering Consultant



RobertBirdGroup

BRISBANE OFFICE:
Robert Bird Group Pty Ltd
PO Box 7035, Riverside Centre,
Brisbane, QLD 4001
Level 5, 333 Ann St
Brisbane QLD
Ph: (07) 3319 2777
Fax: (07) 3319 2799
ACN: 010 580 348

Web Site: www.robertbird.com

Client
AEVUM LIMITED
Level 6, 23-35 O'Connell St, Sydney, NSW 2000
PH (02) 8223 0900
FAX (02) 8753 2222

Project
**CARDINAL FREEMAN VILLAGE
MASTERPLAN**

Title
**COMBINED SERVICES PLAN
SHEET 2 OF 4**


| | | |
|---------------------|---------------------------|---------------|
| Date 13.10.09 | Design C.Bartolome | Checked |
| Scale AS SHOWN | Drawn C.Waite | Approved |
| Job Number 09162 | Drawing Number C0-8-02 | Revision 3 |

Disclaimer: Robert Bird Group Pty Ltd (RBG) and its related entities (RBG) do not warrant the accuracy, currency, or completeness of any information or data they supply or transfer by electronic means. You are responsible for verifying that any information or data supplied or transferred by electronic means satisfies the information or data in the corresponding PDF or other version issued by RBG. RBG shall not be liable for any loss or damage, however caused, which you or any other party may directly or indirectly suffer in connection with your access to or use of that information or data.

LEGEND


- PROPOSED STORMWATER LINE
- PROPOSED SEWER LINE
- PROPOSED WATER MAIN
- PROPOSED FIRE HYDRANT LINE
- PROPOSED GAS LINE
- PROPOSED ELECTRICITY DISTRIBUTION LINE
- PROPOSED UNDERGROUND TELECOMMUNICATION LINE
- EXISTING STORMWATER LINE
- EXISTING SEWER LINE
- EXISTING WATER MAIN
- EXISTING TELSTRA LINE
- EXISTING UECOMM FIBRE OPTIC CABLE
- EXISTING GAS LINE
- EXISTING ELECTRICITY DISTRIBUTION LINE
- EXISTING ELECTRICITY TRANSMISSION LINE
- EXISTING OVERHEAD ELECTRICITY LINE

 SCALE 1:250



JOINS TO DRAWING C0-8-01


SEAVIEW

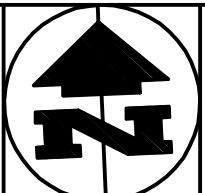

DO NOT SCALE DRAWINGS, USE FIGURED DIMENSIONS
REFER COVER SHEET FOR NOTES UNLESS NOTED OTHERWISE

FOR APPROVAL

KEYPLAN

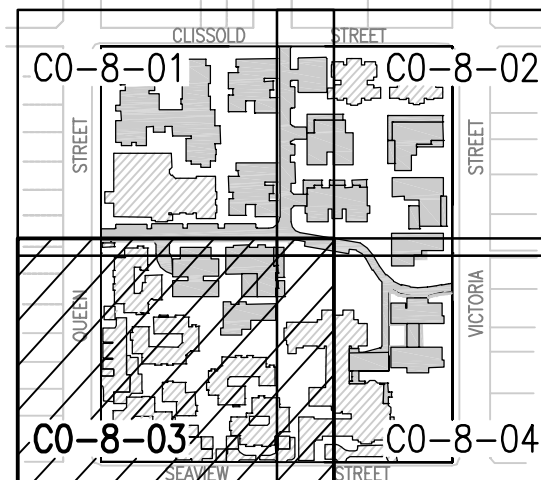

| | | | | |
|---|-------------------------|-----|-----|----------|
| 3 | ISSUED FOR APPROVAL | CFB | CFB | 14.10.09 |
| 2 | ISSUED FOR COORDINATION | TQD | CFB | 31.07.09 |
| 1 | ISSUED FOR COORDINATION | TQD | CFB | 25.05.09 |

| Rev. | Revision Description | By | App. | Date |
|------|----------------------|----|------|------|
|------|----------------------|----|------|------|

Structural & Civil Engineering Consultant



RobertBirdGroup

Client
AEVUM LIMITED
Level 6, 23-35 O'Connell St, Sydney, NSW 2000
PH (02) 8223 0900
FAX (02) 8753 2222


Project
CARDINAL FREEMAN VILLAGE MASTERPLAN

Title
**COMBINED SERVICES PLAN
SHEET 3 OF 4**

| | | |
|----------------------------|----------------------------------|----------------------|
| Date 13.10.09 | Design C.Bartolome | Checked |
| Scale @ A1 AS SHOWN | Drawn C.Wate | Approved |
| Job Number 09162 | Drawing Number C0-8-03 | Revision 3 |

Disclaimer: Robert Bird Group Pty Ltd (RBG) and its related entities (RBG) do not warrant the accuracy, currency, or completeness of any information or data they supply or transfer by electronic means. You are responsible for verifying that any information or data supplied or transferred by electronic means satisfies the information or data in the corresponding PDF or other version issued by RBG. RBG shall not be liable for any loss or damage, however caused, which you or any other party may directly or indirectly suffer in connection with your access to or use of that information or data.

A1

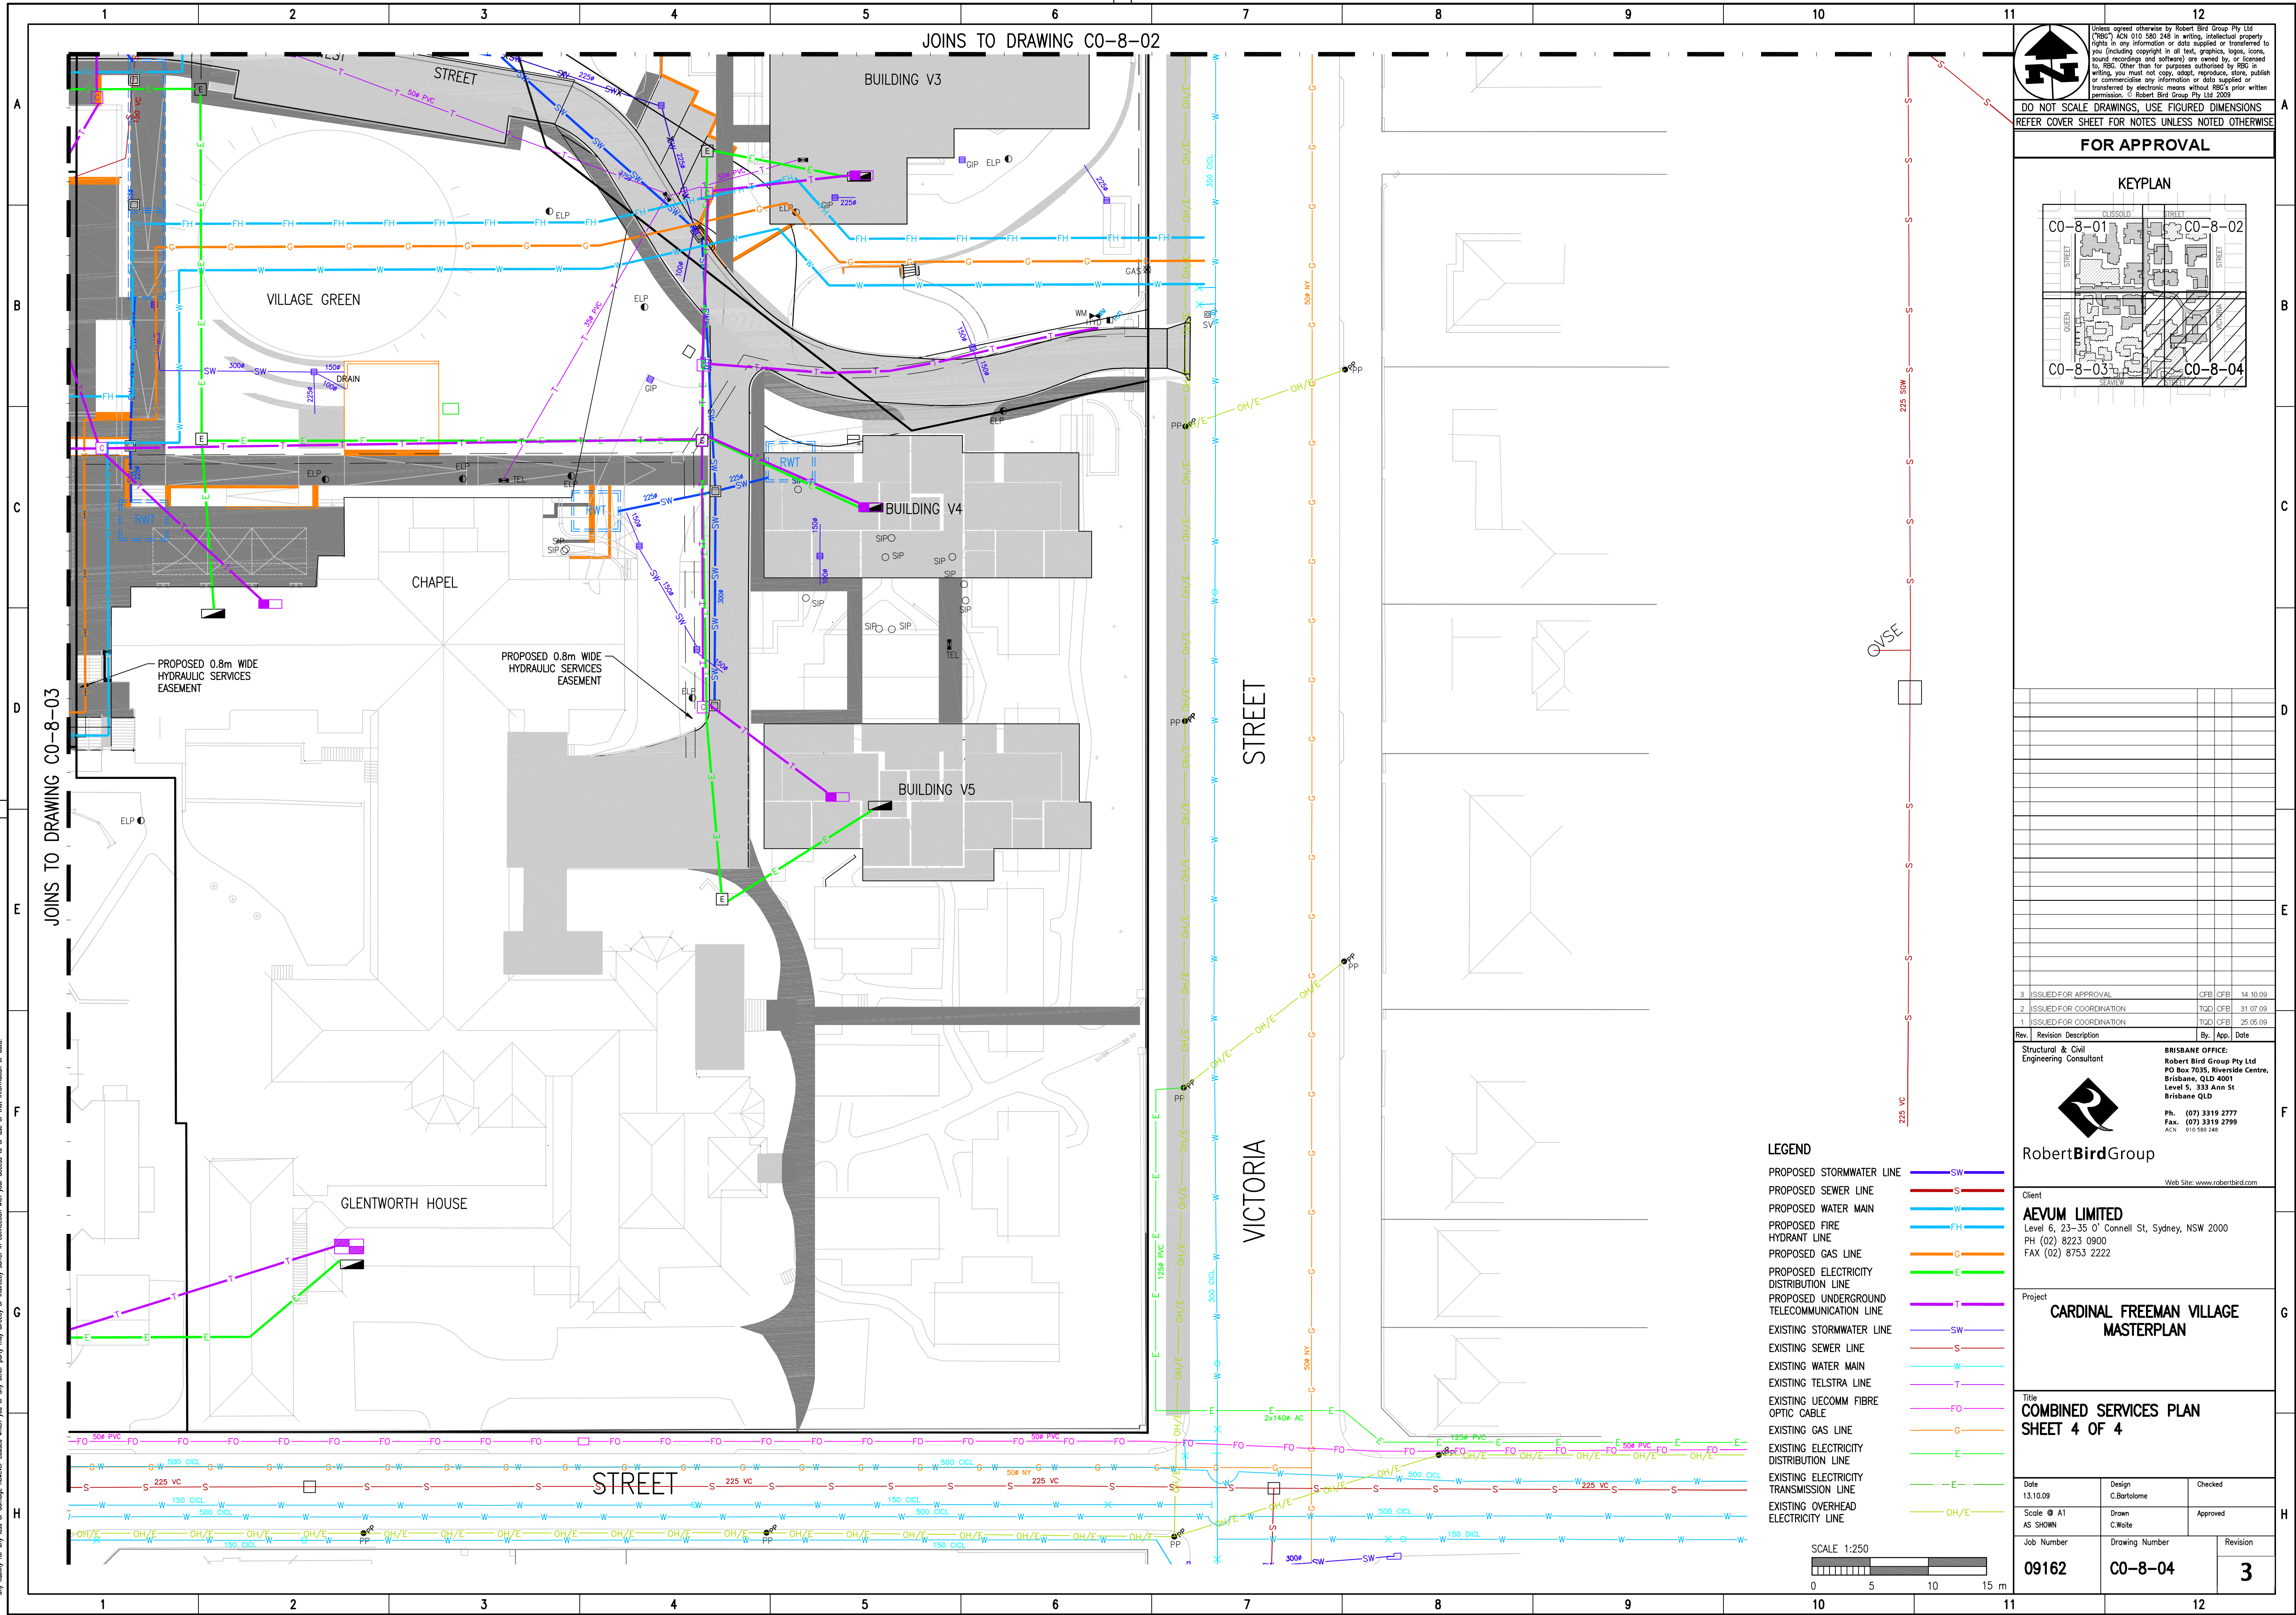


CARDINAL FREEMAN VILLAGE
CARE PRECINCT
Clissold Street, Ashfield
CIVIL WORKS DRAWINGS

| Sheet List Table | |
|------------------|--|
| Sheet No. | Sheet Title |
| C1-0-00 | COVER SHEET AND DRAWING LIST – CARE PRECINCT |
| C1-0-05 | STORMWATER DRAINAGE CONCEPT PLAN – CARE PRECINCT |
| C1-0-10 | CIVIL WORKS DETAILS |
| C1-1-01 | EROSION AND SEDIMENT CONTROL PLAN AND DETAILS |
| C1-5-10 | STORMWATER WORKS DETAILS |
| C1-5-15 | ON SITE DETENTION TANK DETAILS |


[illegible]

Disclaimer: Robert Bird Group Pty Ltd (RBG) and its related entities (RBG) do not warrant the accuracy, currency, or completeness of any information or data they supply or transfer by electronic means. You are responsible for verifying that any information or data supplied or transferred by electronic means is correct and for its use. RBG shall not be liable for any loss or damage, however caused, which you or any other party may directly or indirectly suffer in connection with your access to or use of that information or data.

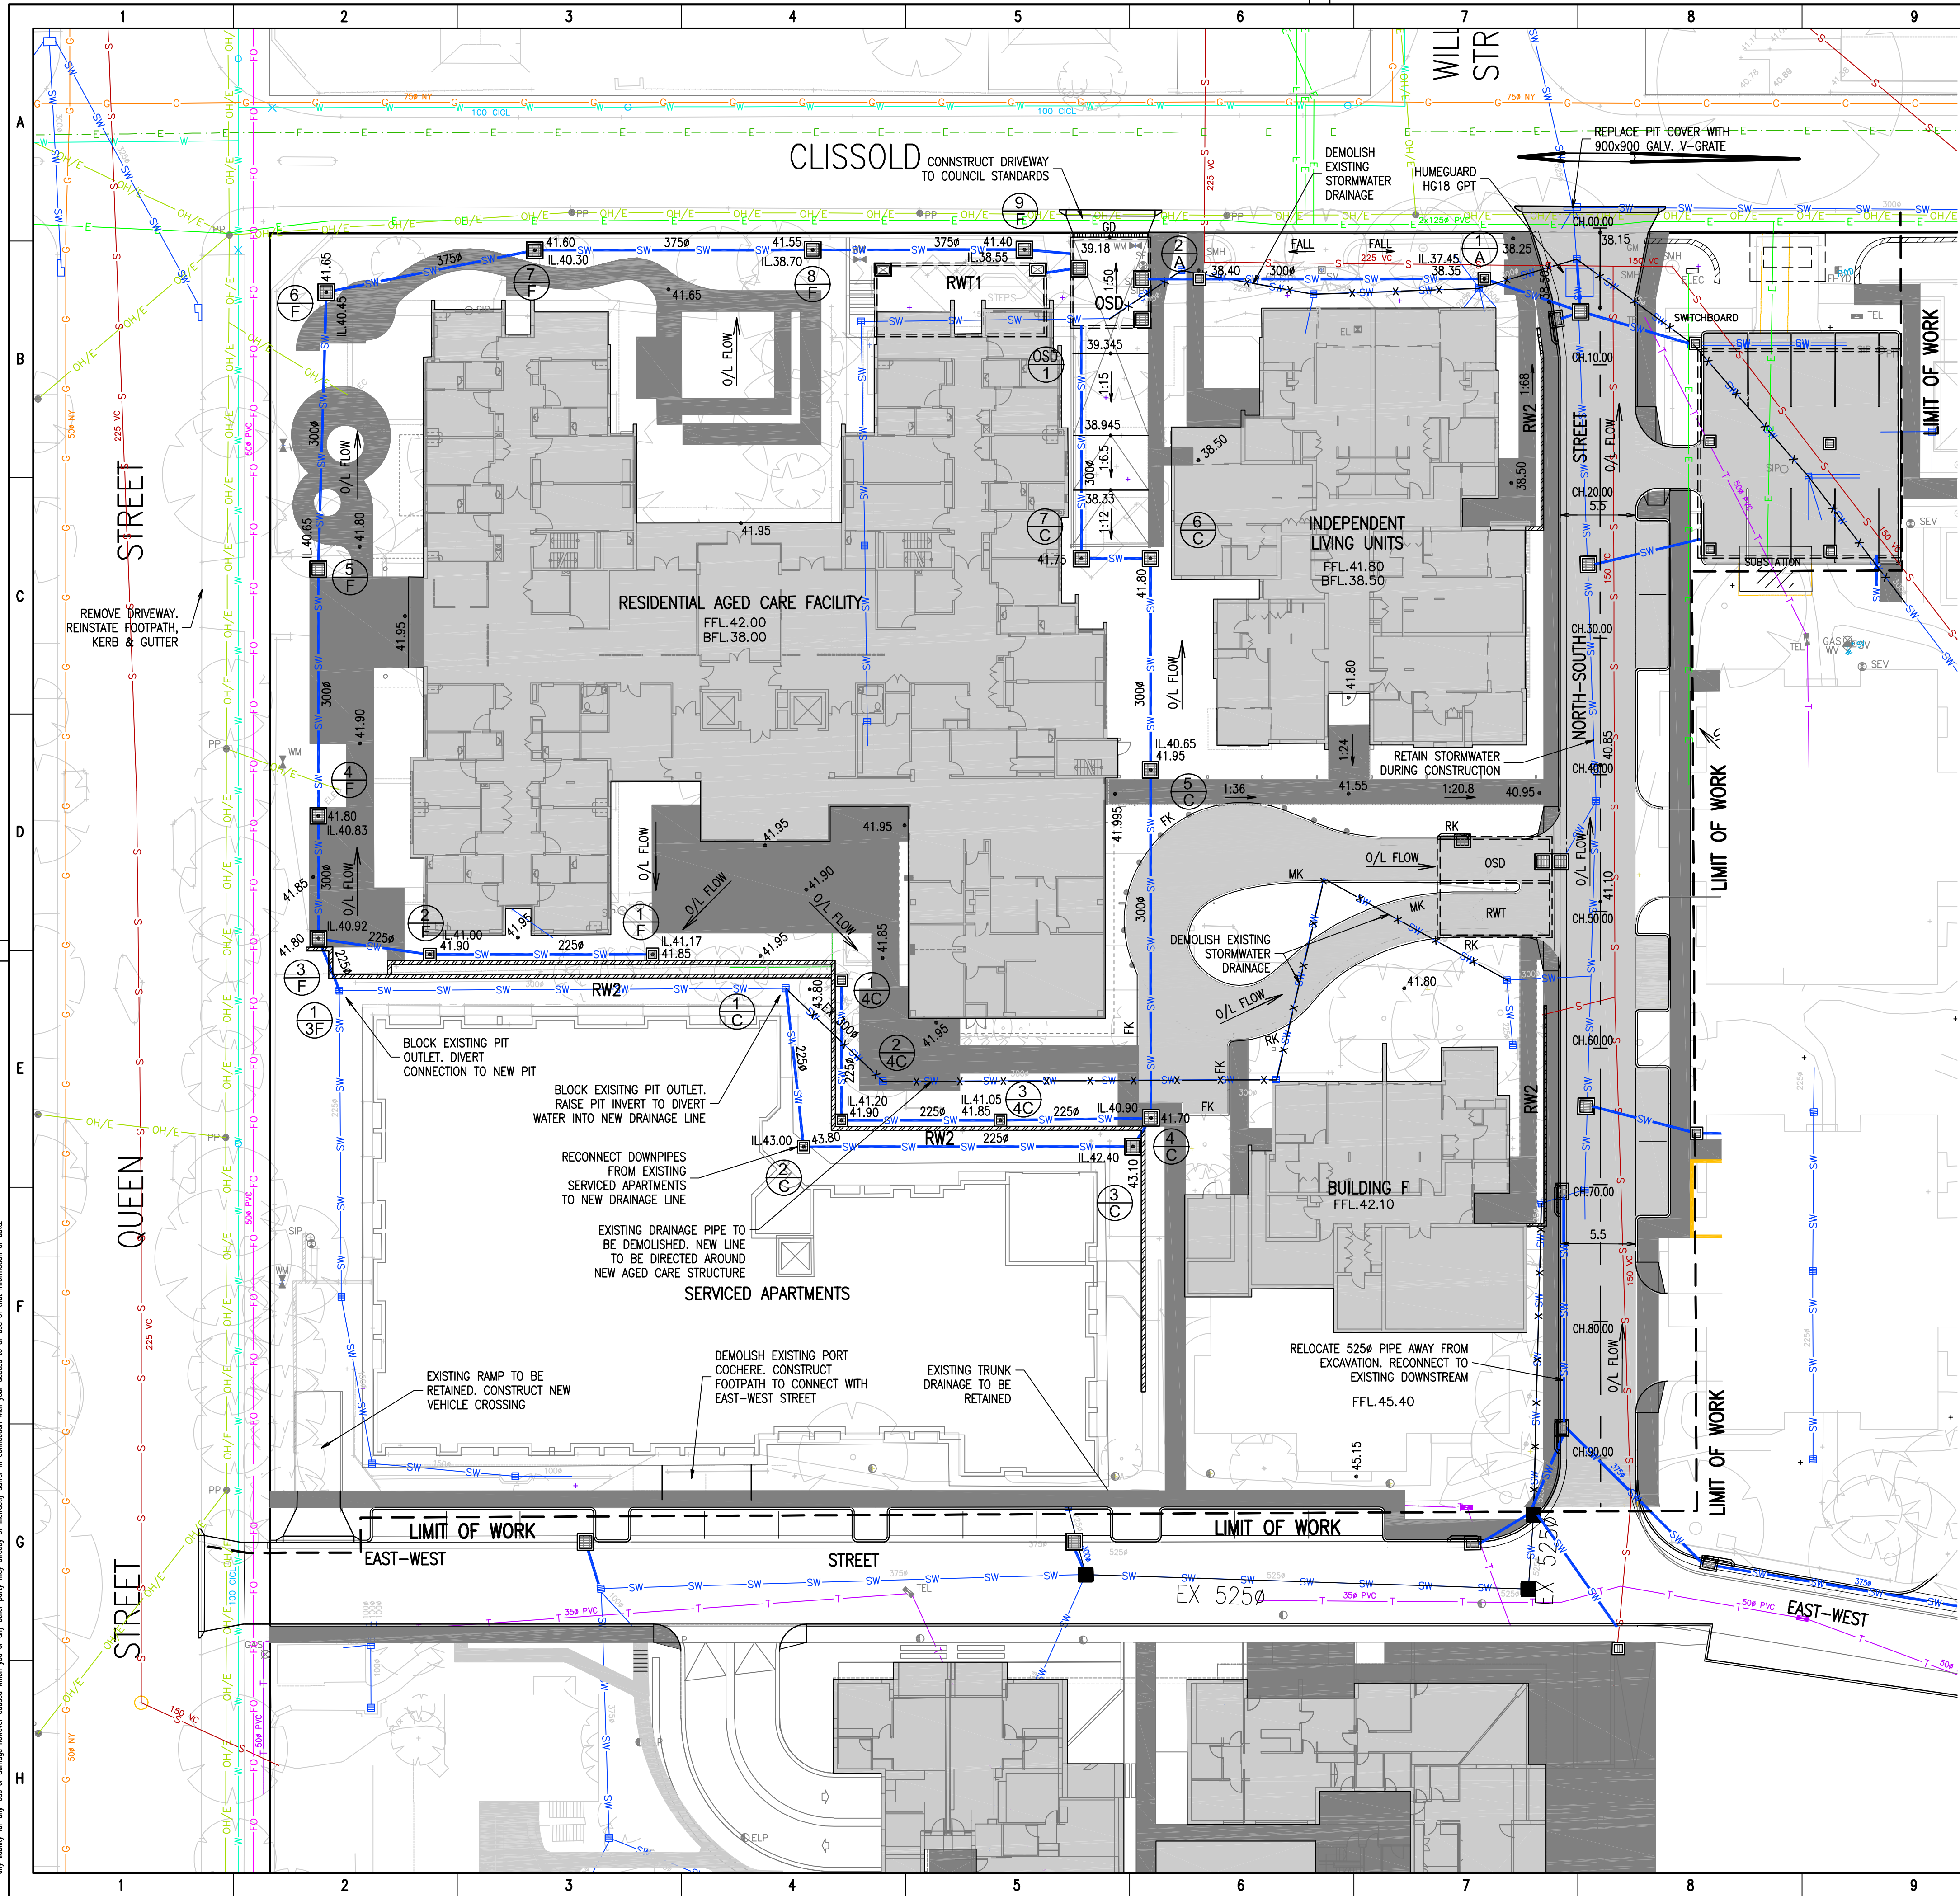


LEGEND

| | |
|---|------------|
| PROPOSED STORMWATER LINE | SW |
| PROPOSED SEWER LINE | S |
| PROPOSED WATER MAIN | W |
| PROPOSED FIRE HYDRANT LINE | FH |
| PROPOSED GAS LINE | G |
| PROPOSED ELECTRICITY DISTRIBUTION LINE | T |
| PROPOSED UNDERGROUND TELECOMMUNICATION LINE | FO |
| EXISTING STORMWATER LINE | SW |
| EXISTING SEWER LINE | S |
| EXISTING WATER MAIN | W |
| EXISTING TELSTRA LINE | T |
| EXISTING UECOMM FIBRE OPTIC CABLE | FO |
| EXISTING GAS LINE | G |
| EXISTING ELECTRICITY DISTRIBUTION LINE | T |
| EXISTING ELECTRICITY TRANSMISSION LINE | T |
| EXISTING OVERHEAD ELECTRICITY LINE | OH/E |
| PROPOSED OSD/RAINWATER TANK | OSD/RWT |
| PROPOSED OVERLAND FLOW PATH | O/L FLOW |
| PROPOSED FINISHED LEVEL | 45.00 |
| PROPOSED GRADE | 1:20 5% |
| FLUSH KERB | FK |
| ROLL KERB | RK |
| STORMWATER PIT & PIT NUMBER | 2/A |
| PROPOSED GRATED TRENCH DRAIN | GD |
| PROPOSED DISH DRAIN | DD |
| PROPOSED KERB & GUTTER | K&G |
| PROPOSED KERB ONLY | KO |
| PROPOSED MEDIAN KERB | MK |

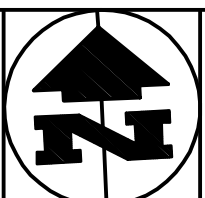

DO NOT SCALE DRAWINGS, USE FIGURED DIMENSIONS
REFER COVER SHEET FOR NOTES UNLESS NOTED OTHERWISE

FOR APPROVAL

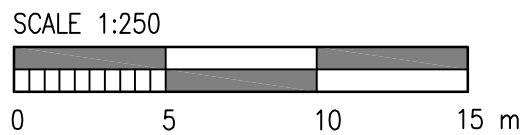

| | | | | |
|---|-------------------------|-----|-----|----------|
| 4 | ISSUED FOR APPROVAL | CFB | CFB | 14.10.09 |
| 3 | ISSUED FOR COORDINATION | QTD | CFB | 29.07.09 |
| 2 | ISSUED FOR COORDINATION | CW | CB | 06.04.09 |
| 1 | ISSUED FOR COORDINATION | CW | CB | 17.03.09 |

| Rev. | Revision Description | By | App. | Date |
|------|----------------------|----|------|------|
|------|----------------------|----|------|------|

Structural & Civil Engineering Consultant



RobertBirdGroup

Client
AEVUM LIMITED
Level 6, 23-35 O'Connell St, Sydney, NSW 2000
PH (02) 8223 0900
FAX (02) 8753 2222

Project
CARDINAL FREEMAN VILLAGE CARE PRECINCT

Title
STORMWATER DRAINAGE CONCEPT PLAN - CARE PRECINCT

| | | |
|----------------------------|----------------------------------|----------------------|
| Date 13.10.09 | Design CFB | Checked |
| Scale A1 1:250 | Drawn CPW | Approved |
| Job Number 09162 | Drawing Number C1-0-05 | Revision 4 |

DESIGN NOTE:

- RAINWATER TANK RW1:**
DIMENSIONS : (5.0Wx12.2Lx2.0D)m
VOLUME : 118m³
- RAINWATER TANK RW2:**
DIMENSIONS : (4.8Wx8.0Lx1.8D)m
VOLUME : 66m³
- ON SITE DETENTION TANK OSD:**
DIMENSIONS : (5.5Wx6.25Lx1.2D)m
VOLUME : 41.2m³