



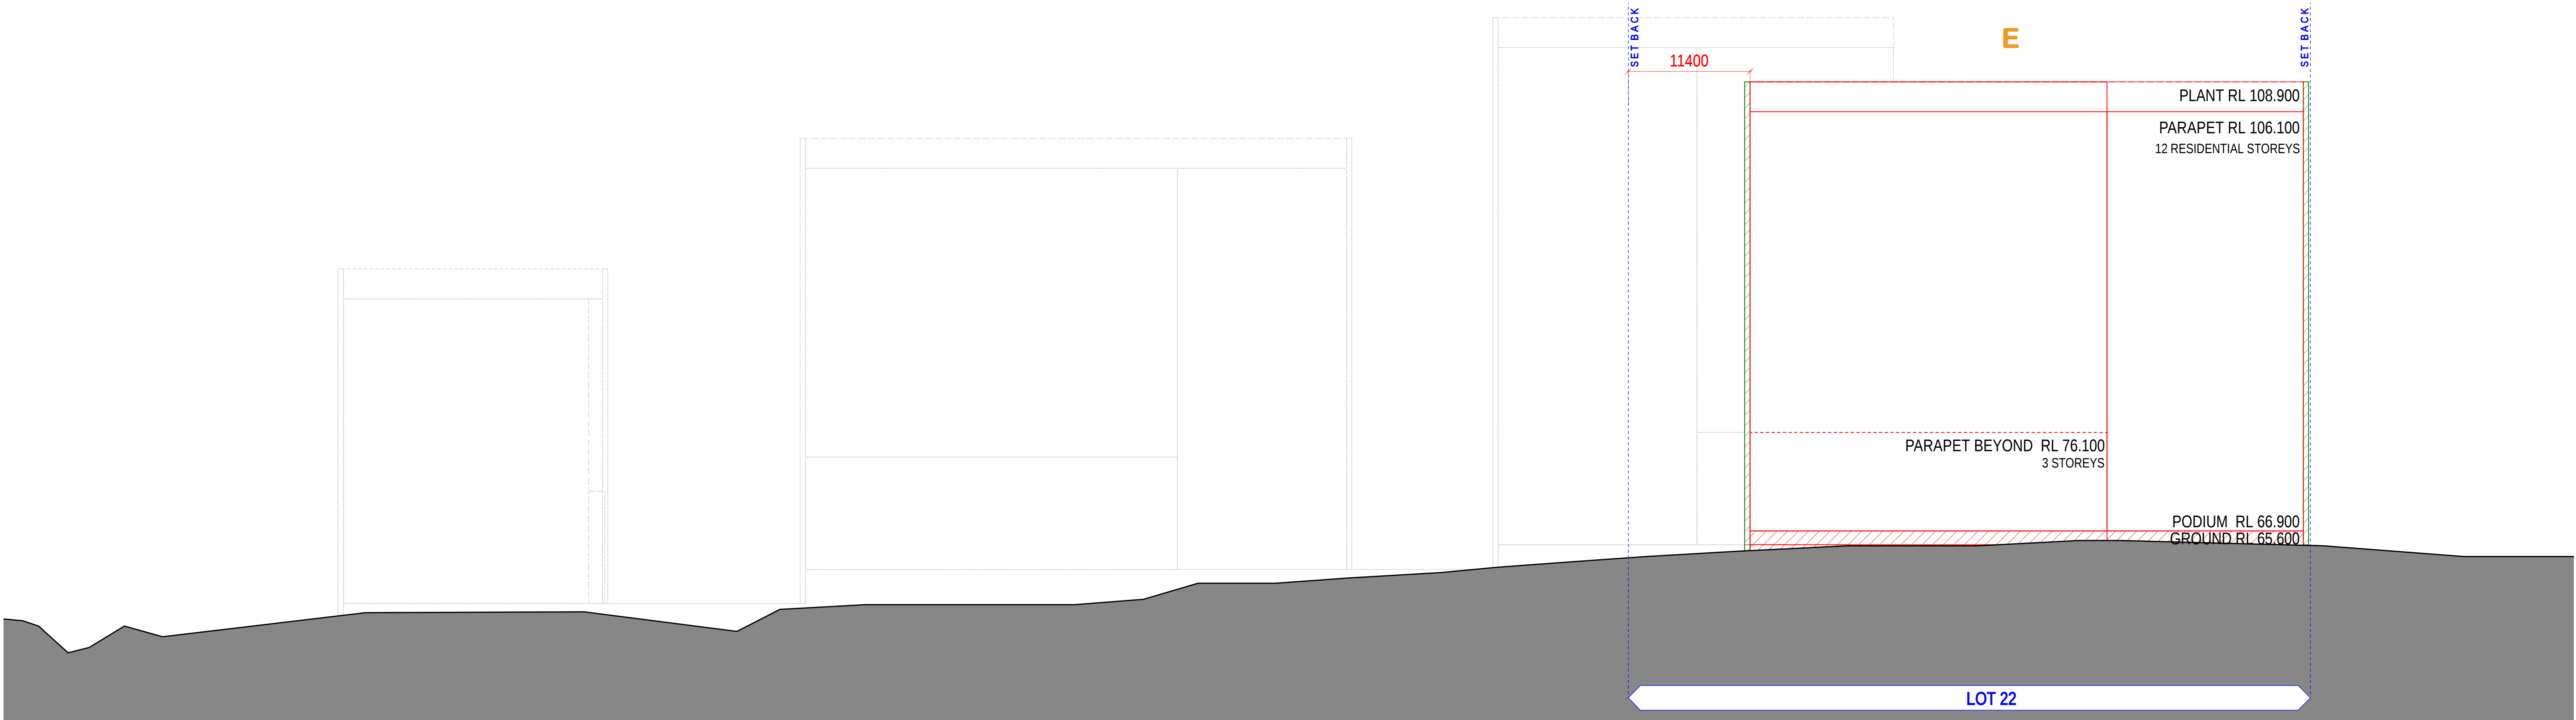

URBAN FORM CONTROL DIAGRAM _ SOUTH ELEVATION

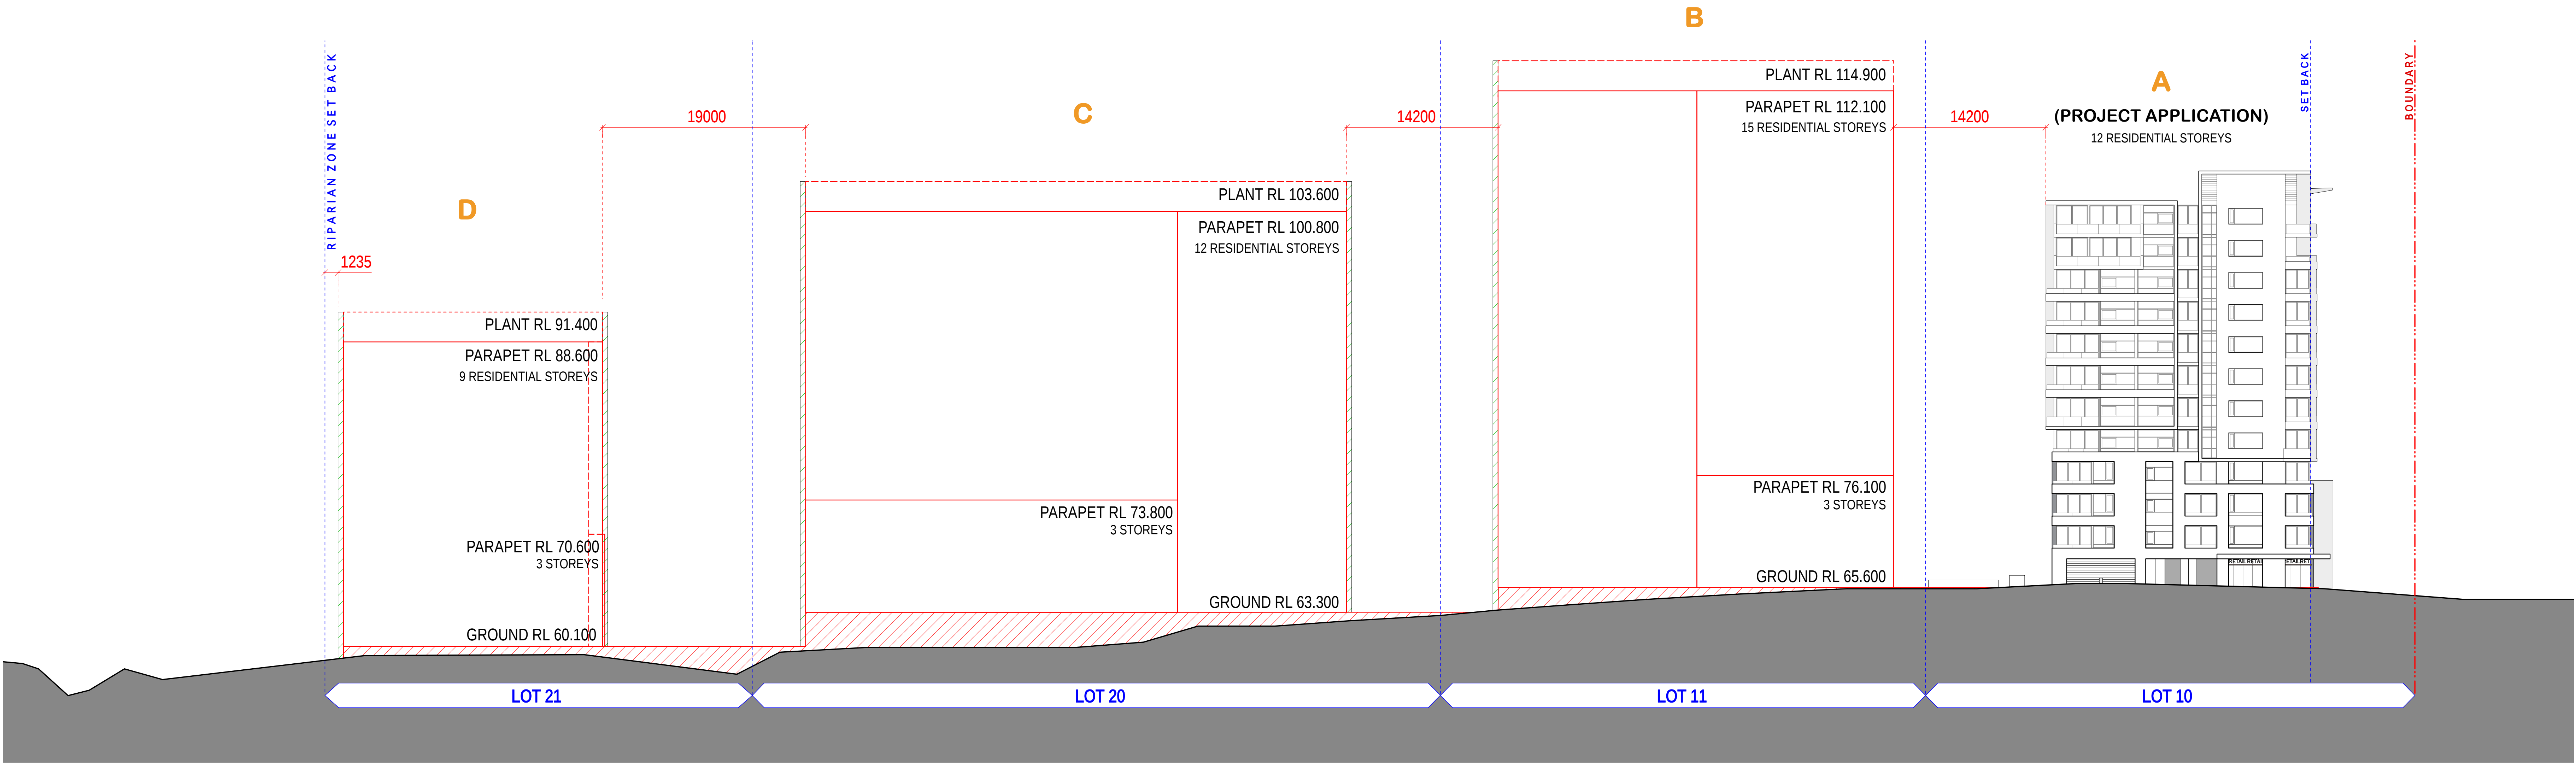

URBAN FORM CONTROL DIAGRAM _ ELEVATION ALONG HERRING ROAD

--- SITE BOUNDARY
--- STAGE BOUNDARY
/// GROUND LINE PODIUM PROFILE
--- PREDOMINANT FACADE LINE
/// ZONE FOR RE ENTRANT BALCONIES, 2.5 m DEEP
/// ZONE FOR SAILIENT BALCONIES, 0.5 m DEEP

NOTES
THIS DRAWING IS COPYRIGHT © AND SHALL REMAIN THE PROPERTY OF TURNER + ASSOCIATES ARCHITECTS. NO REPRODUCTION, WITHOUT PERMISSION, IN ANY FORM OR BY ANY MEANS, IS PERMITTED. THIS DRAWING IS NOT FOR CONSTRUCTION. DO NOT SCALE FROM DRAWING. DIMENSIONS SHALL TAKE PRECEDENCE.

CLIENT
LIPMAN PROPERTIES PTY LTD
LEVEL 6, 66 BERRY STRET, NORTH SYDNEY
T 02 9955 7000 F 02 9955 3166

LIPMAN
the obvious choice
in property

PROJECT TITLE
RESIDENTIAL DEVELOPMENT
128 HERRING ROAD, MACQUARIE PARK
DRAWING TITLE
Urban Form Control Diagram, Elevations
CONCEPT PLAN

D	25/02	kgf	General update
C	30/02	kgf	General update
B	25/02	kgf	General update
A	25/02	kgf	Concept Plan Submission
Rev	Date	Approved by	Revision Notes
SCALE	1:250 @ B1, 40% @ A3	JOB No.	09047
FOR INFORMATION		DWG No.	A 162
		REV	D
TURNER + ASSOCIATES L1 410 Crown Street Surry Hills NSW 2010 Australia t +61 2 8668 0000 f +61 2 8668 0088			