


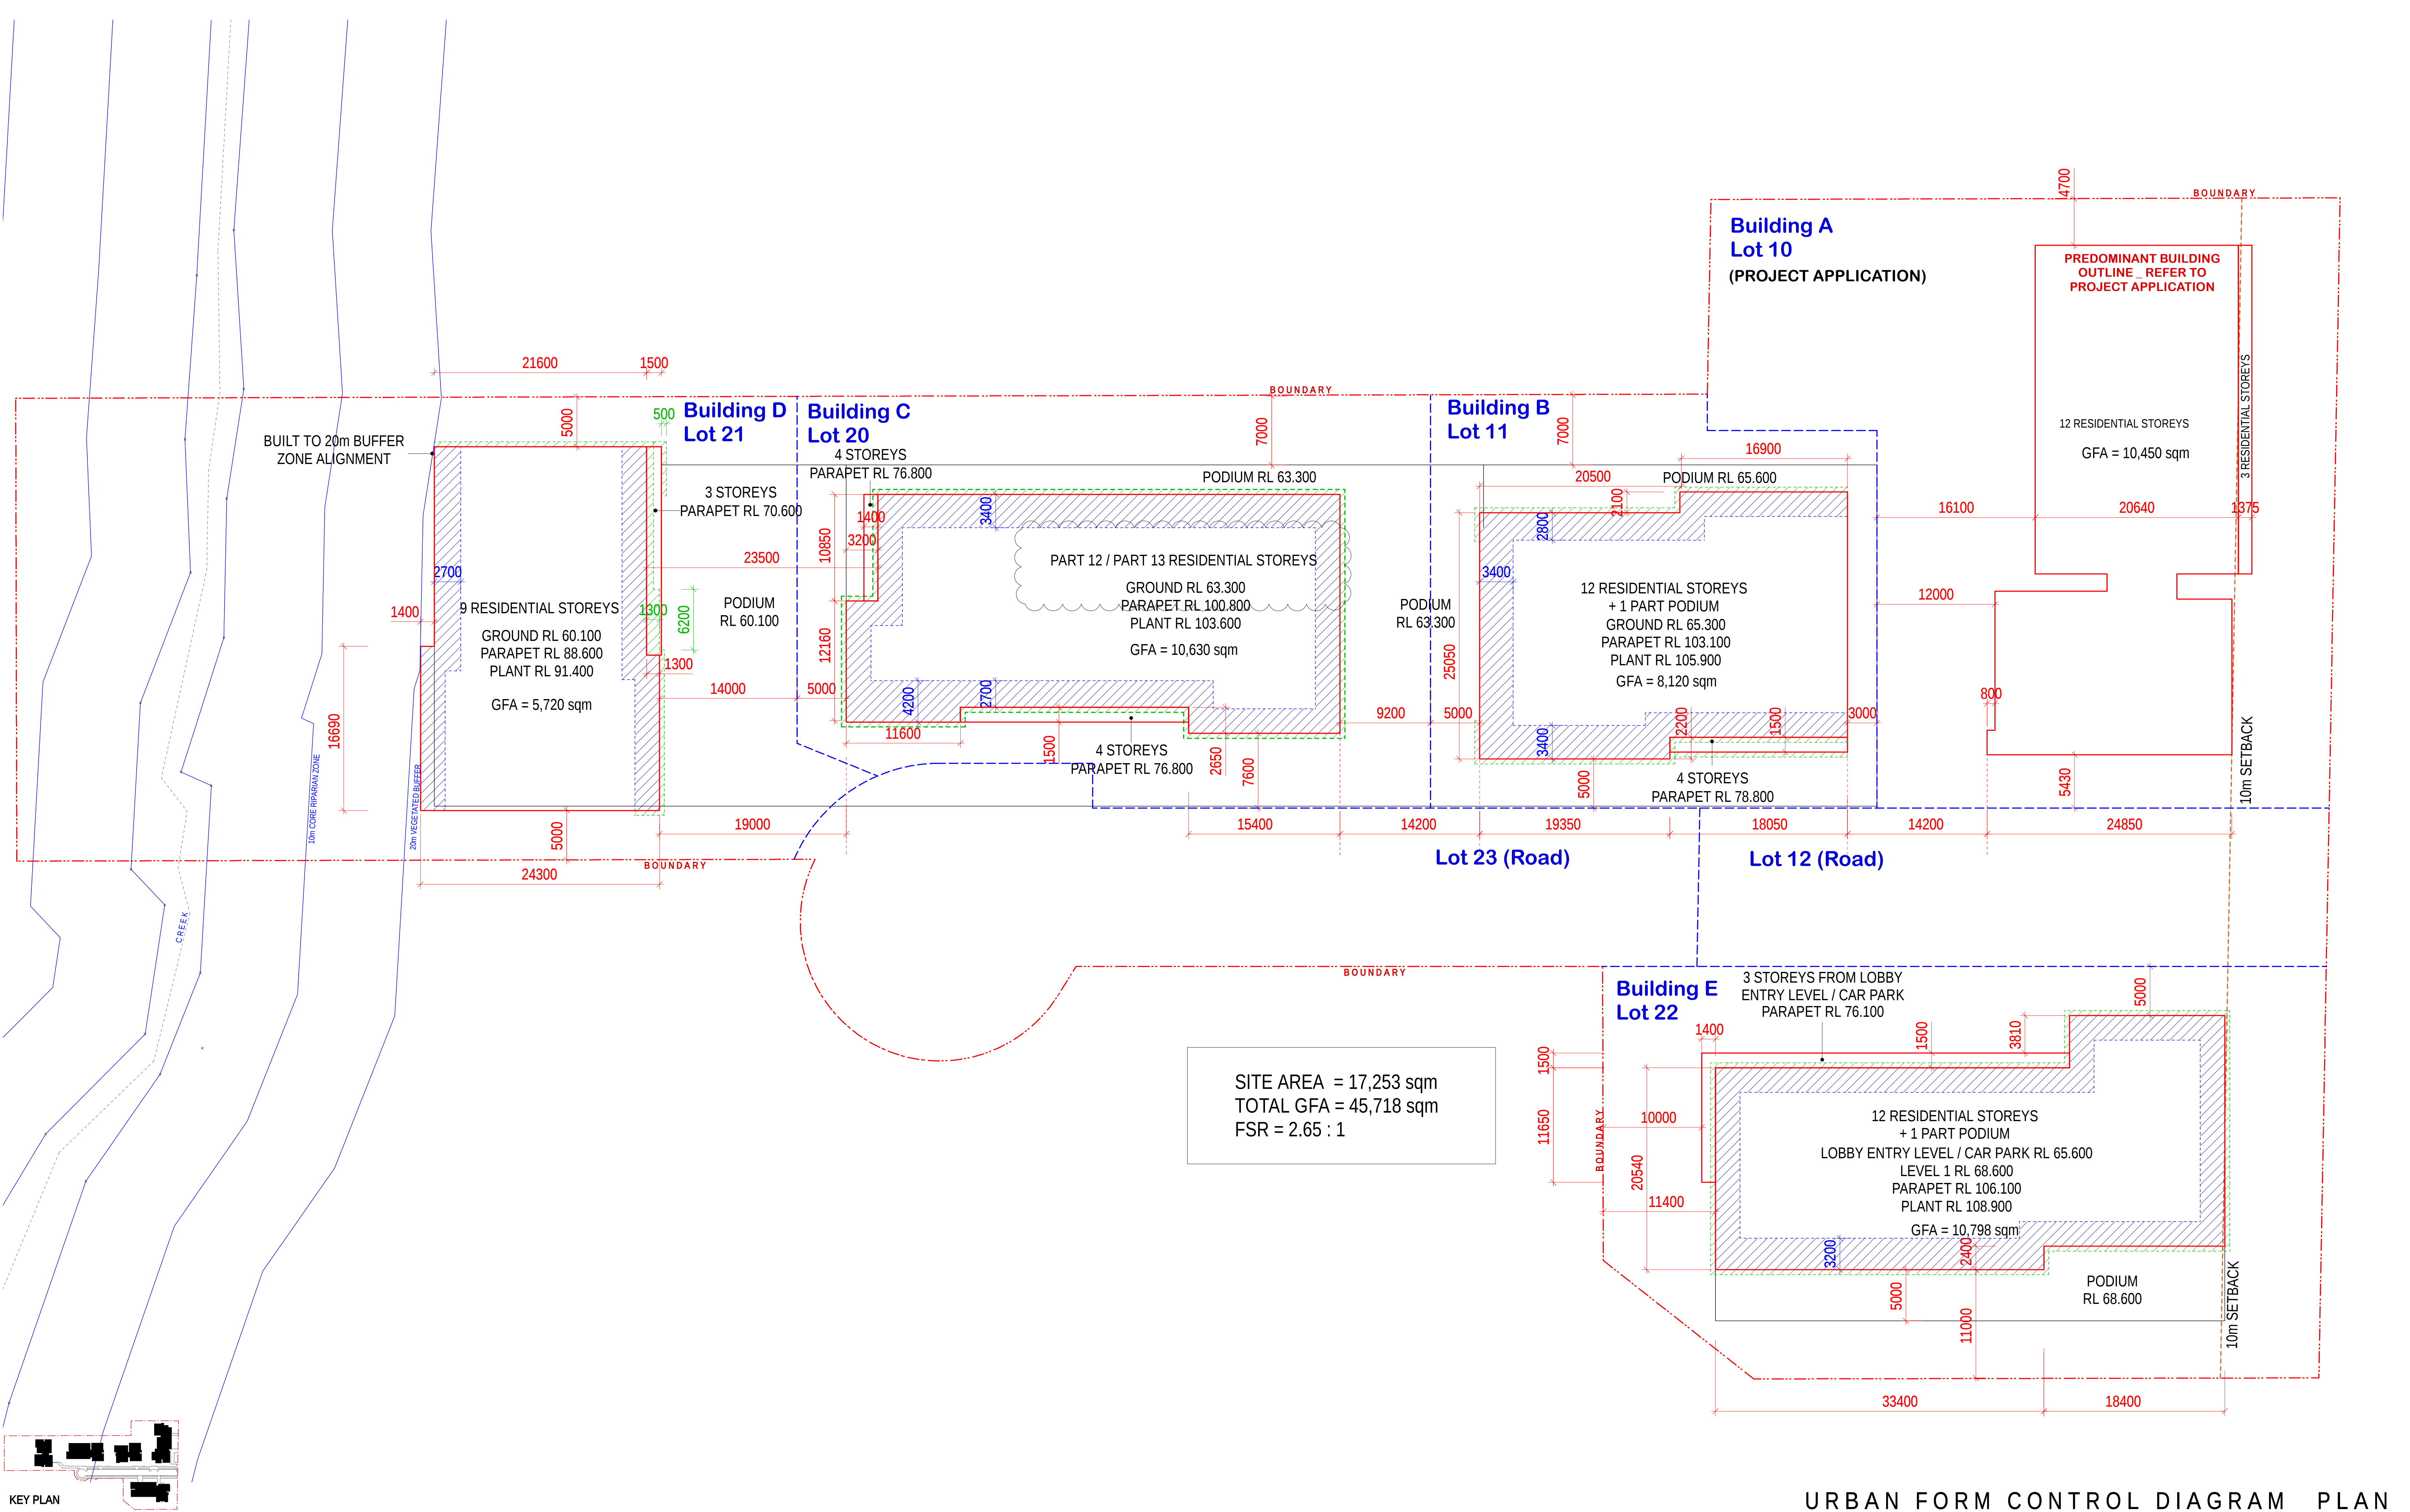

URBAN FORM CONTROL DIAGRAM _ PLAN

--- SITE BOUNDARY

--- STAGE BOUNDARY

GROUND LINE PODIUM PROFILE

PREDOMINANT FACADE LINE

ZONE FOR RE ENTRANT BALCONIES, 2.5 m DEEP - UNLESS OTHERWISE NOTED

ZONE FOR SAILIENT BALCONIES, 0.5 m DEEP - UNLESS OTHERWISE NOTED

NOTES

THIS DRAWING IS COPYRIGHT © AND SHALL REMAIN THE PROPERTY OF TURNER + ASSOCIATES ARCHITECTS. NO REPRODUCTION, WITHOUT PERMISSION, IN ANY FORM OR BY ANY MEANS, IS PERMITTED. THIS DRAWING IS NOT FOR CONSTRUCTION. DO NOT SCALE FROM DRAWING. DIMENSIONS SHALL TAKE PRECEDENCE.

CLIENT
TOGA GROUP
L5, 45 JONES STREET, ULTIMO NSW 2007
T 02 9356 1056 F 02 9356 1073

DCD Quality Endorsed Company (DCD 9003 2008)
Landscape Architect (L5)

PROJECT TITLE
RESIDENTIAL DEVELOPMENT
128 HERRING ROAD, MACQUARIE PARK

DRAWING TITLE
Urban Form Control Diagram, Plan
CONCEPT PLAN

Rev. Date Approved By

SCALE
1:250 @B1, 40% @ A3

STATUS
FOR INFORMATION

JOB NO.
09047

DRAWN
A 161

REV
J

TURNER + ASSOCIATES
L1 410 Crown Street Surry Hills NSW 2010 Australia
t +61 2 8668 0000 f +61 2 8668 0088