



9.




Key Plan 9
1 : 2500

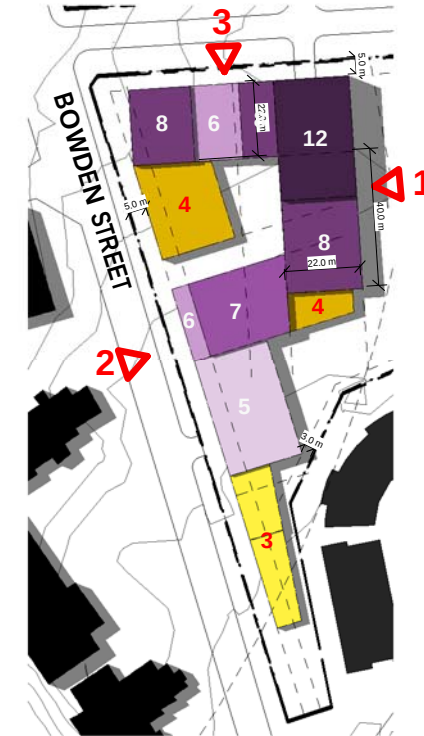


9. Building Envelope Plan
1 : 1000

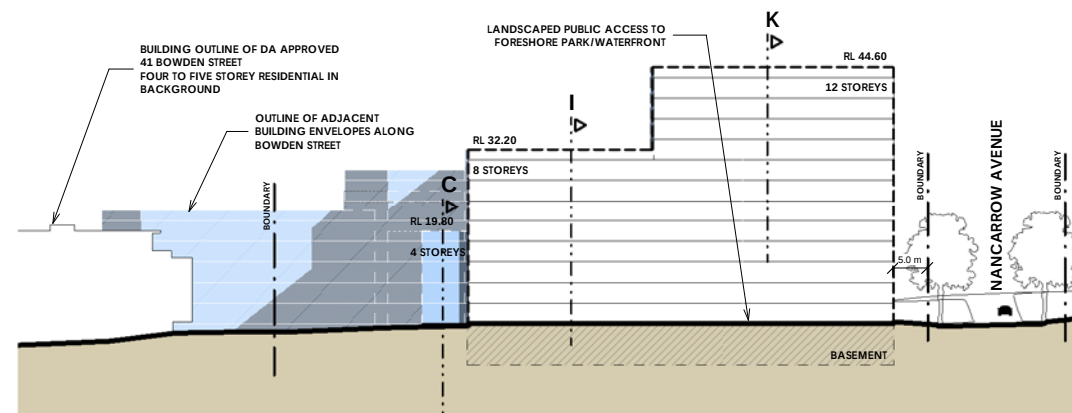

9. Elevation 1
1 : 500

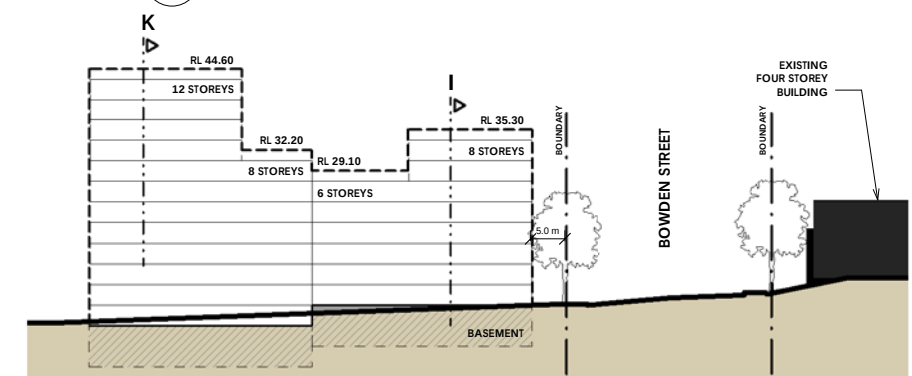

9. Nancarrow Avenue - South
1 : 500

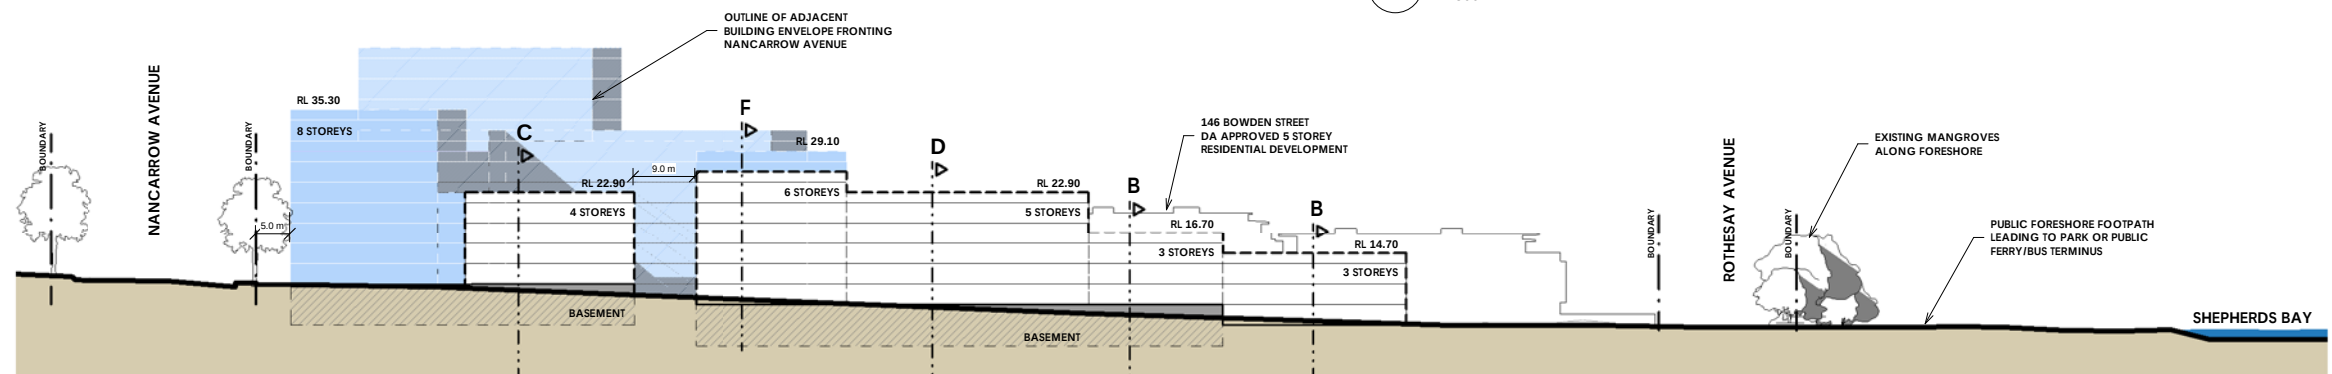

9. Bowden Street
1 : 500

SHEPHERDS BAY URBAN RENEWAL

PREFERRED PROJECT MASTER PLAN
STAGE 9. BUILDING ENVELOPE CONTROL DIAGRAMS

EA009-A

Job no: 10068, Date: 01/18/12, Scale: As indicated

ROBERTSON + MARKS